



FIRST FLOOR POWER AND LIGHTING PLAN  
1:100

- NOTES:
1. ALL 120V AND 208V LOADS ARE FEED FROM LP-M11.
  2. EMERGENCY LIGHTING EM-X-1, -2 ETC ARE FEED FROM BATTERY PACK EM-X.
  3. MOUNT TYPE A LUMINAIRE AT 2.75m ABOVE FINISHED FLOOR IN ELECTRICAL ROOM NO. 1.
  4. MOUNT TYPE A LUMINAIRE AT 3m ABOVE FINISHED FLOOR IN FIRE PUMP ROOM.

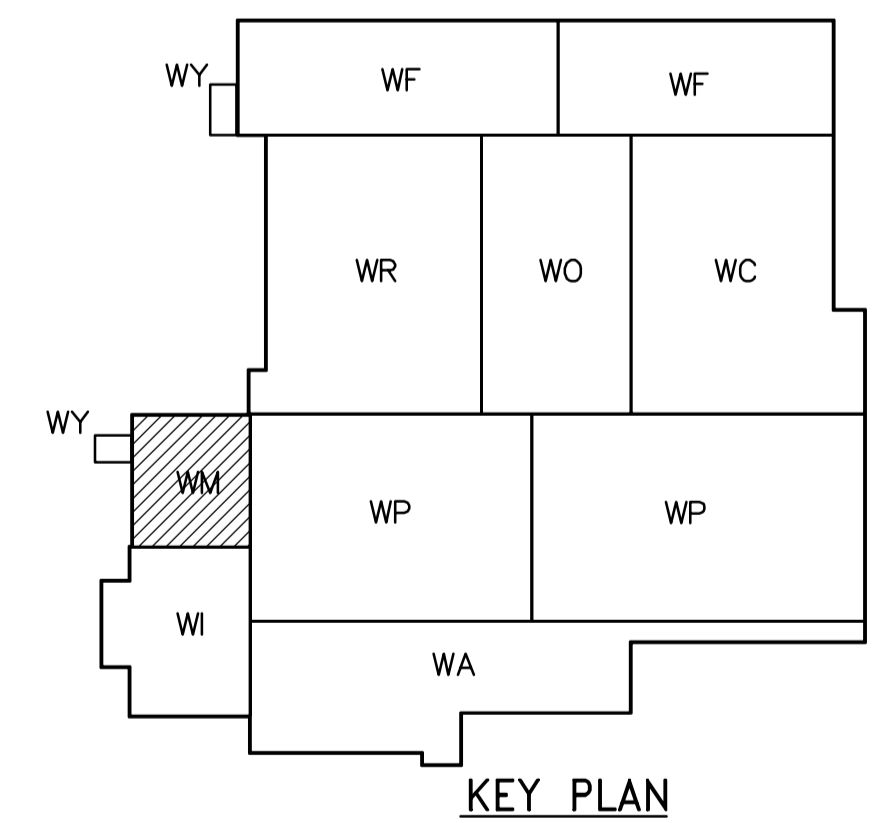

KEY PLAN

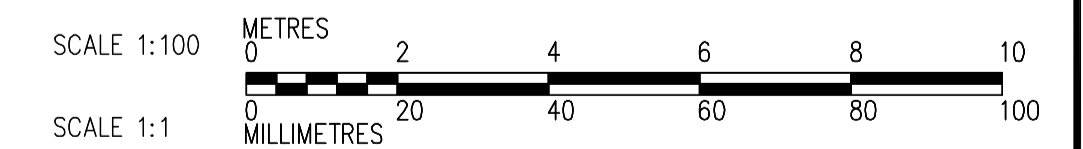

<p><b>APEGN</b> Certificate of Authorization CH2M HILL Canada Ltd. No. 1441 Expiry: April 30, 2006</p>	B.M. ELEV.	<p>Frederickson Cooper ARCHITECTS</p>	<p>EarthTech A Yoo International Ltd. Company</p>	ENGINEER'S SEAL	<p><b>THE CITY OF WINNIPEG</b> WATER AND WASTE DEPARTMENT ENGINEERING DIVISION</p>		
				DESIGNED BY JT		CHECKED BY ND	ORIGINAL SIGNED BY L.D. LLEWELLYN
				DRAWN BY KJ		APPROVED BY AHL	2006/03/29
				SCALE: 1:100		RELEASED FOR CONSTRUCTION BY: R. SOROKOWSKI	CONSULTANT DRAWING NO. WM-E0113
	00 ISSUED FOR TENDER 06/03/29 LL	DATE 2005/06/30	DATE 2006/03/29	<p>WATER TREATMENT PLANT GENERAL PLANT SERVICES/MISCELLANEOUS MECHANICAL AND ELECTRICAL</p>	CITY FILE NUMBER		
	NO. REVISIONS	DATE	BY		SHEET OF		
					CITY DRAWING NUMBER		
					1-0601M-A-E0113-001-000		
					<p>ELECTRICAL ELECTRICAL ROOM AREA FIRST FLOOR POWER AND LIGHTING PLAN</p>		