

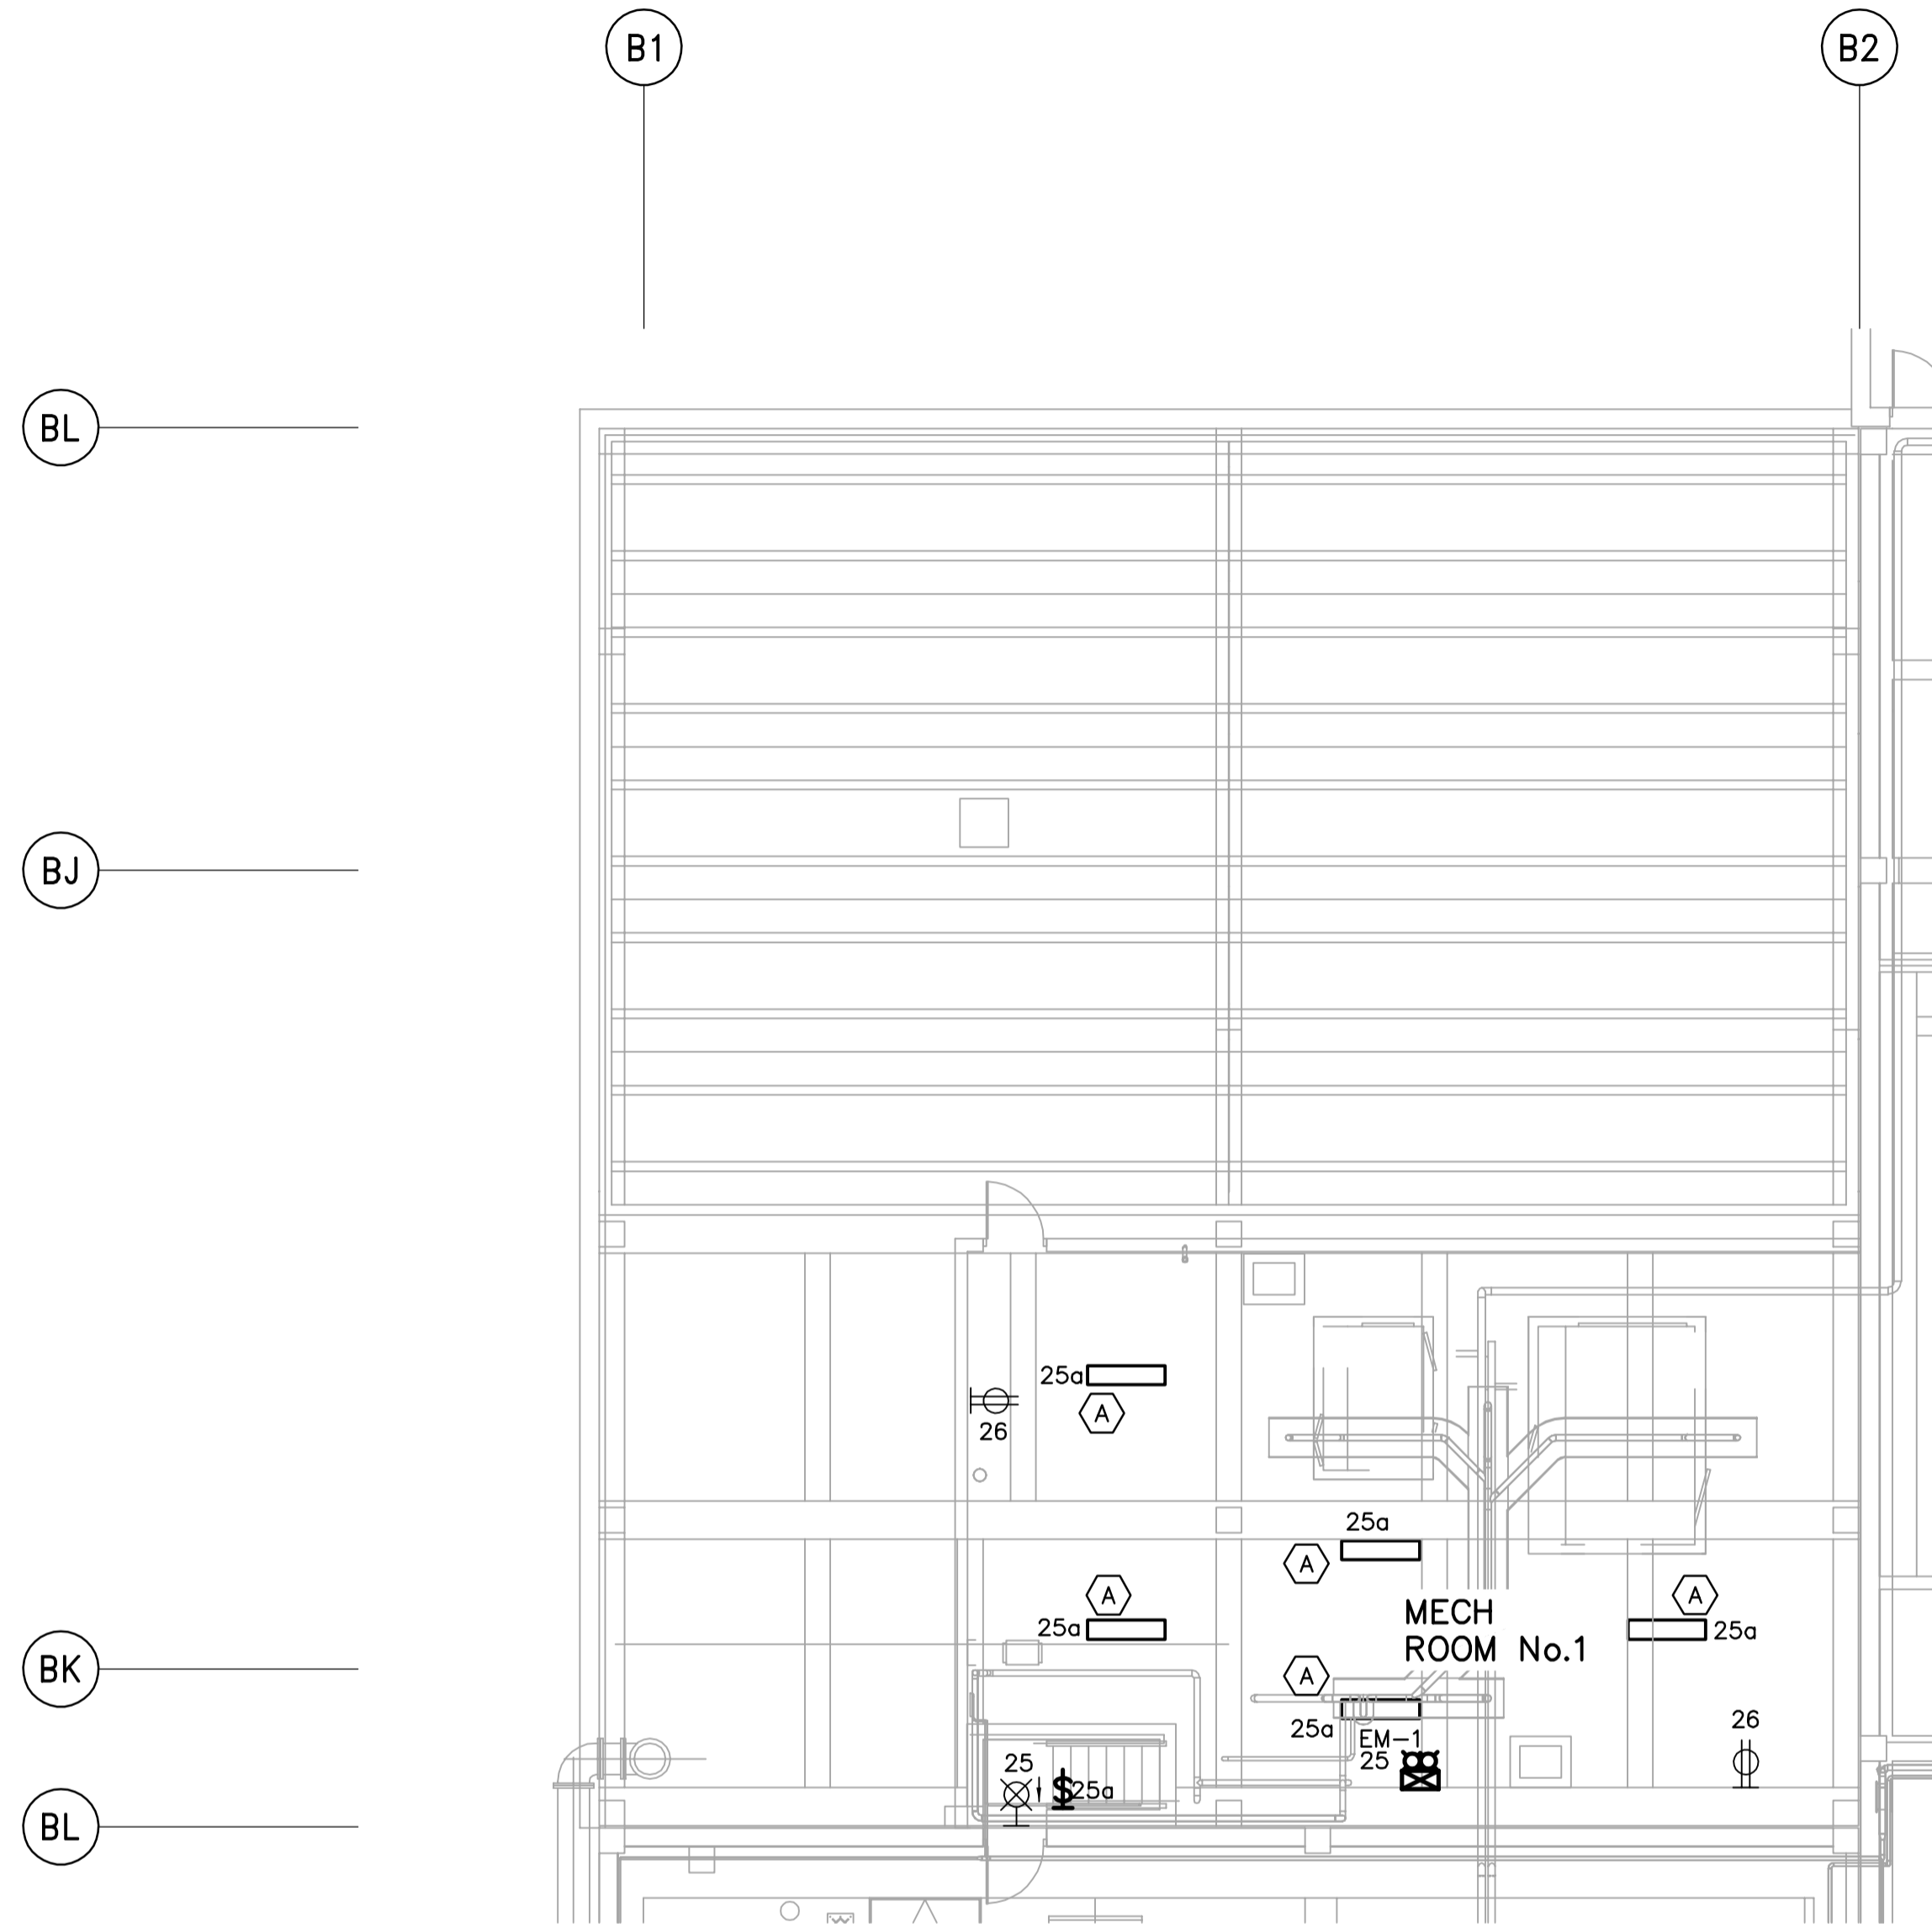


- NOTES:**
1. 120 AND 208V LOADS ARE FED FROM LP-M11
 2. MOUNT TYPE A LUMINAIRE AT 3.0m ABOVE THE FLOOR

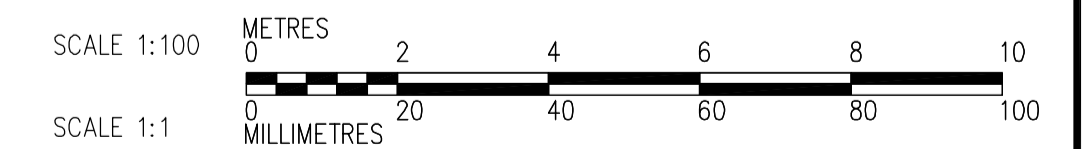

THIRD FLOOR POWER AND LIGHTING PLAN
1:100

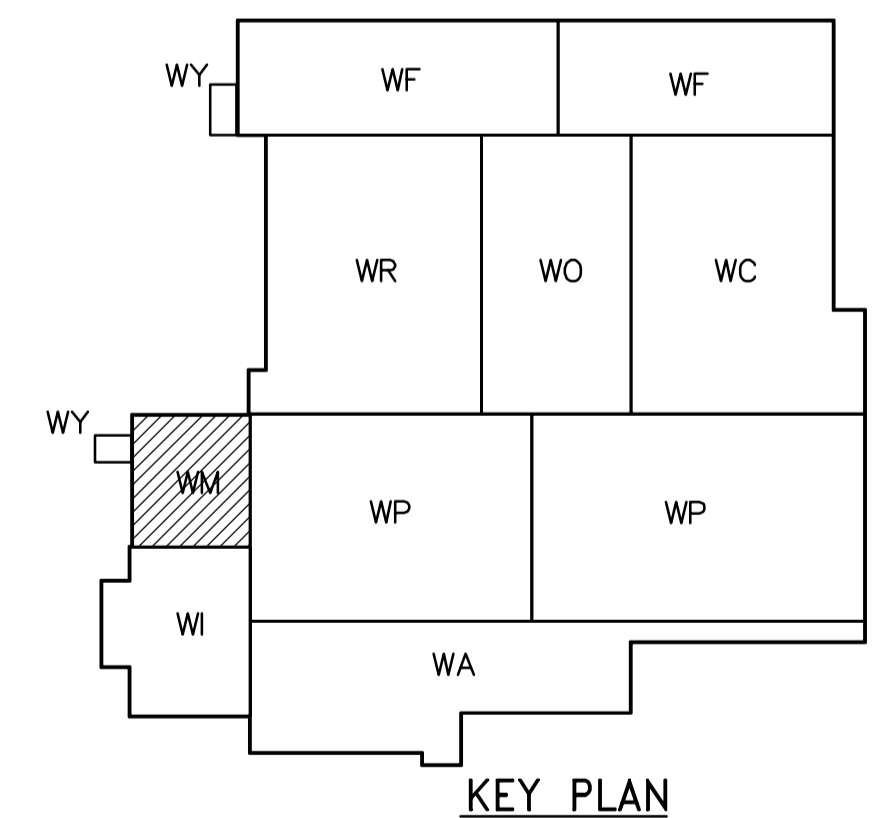

<p>APEGM Certificate of Authorization CH2M HILL Canada Ltd. No. 1441 Expiry: April 30, 2006</p>			ENGINEER'S SEAL	<p>THE CITY OF WINNIPEG WATER AND WASTE DEPARTMENT ENGINEERING DIVISION</p>	CITY FILE NUMBER
			DESIGNED BY: PF CHECKED BY: ND DRAWN BY: TL APPROVED BY: AHL SCALE: 1:100 RELEASED FOR CONSTRUCTION BY: R. SOROKOWSKI CONSULTANT DRAWING NO. WM-E0133		ORIGINAL SIGNED BY: L.D. LLEWELLYN DATE: 2006/03/29
B.M. ELEV.		NO. REVISIONS DATE BY		DATE: 2006/02/14 DATE: 2006/03/29	