



ROOF PLAN
1:100

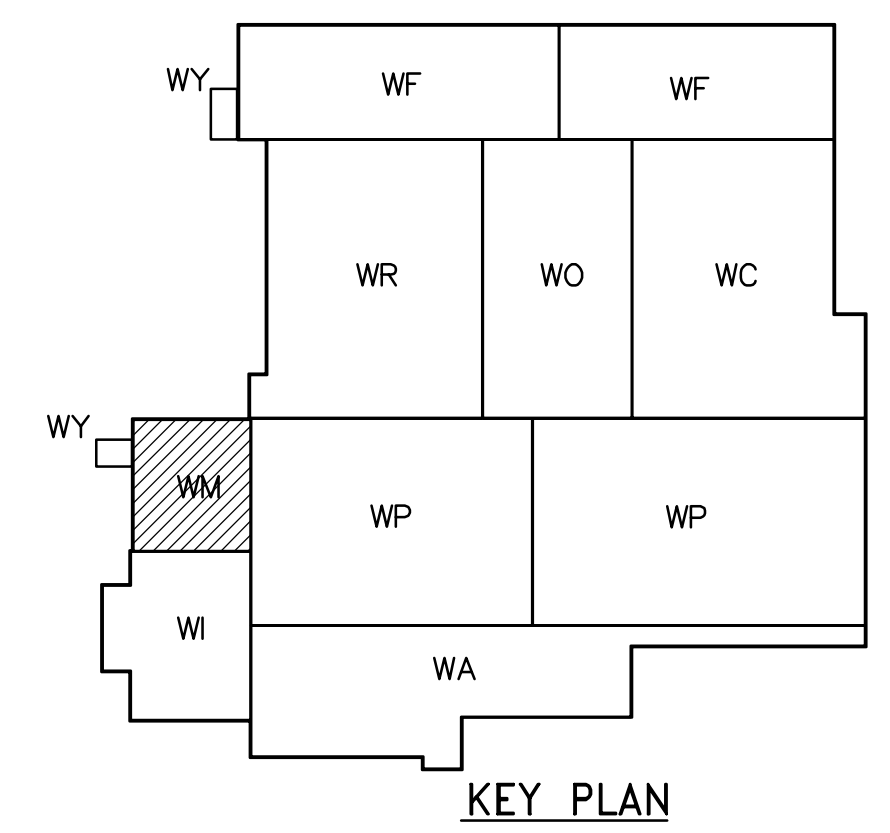

KEY PLAN

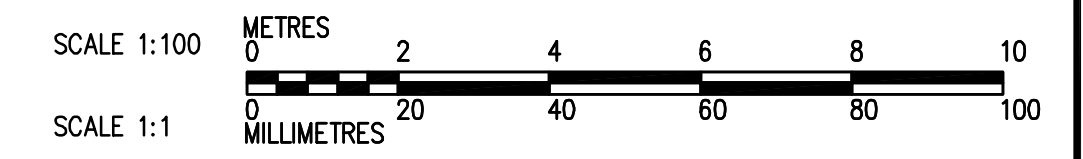

<p>APEGN Certificate of Authorization CH2M HILL Canada Ltd. No. 1441 Expiry: April 30, 2006</p>	<p>Frederickson Cooper ARCHITECTS</p>		<p>EarthTech A Tyco International Ltd. Company</p>		ENGINEER'S SEAL ORIGINAL SIGNED BY D.K. CUDDINGTON 2006/03/29	<p>THE CITY OF WINNIPEG WATER AND WASTE DEPARTMENT ENGINEERING DIVISION</p>	WATER TREATMENT PLANT GENERAL PLANT SERVICES/MISCELLANEOUS MECHANICAL AND ELECTRICAL	CITY FILE NUMBER SHEET OF
	DESIGNED BY JZ/SW CHECKED BY DL		APPROVED BY AHL		CONSULTANT DRAWING NO. WM-H0142		PLUMBING FIRE PUMP AND ELECTRICAL ROOM ROOF PLAN	CITY DRAWING NUMBER 1-0601M-A-H0142-001-000
	DRAWN BY JMcP SCALE: 1:100		RELEASED FOR CONSTRUCTION BY: R. SOROKOWSKI					
	00 ISSUED FOR TENDER 06/03/29 SW		2005/10/18 2006/03/29					