



THIRD FLOOR PROCESS PLAN
1:100

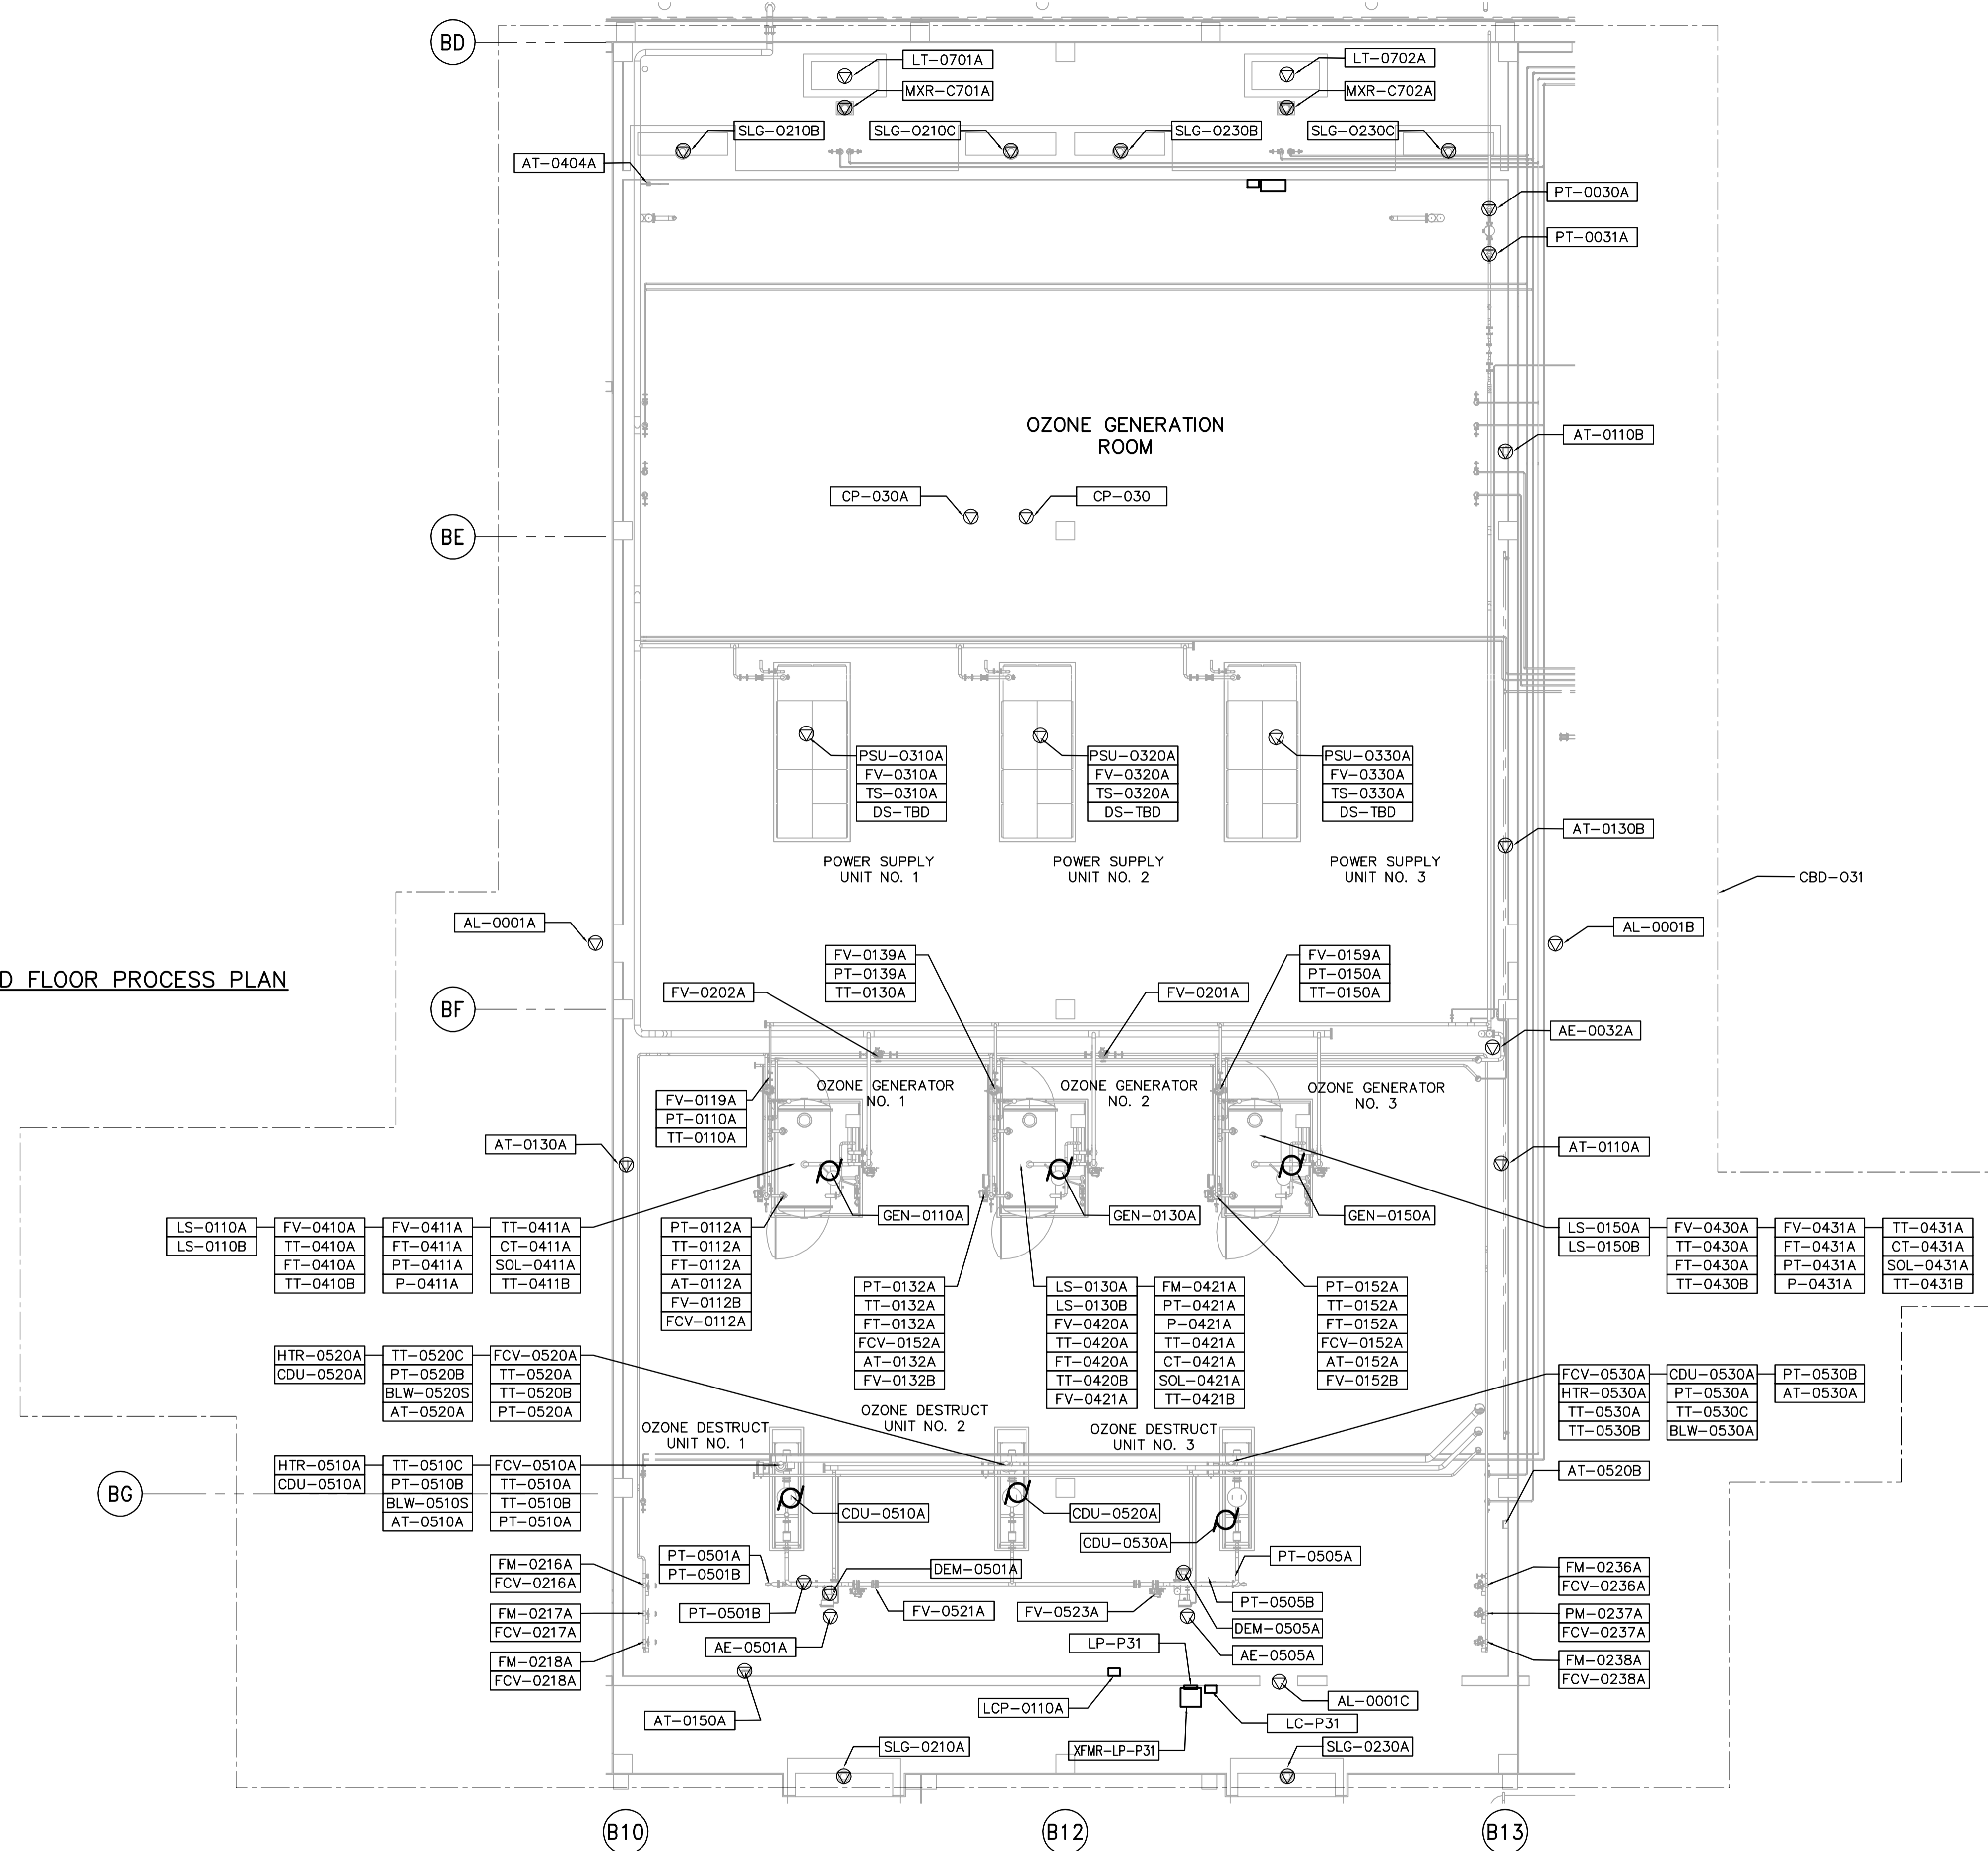

NOTES:
1. SEE MCC 4A & 4B SINGLE LINE DIAGRAMS AND PANEL SCHEDULES DP-H31 & DP-H32 FOR 600V POWER DISTRIBUTION.

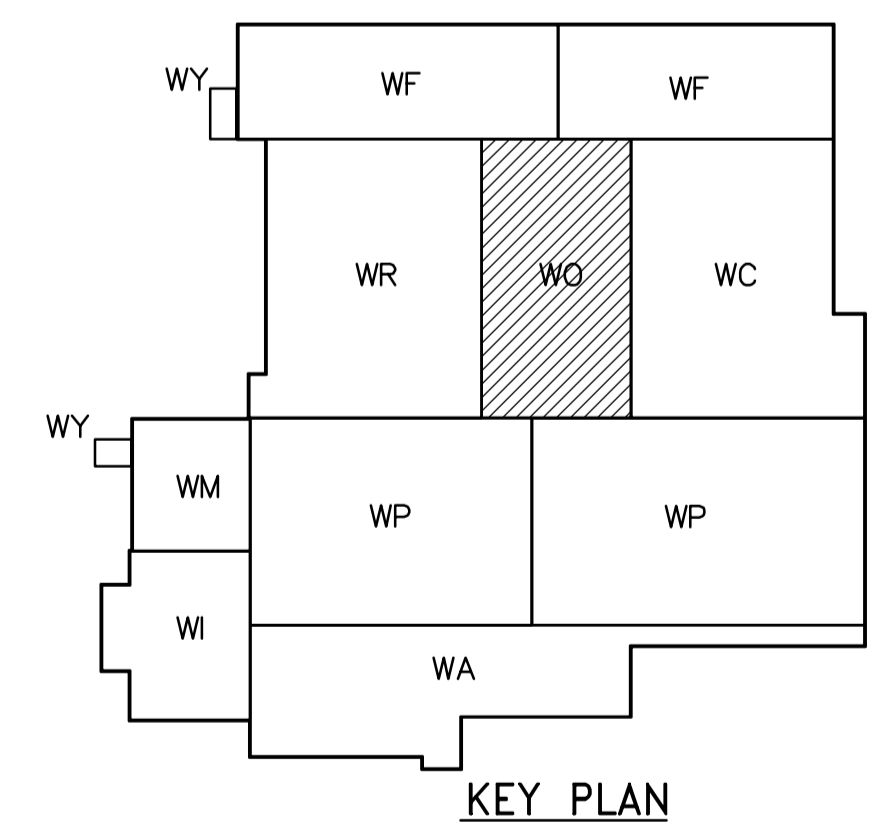

APEGN
Certificate of Authorization
CH2M HILL Canada Ltd.
No. 1441 Expiry: April 30, 2006

B.M. ELEV.			
DESIGNED BY	LL	CHECKED BY	ND
DRAWN BY	TL	APPROVED BY	AHL
SCALE:	1:100	RELEASED FOR CONSTRUCTION BY:	R. SOROKOWSKI
NO. REVISIONS		DATE	2005/07/13
ISSUED FOR TENDER	06/03/29	DATE	2006/03/29

CH2MHILL
Frederickson Cooper ARCHITECTS

EarthTech
A Yoo International Ltd. Company

DESIGNED BY: LL
CHECKED BY: ND
DRAWN BY: TL
APPROVED BY: AHL
SCALE: 1:100
RELEASED FOR CONSTRUCTION BY: R. SOROKOWSKI
DATE: 2006/03/29

ENGINEER'S SEAL
ORIGINAL SIGNED BY: L.D. LLEWELLYN
2006/03/29
CONSULTANT DRAWING NO.: WO-E0132

THE CITY OF WINNIPEG
WATER AND WASTE DEPARTMENT
ENGINEERING DIVISION

WATER TREATMENT PLANT
OZONE
MECHANICAL AND ELECTRICAL

ELECTRICAL
OZONATION AREA
THIRD FLOOR PROCESS PLAN

CITY FILE NUMBER
SHEET OF
CITY DRAWING NUMBER
1-06010-A-E0132-001-000