
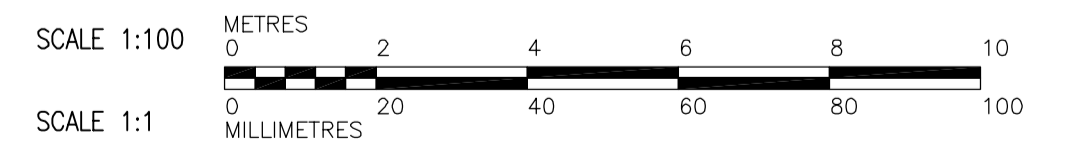


FIRST FLOOR PLAN
1:100

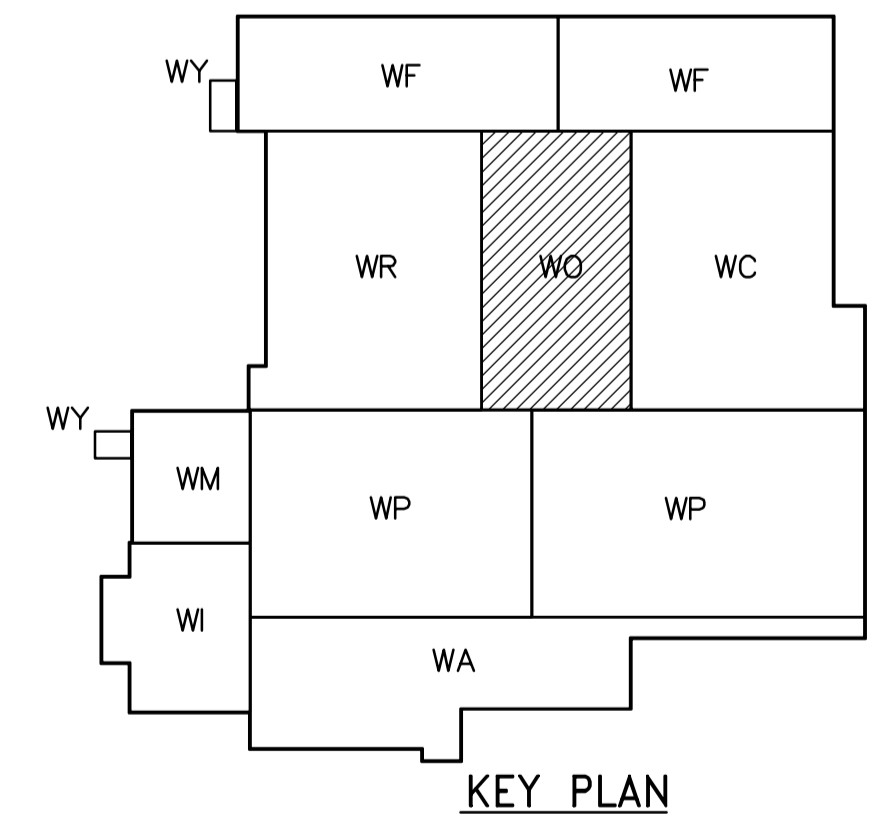

 APEGN Certificate of Authorization CH2M HILL Canada Ltd. No. 1441 Expiry: April 30, 2006	B.M. ELEV.	 Frederickson Cooper ARCHITECTS	 A Terra International Ltd. Company	ENGINEER'S SEAL ORIGINAL SIGNED BY D.K. CUDDINGTON 2006/03/29	 THE CITY OF WINNIPEG WATER AND WASTE DEPARTMENT ENGINEERING DIVISION	
	DESIGNED BY TT CHECKED BY DL DRAWN BY AM APPROVED BY AHL	SCALE: 1:100 RELEASED FOR CONSTRUCTION BY: R. SOROKOWSKI		CONSULTANT DRAWING NO. WO-H0111		WATER TREATMENT PLANT OZONE MECHANICAL AND ELECTRICAL
	00 ISSUED FOR TENDER 06/03/29 TT NO. REVISIONS DATE BY	DATE 2005/07/04 DATE 2006/03/29	HVAC OZONATION AREA FIRST FLOOR PLAN		CITY FILE NUMBER SHEET OF CITY DRAWING NUMBER 1-06010-A-H0111-001-000	