
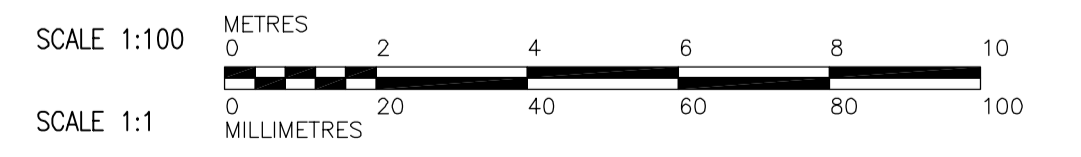


THIRD FLOOR PLAN
1:100

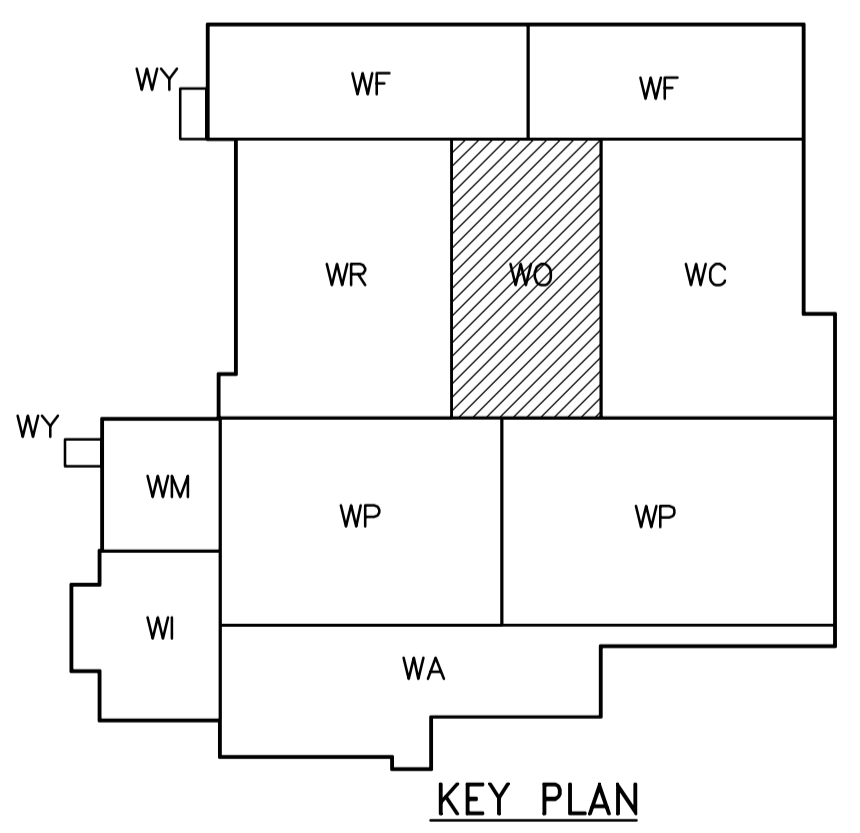

 Certificate of Authorization CH2M HILL Canada Ltd. No. 1441 Expiry: April 30, 2006	B.M. ELEV.		 Frederickson Cooper ARCHITECTS		 A Tyco International Ltd. Company		ENGINEER'S SEAL ORIGINAL SIGNED BY D.K. CUDDINGTON 2006/03/29		 THE CITY OF WINNIPEG WATER AND WASTE DEPARTMENT ENGINEERING DIVISION	
	DESIGNED BY TT DRAWN BY AM		CHECKED BY DL APPROVED BY AHL		SCALE: 1:100 RELEASED FOR CONSTRUCTION BY: R. SOROKOWSKI		CONSULTANT DRAWING NO. WO-H0131		WATER TREATMENT PLANT OZONE MECHANICAL AND ELECTRICAL	
	00 ISSUED FOR TENDER 06/03/29 TT		DATE 2005/07/04		DATE 2006/03/29		HVAC OZONATION AREA THIRD FLOOR PLAN		CITY FILE NUMBER SHEET OF CITY DRAWING NUMBER 1-06010-A-H0131-001-000	
	NO. REVISIONS		DATE BY		DATE		DATE		CITY FILE NUMBER SHEET OF CITY DRAWING NUMBER 1-06010-A-H0131-001-000	