



FOR PIPING CONTINUATION
SEE DWG. WC-H0142

NOTE:
ALL ROOF DRAIN AND PIPING
INSIDE OZONE GENERATOR
ROOM SHALL BE INSULATED
C/W ALUMINUM JACKETING

FOR PIPING CONTINUATION
SEE DWG. WC-H0142

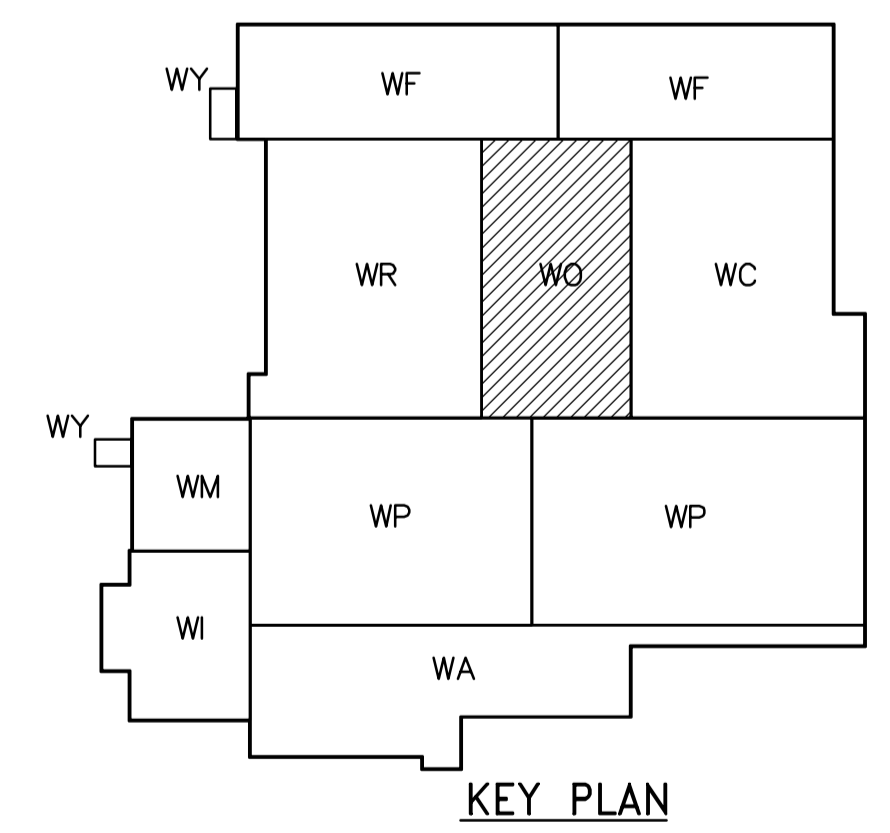

ROOF PLAN
1:100

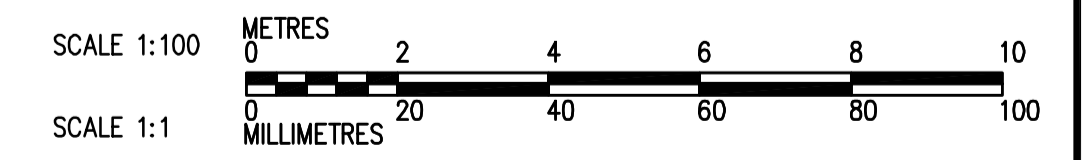

<p>APEGN Certificate of Authorization CH2M HILL Canada Ltd. No. 1441 Expiry: April 30, 2006</p>	<p>Frederickson Cooper ARCHITECTS</p>	<p>EarthTech A Tyco International Ltd. Company</p>	ENGINEER'S SEAL	<p>THE CITY OF WINNIPEG WATER AND WASTE DEPARTMENT ENGINEERING DIVISION</p>	
			DESIGNED BY: JZ/SW CHECKED BY: DL DRAWN BY: JMcP APPROVED BY: AHL SCALE: 1:100 RELEASED FOR CONSTRUCTION BY: R. SOROKOWSKI		ORIGINAL SIGNED BY: D.K. CUDDINGTON DATE: 2006/03/29 CONSULTANT DRAWING NO.: WO-H0142
B.M. ELEV.	DESIGNED BY: JZ/SW CHECKED BY: DL DRAWN BY: JMcP APPROVED BY: AHL SCALE: 1:100 RELEASED FOR CONSTRUCTION BY: R. SOROKOWSKI	ENGINEER'S SEAL	ORIGINAL SIGNED BY: D.K. CUDDINGTON DATE: 2006/03/29 CONSULTANT DRAWING NO.: WO-H0142	WATER TREATMENT PLANT OZONE MECHANICAL AND ELECTRICAL	CITY FILE NUMBER SHEET OF CITY DRAWING NUMBER 1-06010-A-H0142-001-000
00 ISSUED FOR TENDER 06/03/29 SW	INO. REVISIONS DATE BY DATE 2005/08/02 DATE 2006/03/29			PLUMBING OZONATION AREA ROOF PLAN	