
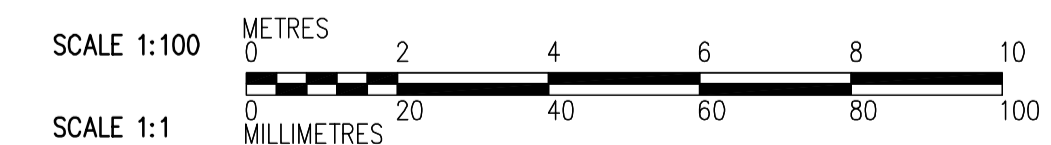


NOTES:

1. REFER TO SUPPLYCONTRACTOR SHOP DRAWINGS FOR EQUIPMENT DETAILS.
2. ALL GATES ARE SUPPLIED BY OTHERS. INSTALLATION BY THE CONTRACTOR.

THIRD FLOOR PLAN
1:100

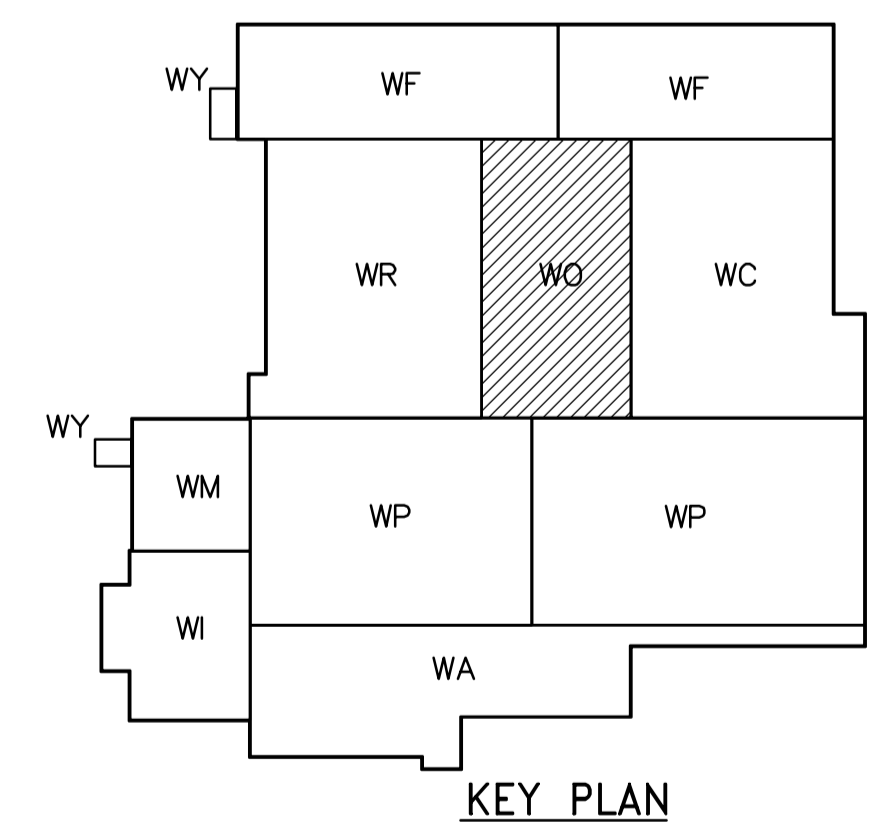

<p>APECM Certificate of Authorization CH2M HILL Canada Ltd. No. 1441 Expiry: April 30, 2006</p>	<p>Frederickson Cooper ARCHITECTS</p>	<p>EarthTech A Tyco International Ltd. Company</p>	ENGINEER'S SEAL	<p>THE CITY OF WINNIPEG WATER AND WASTE DEPARTMENT ENGINEERING DIVISION</p>
			DESIGNED BY: CBE/DP DRAWN BY: RWA/KM SCALE: 1:100	
B.M. ELEV.			CONSULTANT DRAWING NO.: WO-M0131	WATER TREATMENT PLANT OZONE MECHANICAL AND ELECTRICAL PROCESS MECHANICAL OZONATION AREA THIRD FLOOR PLAN
00 ISSUED FOR TENDER 06/03/29 CBE NO. REVISIONS DATE BY		DATE: 2006/02/14 DATE: 2006/03/29		