



NOT IN CONTRACT - FOR INFORMATION ONLY

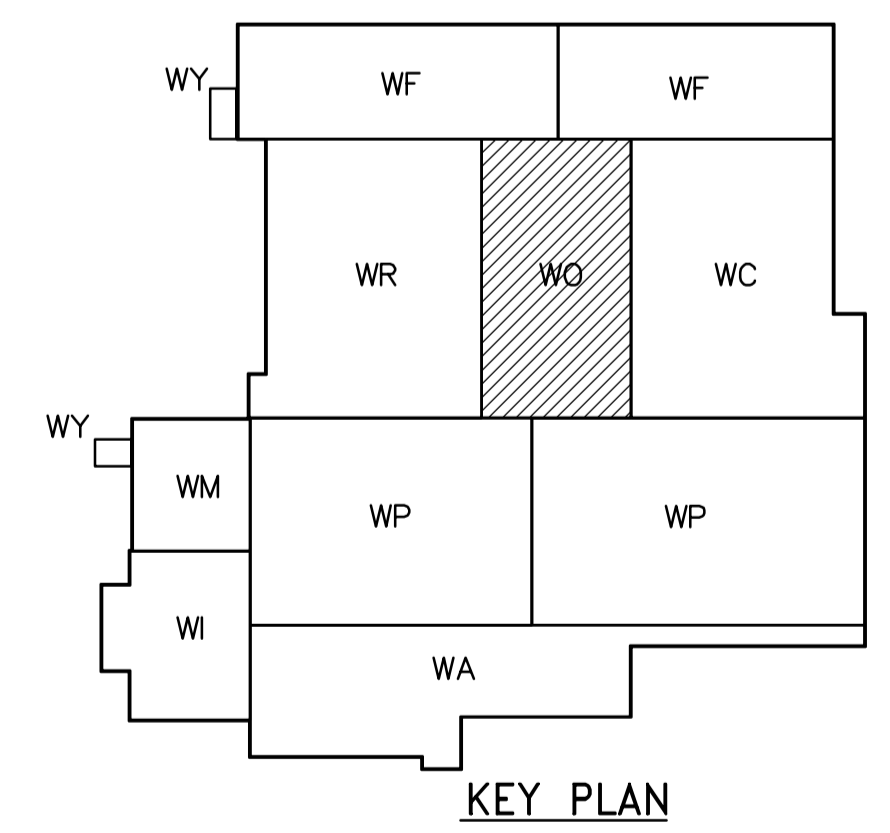

THIRD FLOOR PLAN
1:100

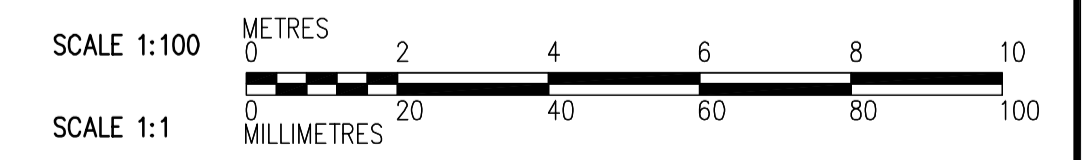

 APEGN Certificate of Authorization CH2M HILL Canada Ltd. No. 1441 Expiry: April 30, 2006	 CH2MHILL Frederickson Cooper ARCHITECTS	 EarthTech A Tyco International Ltd. Company	ENGINEER'S SEAL	 THE CITY OF WINNIPEG WATER AND WASTE DEPARTMENT ENGINEERING DIVISION	CITY FILE NUMBER
			DESIGNED BY: CBE/DP CHECKED BY: EM DRAWN BY: EK APPROVED BY: DJT SCALE: 1:100 RELEASED FOR CONSTRUCTION BY: R. SOROKOWSKI DATE: 2006/02/08		ORIGINAL SIGNED BY: D.J. PERNITSKY DATE: 2006/02/06 CONSULTANT DRAWING NO.: WO-M9131
B.M. ELEV.		00 ISSUED FOR TENDER 2006/02/03 DP NO. REVISIONS DATE BY DATE 2005/09/19 DATE 2006/02/08			