

- NOTES:
- SEE MCC #2A & #2B SINGLE LINE DIAGRAM AND DP-P11 & DP-P12 POWER DISTRIBUTION FOR 600V POWER DISTRIBUTION.
 - SEE LP-P11 FOR 120/208V POWER DISTRIBUTION.

DAF TANKS NO. 1 & NO. 2

DAF TANKS NO. 3 & NO. 4

FLOCCULATION TANK 1



FLOCCULATION TANK 2

FLOCCULATION TANK 3

FLOCCULATION TANK 4

ACCESS CORRIDOR No. 1
FL EL 236.170

FIRST FLOOR PROCESS PLAN (AREA 1)
1:100

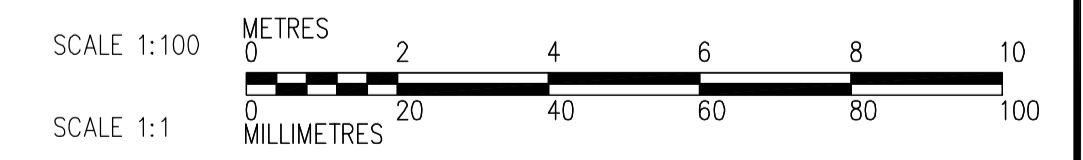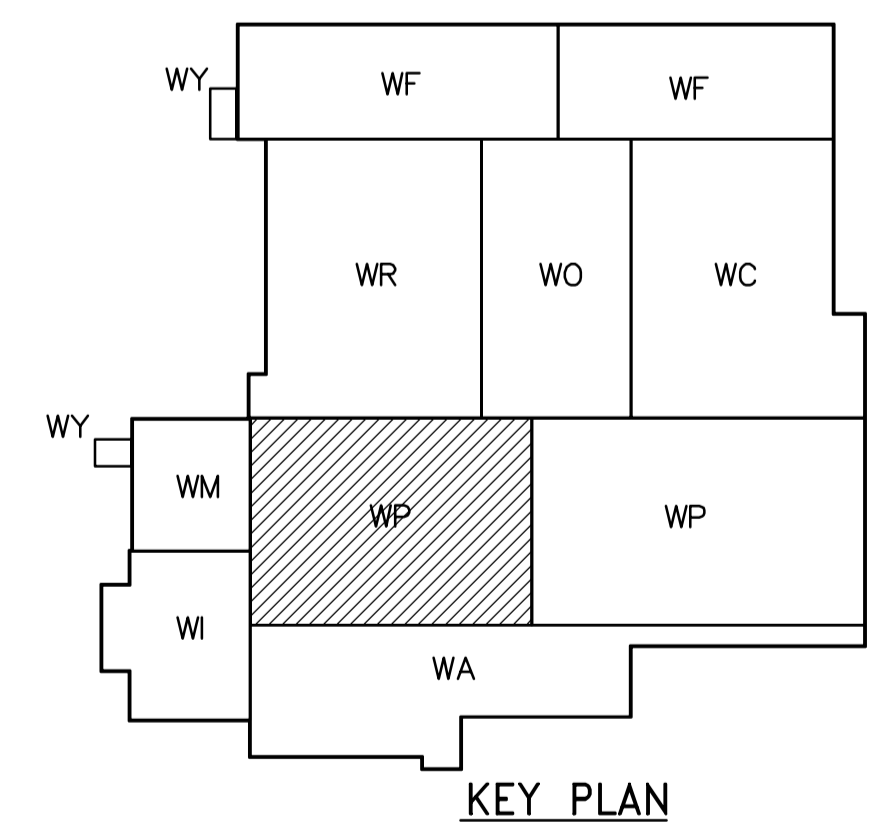

 APEGN Certificate of Authorization CH2M HILL Canada Ltd. No. 1441 Expiry: April 30, 2006	 Frederickson Cooper ARCHITECTS	 A Terra International Ltd. Company	ENGINEER'S SEAL	 THE CITY OF WINNIPEG WATER AND WASTE DEPARTMENT ENGINEERING DIVISION	CITY FILE NUMBER
			DESIGNED BY JT CHECKED BY ND DRAWN BY KJ APPROVED BY AHL SCALE: 1:100 RELEASED FOR CONSTRUCTION BY: R. SOROKOWSKI		ORIGINAL SIGNED BY L.D. LLEWELLYN 2006/03/29
B.M. ELEV.			CONSULTANT DRAWING NO. WP-E0113	WATER TREATMENT PLANT FLOCCULATION AND DAF MECHANICAL AND ELECTRICAL	CITY DRAWING NUMBER 1-0601P-A-E0113-001-000
00 ISSUED FOR TENDER 06/03/29 LL NO. REVISIONS DATE BY		DATE 2005/07/12 DATE 2006/03/29		ELECTRICAL FLOC/DAF AREA 1 FIRST FLOOR PROCESS PLAN	