



- NOTES:
1. ALL 120V AND 208V LOADS ARE FED FROM LP-P31
 2. SEE DRAWINGS WB-E0402 AND WB-E0403 FOR LUMINAIR MOUNTING DETAILS

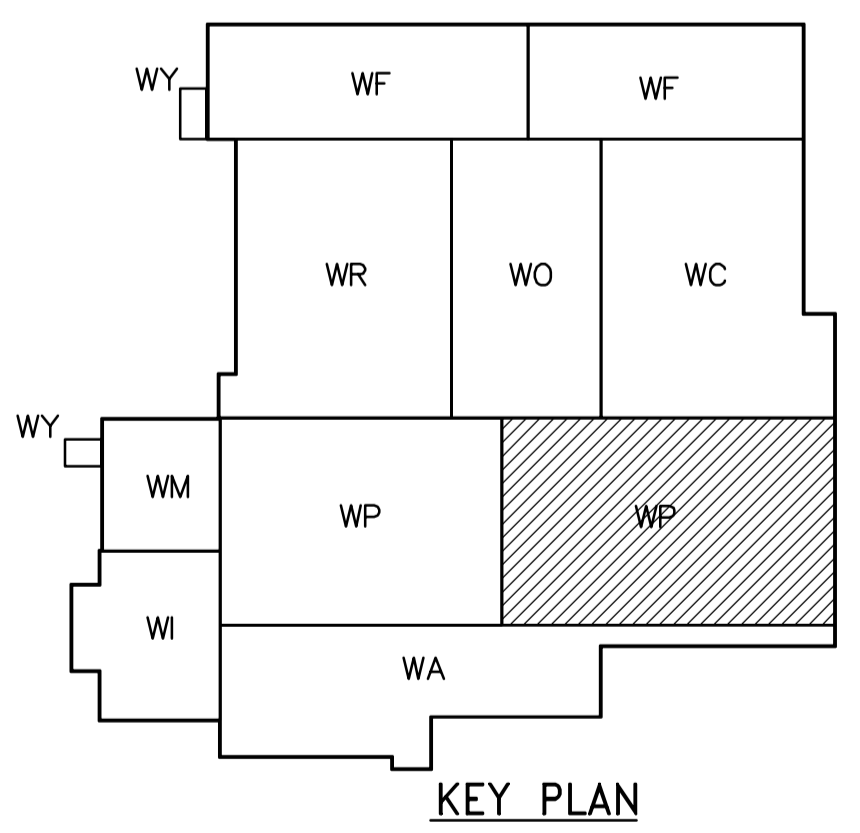

THIRD FLOOR POWER AND LIGHTING PLAN (AREA 2)
1:100

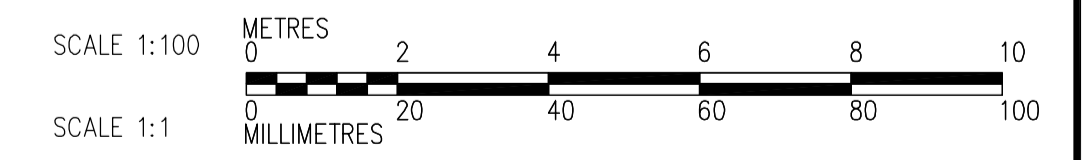

 Certificate of Authorization CH2M HILL Canada Ltd. No. 1441 Expiry: April 30, 2006	B.M. ELEV.	 Frederickson Cooper ARCHITECTS	 A 300 International Ltd. Company	ENGINEER'S SEAL	 THE CITY OF WINNIPEG WATER AND WASTE DEPARTMENT ENGINEERING DIVISION	
	DESIGNED BY LL			CHECKED BY ND		ORIGINAL SIGNED BY L.D. LLEWELLYN
	DRAWN BY TLL			APPROVED BY AHL		2006/03/29
	SCALE: 1:100			RELEASED FOR CONSTRUCTION BY: R. SOROKOWSKI		CONSULTANT DRAWING NO. WP-E0136
00 ISSUED FOR TENDER	06/03/29	DATE 2005/07/12	DATE 2006/03/29	WATER TREATMENT PLANT FLOCCULATION AND DAF MECHANICAL AND ELECTRICAL	CITY FILE NUMBER SHEET OF CITY DRAWING NUMBER 1-0601P-A-E0136-001-000	