


FIRST FLOOR PLAN
1:100

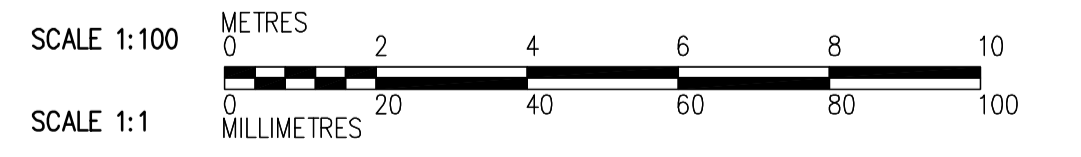

<p>APEGN Certificate of Authorization CH2M HILL Canada Ltd. No. 1441 Expiry: April 30, 2006</p>	<p>Frederickson Cooper ARCHITECTS</p>	<p>EarthTech A Tyco International Ltd. Company</p>	ENGINEER'S SEAL	<p>THE CITY OF WINNIPEG WATER AND WASTE DEPARTMENT ENGINEERING DIVISION</p>		
			DESIGNED BY TT		CHECKED BY DL	ORIGINAL SIGNED BY D.K. CUDDINGTON
			DRAWN BY AM		APPROVED BY AHL	2006/03/29
			SCALE: 1:100		RELEASED FOR CONSTRUCTION BY: R. SOROKOWSKI	CONSULTANT DRAWING NO. WP-H0111
B.M. ELEV.	00 ISSUED FOR TENDER 06/03/29 TT	DATE 2005/07/04	DATE 2006/03/29	<p>WATER TREATMENT PLANT FLOCCULATION AND DAF MECHANICAL AND ELECTRICAL</p> <p>HVAC FLOC/DAF AREA 1 FIRST FLOOR PLAN</p>		
NO. REVISIONS	DATE	BY	DATE	<p>CITY FILE NUMBER</p> <p>SHEET OF</p> <p>CITY DRAWING NUMBER</p> <p>1-0601P-A-H0111-001-000</p>		