


FIRST FLOOR PLAN
1:100

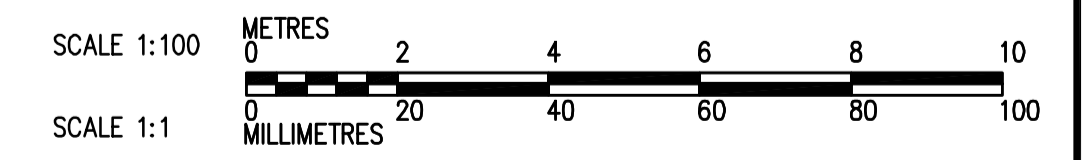

 Certificate of Authorization CH2M HILL Canada Ltd. No. 1441 Expiry: April 30, 2006	B.M. ELEV. <table border="1"> <tr><td> </td><td> </td><td> </td></tr> <tr><td> </td><td> </td><td> </td></tr> <tr><td> </td><td> </td><td> </td></tr> </table>										 Frederickson Cooper ARCHITECTS	 A Yeo International Ltd. Company	ENGINEER'S SEAL ORIGINAL SIGNED BY D.K. CUDDINGTON 2006/03/29	 THE CITY OF WINNIPEG WATER AND WASTE DEPARTMENT ENGINEERING DIVISION WATER TREATMENT PLANT FLOCCULATION AND DAF MECHANICAL AND ELECTRICAL PLUMBING FLOC/DAF AREA 1 FIRST FLOOR PLAN	CITY FILE NUMBER SHEET OF
DESIGNED BY JZ/SW DRAWN BY JMcP SCALE: 1:100	CHECKED BY DL APPROVED BY AHL RELEASED FOR CONSTRUCTION BY: R. SOROKOWSKI	CONSULTANT DRAWING NO. WP-H0113	CITY DRAWING NUMBER 1-0601P-A-H0113-001-000												
00 ISSUED FOR TENDER 06/03/29 SW NO. REVISIONS DATE BY	2005/07/15 DATE 2006/03/29 DATE	00 ISSUED FOR TENDER 06/03/29 SW NO. REVISIONS DATE BY	2005/07/15 DATE 2006/03/29 DATE												
00 ISSUED FOR TENDER 06/03/29 SW NO. REVISIONS DATE BY	2005/07/15 DATE 2006/03/29 DATE	00 ISSUED FOR TENDER 06/03/29 SW NO. REVISIONS DATE BY	2005/07/15 DATE 2006/03/29 DATE												