


SECOND FLOOR PLAN  
1:100

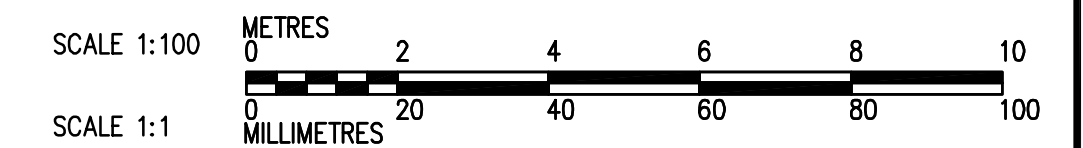

 <b>APEGN</b> Certificate of Authorization CH2M HILL Canada Ltd. No. 1441 Expiry: April 30, 2006	 Frederickson Cooper ARCHITECTS	 A Terra International Ltd. Company	ENGINEER'S SEAL	 <b>THE CITY OF WINNIPEG</b> WATER AND WASTE DEPARTMENT ENGINEERING DIVISION	CITY FILE NUMBER
			DESIGNED BY TT CHECKED BY DL DRAWN BY AM APPROVED BY AHL SCALE: 1:100 RELEASED FOR CONSTRUCTION BY: R. SOROKOWSKI		ORIGINAL SIGNED BY D.K. CUDDINGTON 2006/03/29
00 ISSUED FOR TENDER 06/03/29 TT NO. REVISIONS DATE BY	DATE 2005/07/15	DATE 2006/03/29	CONSULTANT DRAWING NO. WP-H0121	HVAC FLOC/DAF AREA 1 SECOND FLOOR PLAN	CITY DRAWING NUMBER 1-0601P-A-H0121-001-000