


SECOND FLOOR PLAN
1:100

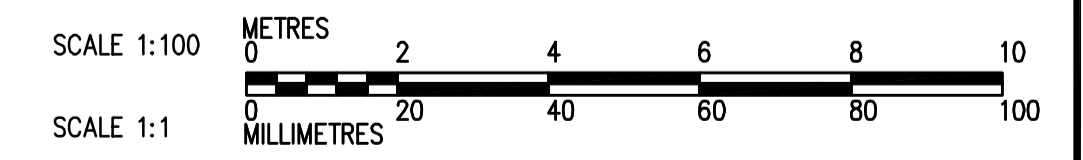

 APEGN Certificate of Authorization CH2M HILL Canada Ltd. No. 1441 Expiry: April 30, 2006	 CH2MHILL Frederickson Cooper ARCHITECTS	 EarthTech A Tyco International Ltd. Company	ENGINEER'S SEAL	 THE CITY OF WINNIPEG WATER AND WASTE DEPARTMENT ENGINEERING DIVISION	WATER TREATMENT PLANT FLOCCULATION AND DAF MECHANICAL AND ELECTRICAL	CITY FILE NUMBER SHEET OF CITY DRAWING NUMBER 1-0601P-A-H0122-001-000		
			DESIGNED BY TT				CHECKED BY DL	ORIGINAL SIGNED BY D.K. CUDDINGTON
			DRAWN BY AM				APPROVED BY AHL	2006/03/29
			SCALE: 1:100				RELEASED FOR CONSTRUCTION BY: R. SOROKOWSKI	CONSULTANT DRAWING NO. WP-H0122
00 ISSUED FOR TENDER 06/03/29 TT	DATE 2005/07/04	DATE 2006/03/29						