


THIRD FLOOR PLAN  
1:100

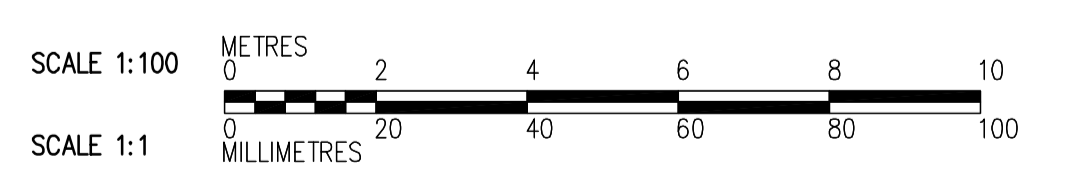

<p><b>APECA</b> Certificate of Authorization CH2M HILL Canada Ltd. No. 1441 Expiry: April 30, 2006</p>	<table border="1"> <tr> <td>B.M. ELEV.</td> <td></td> <td></td> <td></td> </tr> <tr> <td></td> <td></td> <td></td> <td></td> </tr> <tr> <td></td> <td></td> <td></td> <td></td> </tr> <tr> <td></td> <td></td> <td></td> <td></td> </tr> <tr> <td>00</td> <td>ISSUED FOR TENDER</td> <td>06/03/29</td> <td>TT</td> </tr> <tr> <td>NO.</td> <td>REVISIONS</td> <td>DATE</td> <td>BY</td> </tr> </table>	B.M. ELEV.																00	ISSUED FOR TENDER	06/03/29	TT	NO.	REVISIONS	DATE	BY	<p>Frederickson Cooper ARCHITECTS</p>	<p>EarthTech A Tyco International Ltd. Company</p>	<p>ENGINEER'S SEAL</p> <p>ORIGINAL SIGNED BY D.K. CUDDINGTON 2006/03/29</p> <p>CONSULTANT DRAWING NO. WP-H0131</p>	<p><b>THE CITY OF WINNIPEG</b> WATER AND WASTE DEPARTMENT ENGINEERING DIVISION</p> <p>WATER TREATMENT PLANT FLOCCULATION AND DAF MECHANICAL AND ELECTRICAL</p> <p>HVAC FLOC/DAF AREA 1 THIRD FLOOR PLAN</p>	<p>CITY FILE NUMBER</p> <p>SHEET OF</p> <p>CITY DRAWING NUMBER</p> <p>1-0601P-A-H0131-001-000</p>
		B.M. ELEV.																												
00	ISSUED FOR TENDER	06/03/29	TT																											
NO.	REVISIONS	DATE	BY																											
<p>DESIGNED BY TT</p> <p>CHECKED BY DL</p> <p>DRAWN BY AM</p> <p>APPROVED BY AHL</p> <p>SCALE: 1:100</p> <p>RELEASED FOR CONSTRUCTION BY: R. SOROKOWSKI</p> <p>DATE 2005/07/04</p> <p>DATE 2006/03/29</p>																														