


ROOF PLAN  
1:100

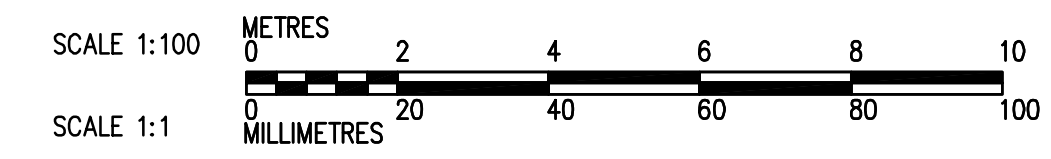

 Certificate of Authorization CH2M HILL Canada Ltd. No. 1441 Expiry: April 30, 2006	 Frederickson Cooper ARCHITECTS		 A Tyco International Ltd. Company		ENGINEER'S SEAL  ORIGINAL SIGNED BY D.K. CUDDINGTON  2006/03/29	 THE CITY OF WINNIPEG WATER AND WASTE DEPARTMENT ENGINEERING DIVISION  WATER TREATMENT PLANT FLOCCULATION AND DAF MECHANICAL AND ELECTRICAL  PLUMBING FLOC/DAF AREA 2 ROOF PLAN	CITY FILE NUMBER
	DESIGNED BY JZ/SW      CHECKED BY DL		APPROVED BY AHL		SHEET OF		
	DRAWN BY JMcP      SCALE: 1:100		RELEASED FOR CONSTRUCTION BY: R. SOROKOWSKI		CITY DRAWING NUMBER		
	00 ISSUED FOR TENDER      06/03/29      SW		DATE 2005/07/15      DATE 2006/03/29		1-0601P-A-H0144-001-000		
NO. REVISIONS      DATE      BY		DATE 2005/07/15      DATE 2006/03/29		CONSULTANT DRAWING NO. WP-H0144			