



NOT IN CONTRACT - FOR INFORMATION ONLY

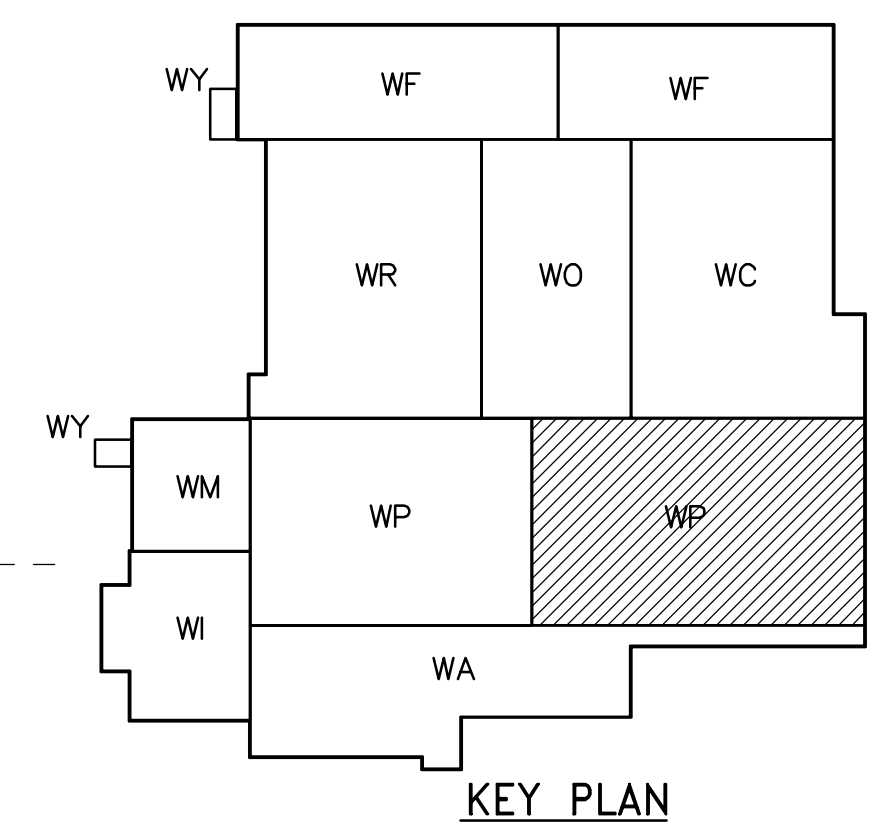

FIRST FLOOR PLAN  
1:100

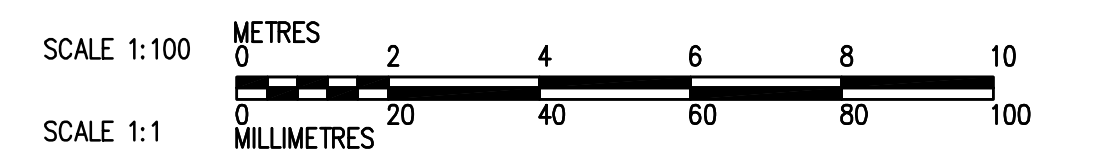

 <b>APEGN</b> Certificate of Authorization CH2M HILL Canada Ltd. No. 1441 Expiry: April 30, 2006	B.M. ELEV.	 Frederickson Cooper ARCHITECTS	 A Terra International Ltd. Company	ENGINEER'S SEAL	 <b>THE CITY OF WINNIPEG</b> WATER AND WASTE DEPARTMENT ENGINEERING DIVISION
	DESIGNED BY JZ/SW			CHECKED BY DL	
		DRAWN BY JMcP	APPROVED BY DJT	2006/02/06	WATER TREATMENT PLANT FLOCCULATION AND DAF FOUNDATIONS AND CONCRETE STRUCTURES
		SCALE: 1:100	RELEASED FOR CONSTRUCTION BY: R. SOROKOWSKI	CONSULTANT DRAWING NO. WP-H9114	
	00 ISSUED FOR TENDER 2006/02/03 SW	DATE 2005/07/15	DATE 2006/02/08		SHEET OF
					CITY DRAWING NUMBER
					<b>1-060P-A-H914-001-00D</b>
					PLUMBING PIPE EMBEDS FLOC/DAF AREA 2 FIRST FLOOR PLAN