



NOT IN CONTRACT - FOR INFORMATION ONLY

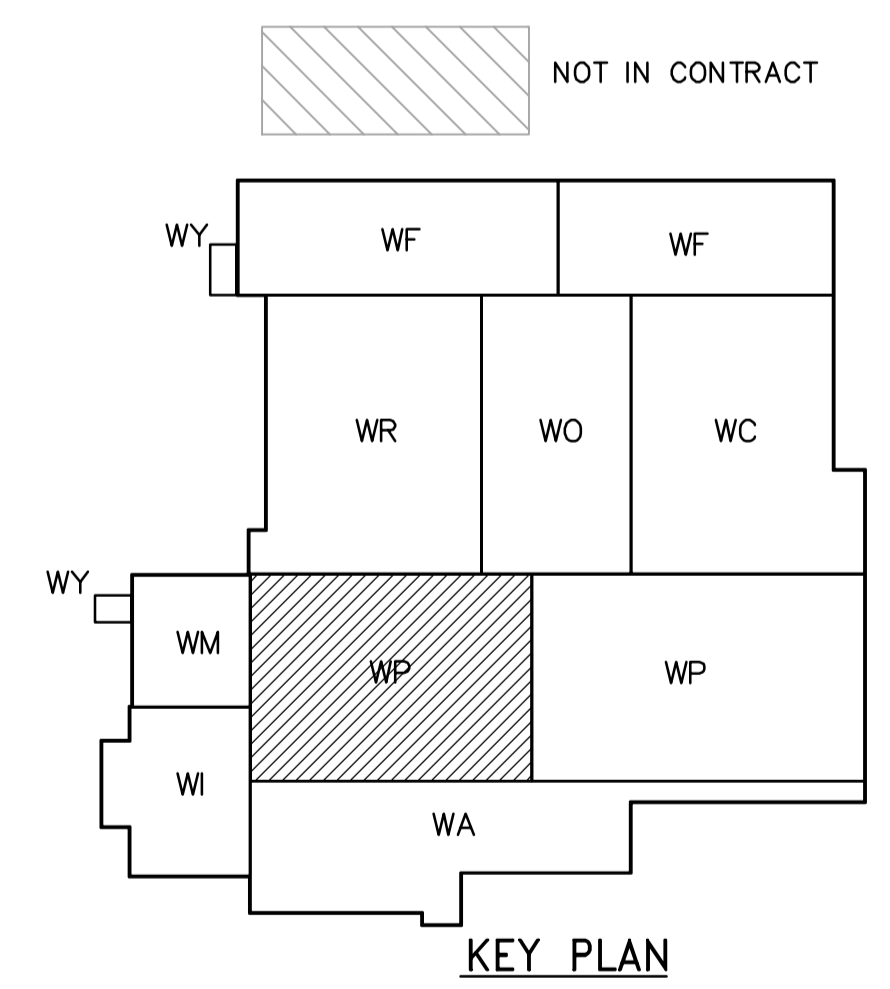

**THIRD FLOOR PLAN**  
1:100

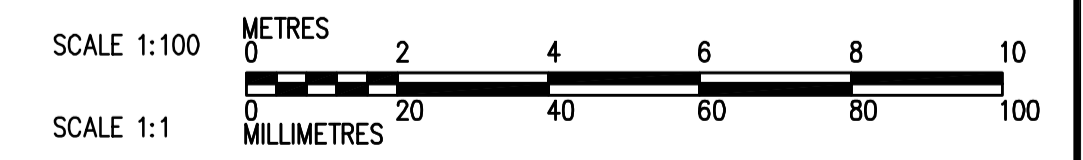

 <b>APEGN</b> Certificate of Authorization CH2M HILL Canada Ltd. No. 1441 Expiry: April 30, 2006	 Frederickson Cooper ARCHITECTS	 A Terra International Ltd. Company	B.M. ELEV.	ENGINEER'S SEAL ORIGINAL SIGNED BY D.K. CUDDINGTON 2006/02/06	 <b>THE CITY OF WINNIPEG</b> WATER AND WASTE DEPARTMENT ENGINEERING DIVISION WATER TREATMENT PLANT FLOCCULATION AND DAF FOUNDATIONS AND CONCRETE STRUCTURES PLUMBING PIPE EMBEDS FLOC/DAF AREA 1 THIRD FLOOR PLAN	CITY FILE NUMBER
			DESIGNED BY: JZ/SW CHECKED BY: DL DRAWN BY: JMcP APPROVED BY: DJT SCALE: 1:100 RELEASED FOR CONSTRUCTION BY: R. SOROKOWSKI CONSULTANT DRAWING NO. WP-H9133	NO. REVISIONS DATE BY DATE DATE 00 ISSUED FOR TENDER 2006/02/03 SW 01 2005/07/15		SHEET OF CITY DRAWING NUMBER <b>1-060P-A-H9133-001-00D</b>