




19 SECOND FLOOR PLAN - MUD VALVE DRAIN LINES
WP-M9104 1:150

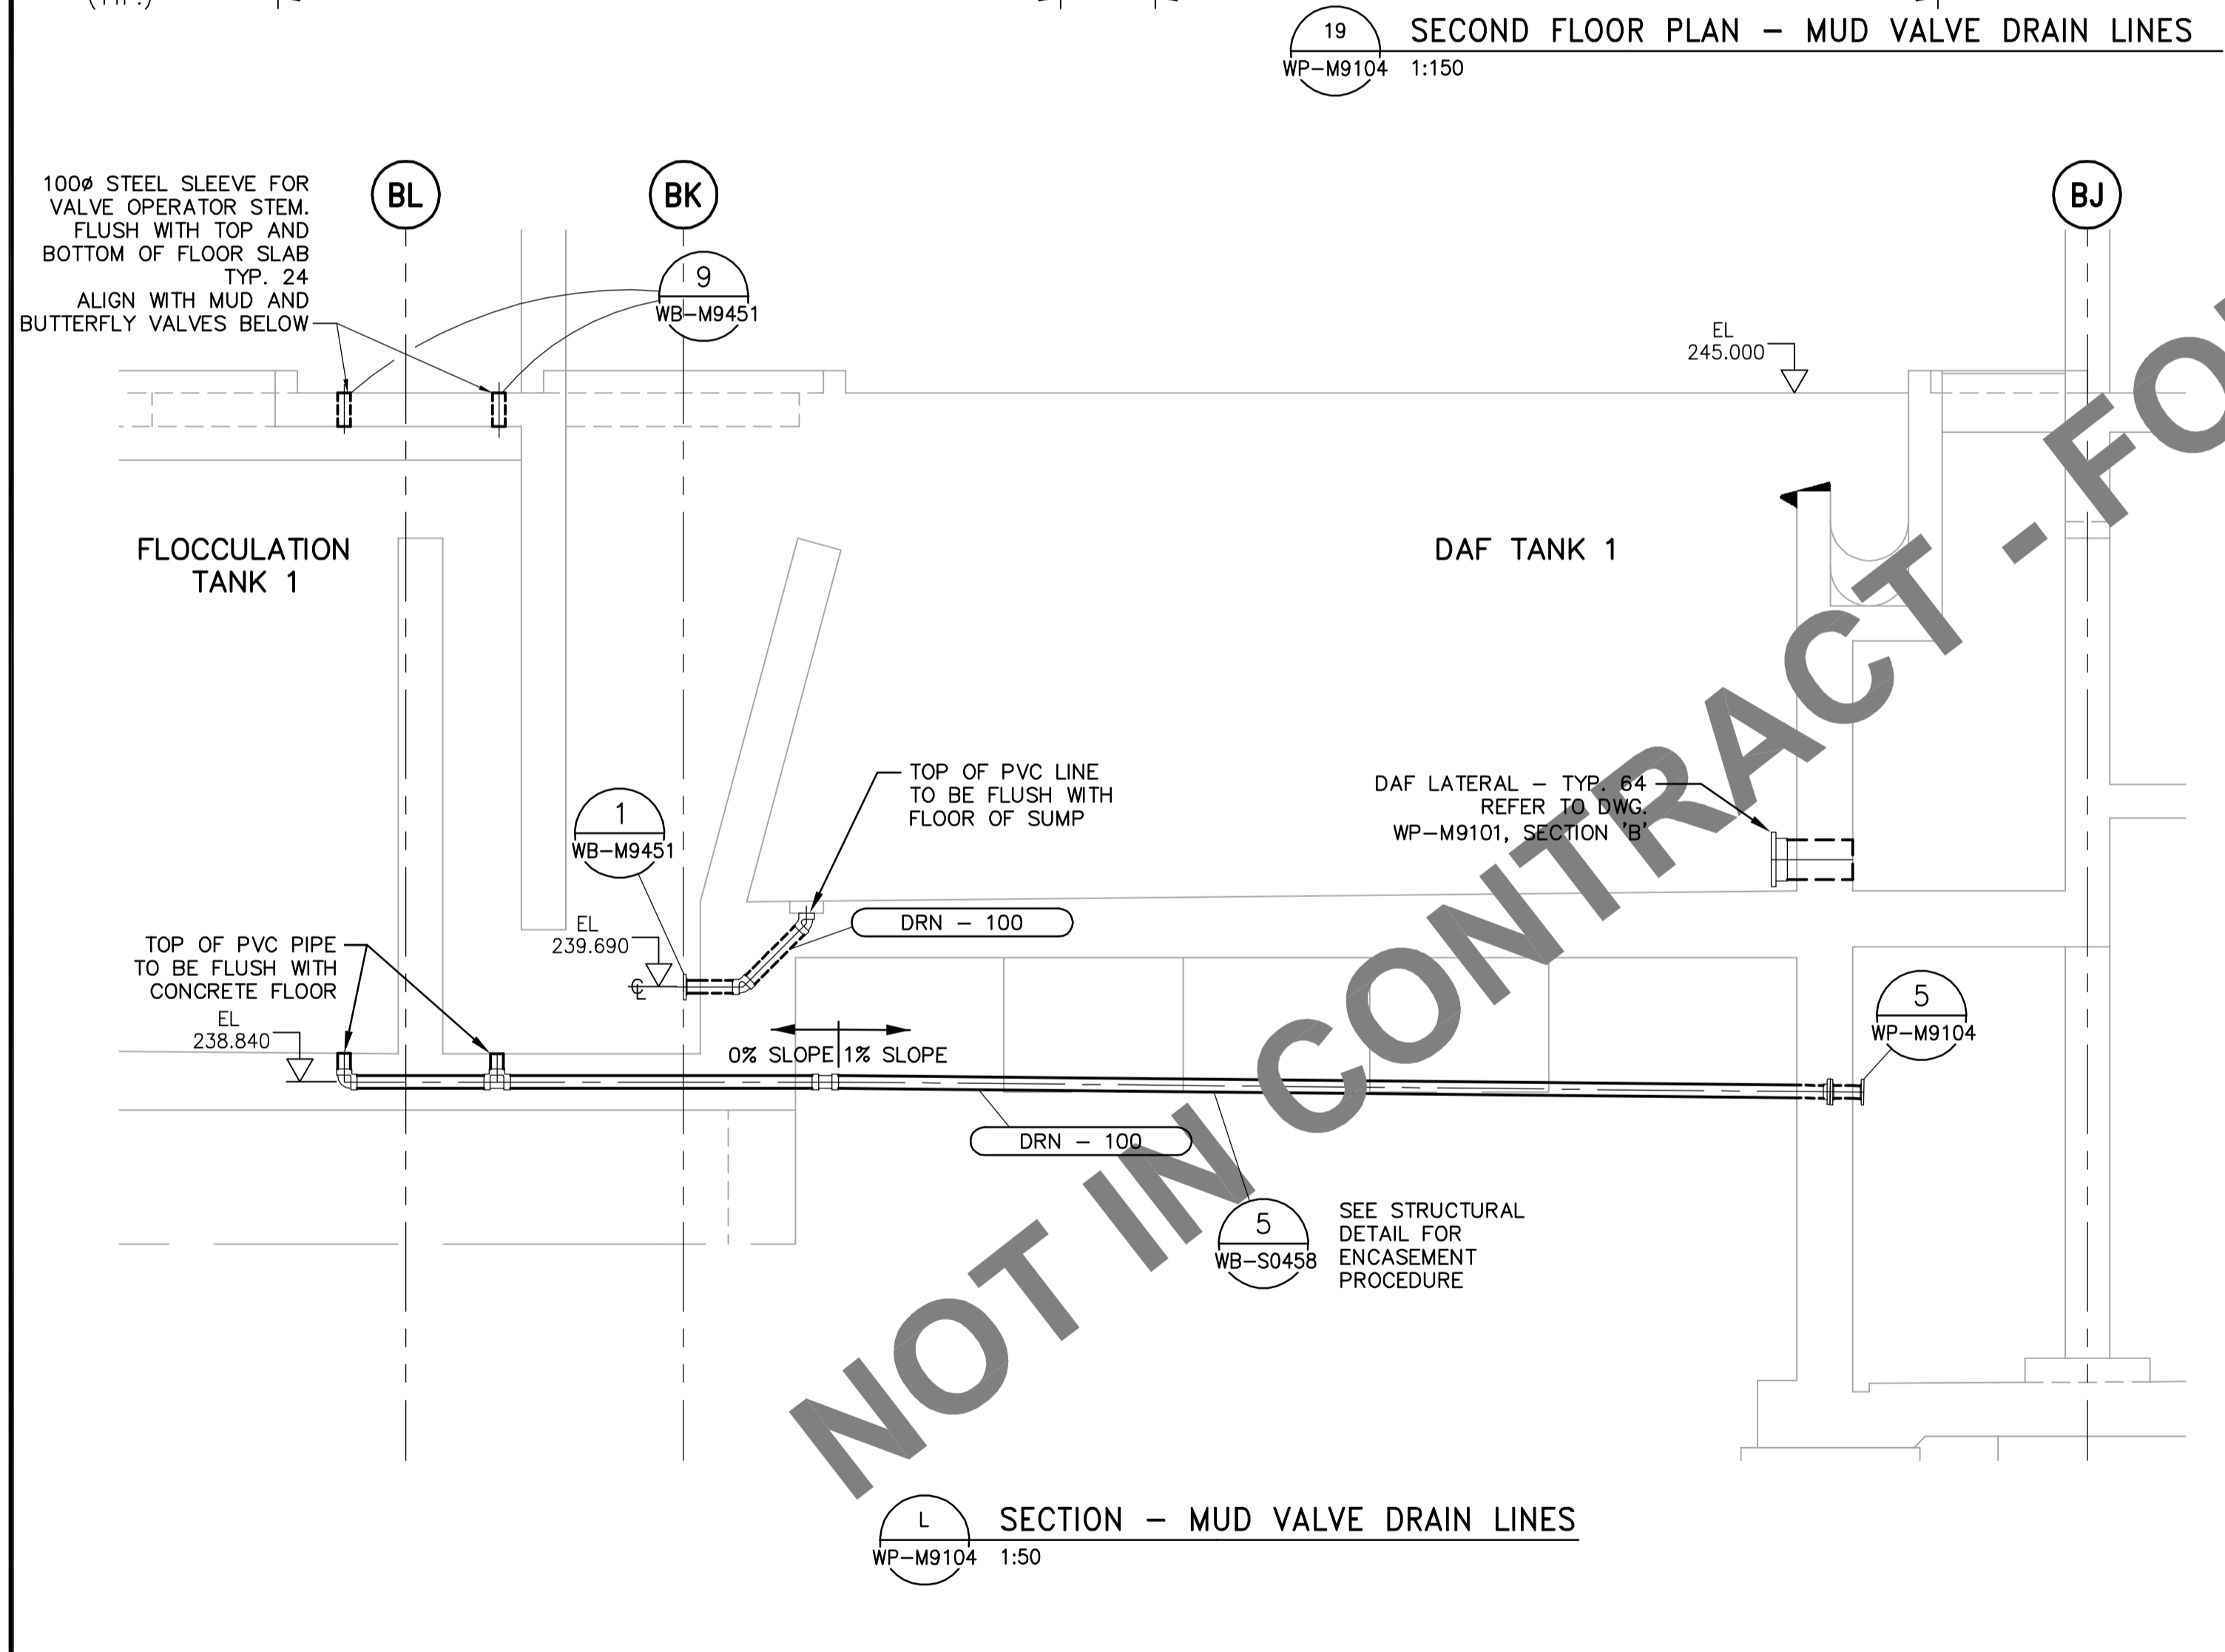


L SECTION - MUD VALVE DRAIN LINES
WP-M9104 1:50

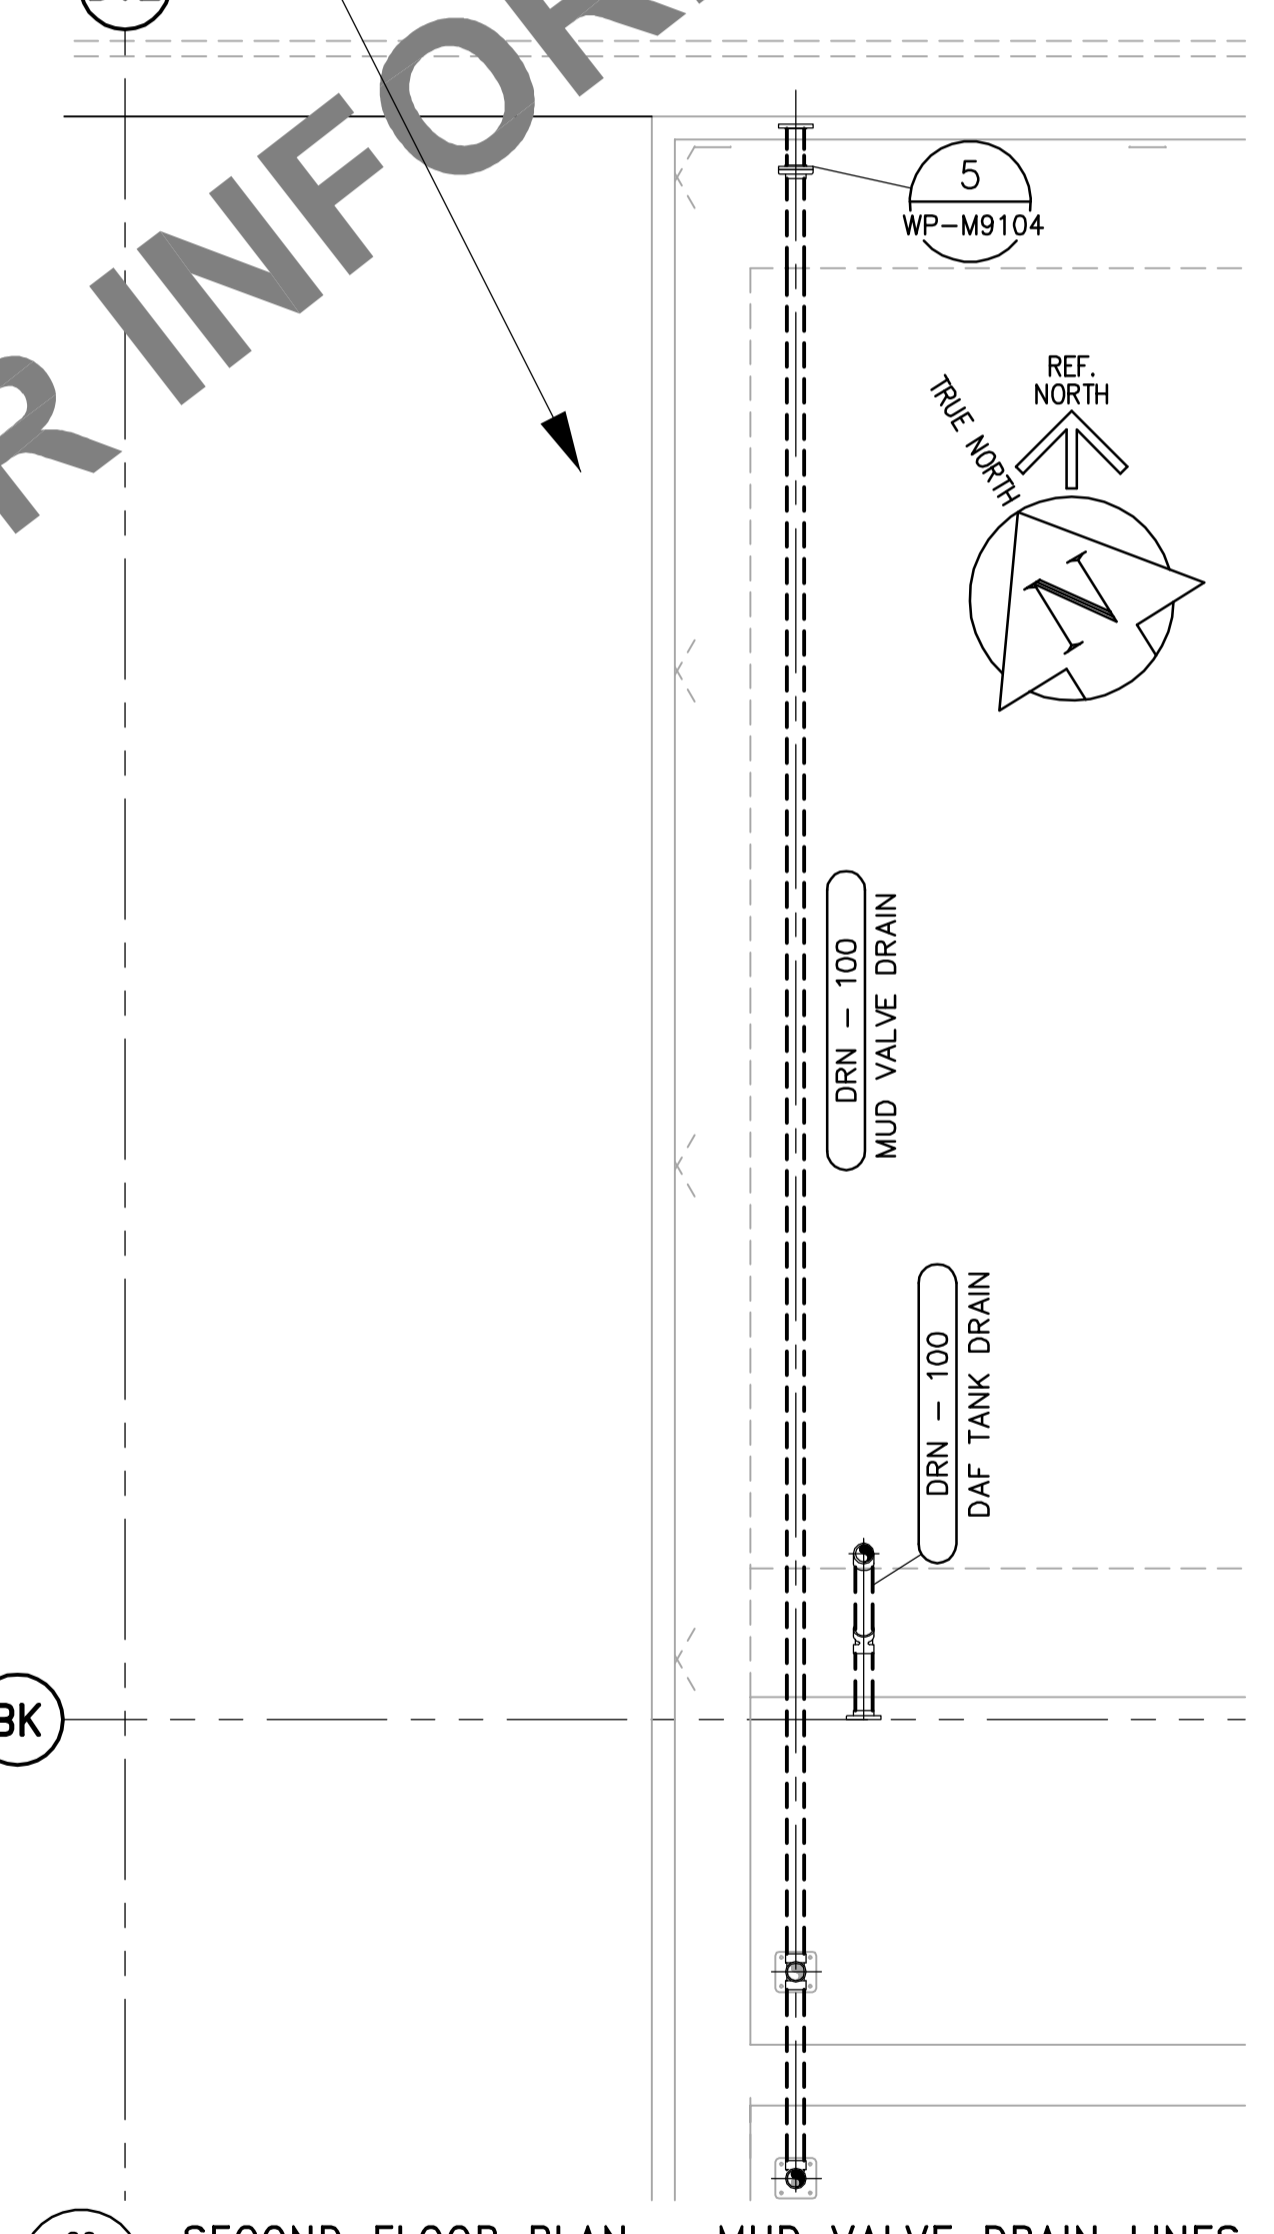

5 DETAIL - DAF DRAIN FLOOR/WALL PENETRATION
WP-M9104 NTS

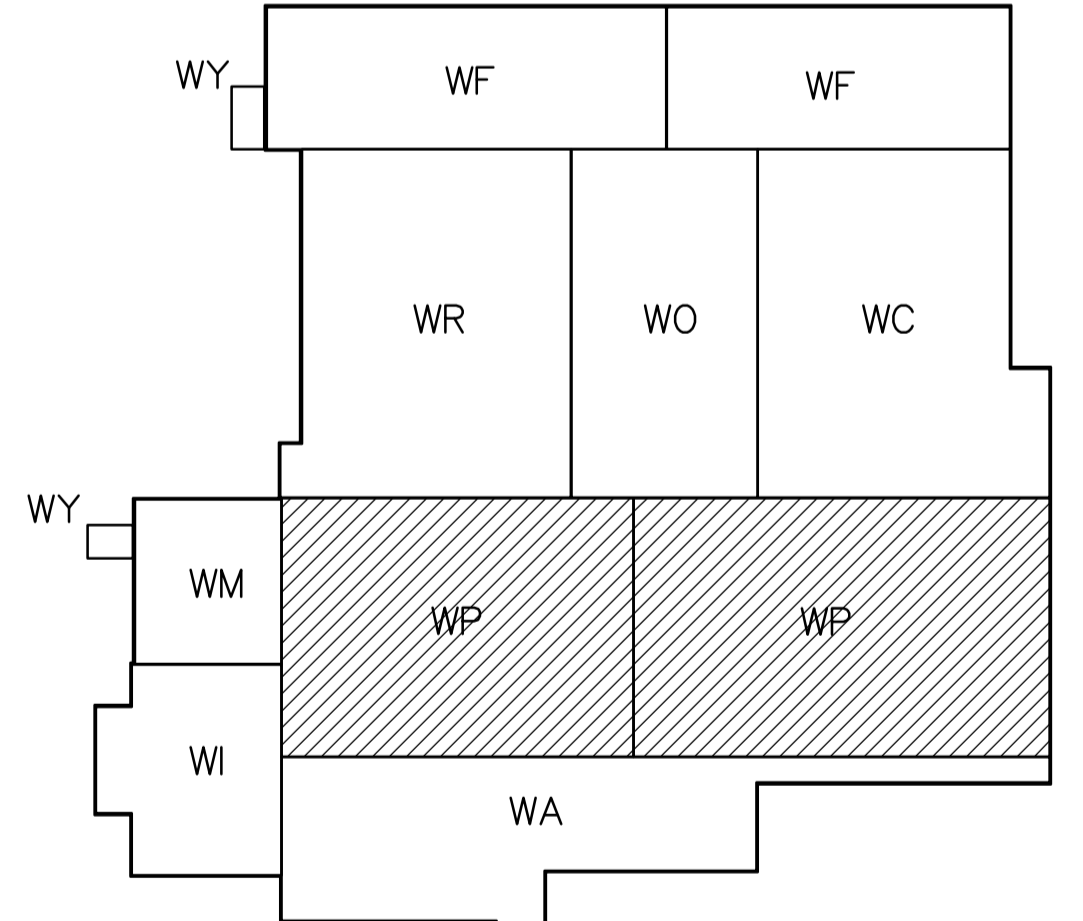

KEY PLAN

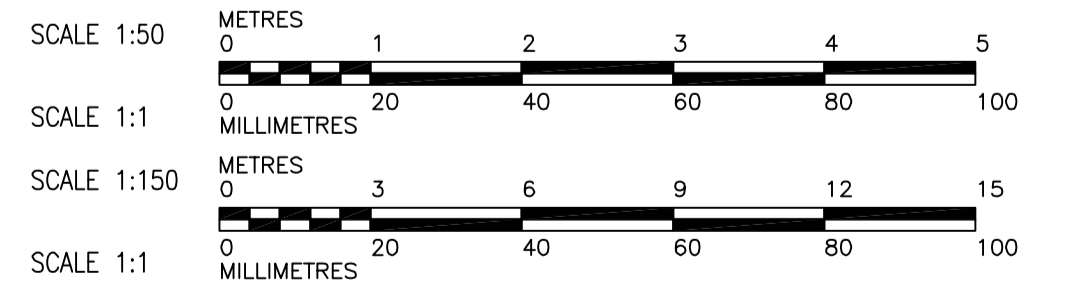

20 SECOND FLOOR PLAN - MUD VALVE DRAIN LINES
WP-M9104 1:50

 Earth Tech Canada Inc. No. 730 Expiry: April 30, 2006				B.M. ELEV.				 Frederickson Cooper ARCHITECTS								ENGINEER'S SEAL ORIGINAL SIGNED BY S.R. BILEVICIUS 2006/02/07 CONSULTANT DRAWING NO. WP-M9104				 THE CITY OF WINNIPEG WATER AND WASTE DEPARTMENT ENGINEERING DIVISION WATER TREATMENT PLANT FLOCCULATION AND DAF FOUNDATIONS AND CONCRETE STRUCTURES PIPE EMBEDS SECOND FLOOR PLAN MUD VALVE DRAIN LINES				CITY FILE NUMBER SHEET OF CITY DRAWING NUMBER 1-0601P-A-M9104-001-000			
DESIGNED BY KAS		CHECKED BY SRB		DRAWN BY PL		APPROVED BY DJT		SCALE: AS SHOWN		RELEASED FOR CONSTRUCTION BY: R. SOROKOWSKI		DATE 2005/10/24		DATE 2006/02/07		NO. REVISIONS		DATE BY		NO. REVISIONS		DATE BY					