
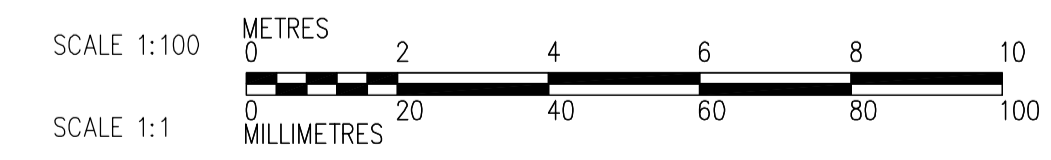


NOTES:
1. SEE PANEL SCHEDULES DP-R21 & DP-R22 FOR 600V POWER DISTRIBUTION

SECOND FLOOR PROCESS PLAN
1:100

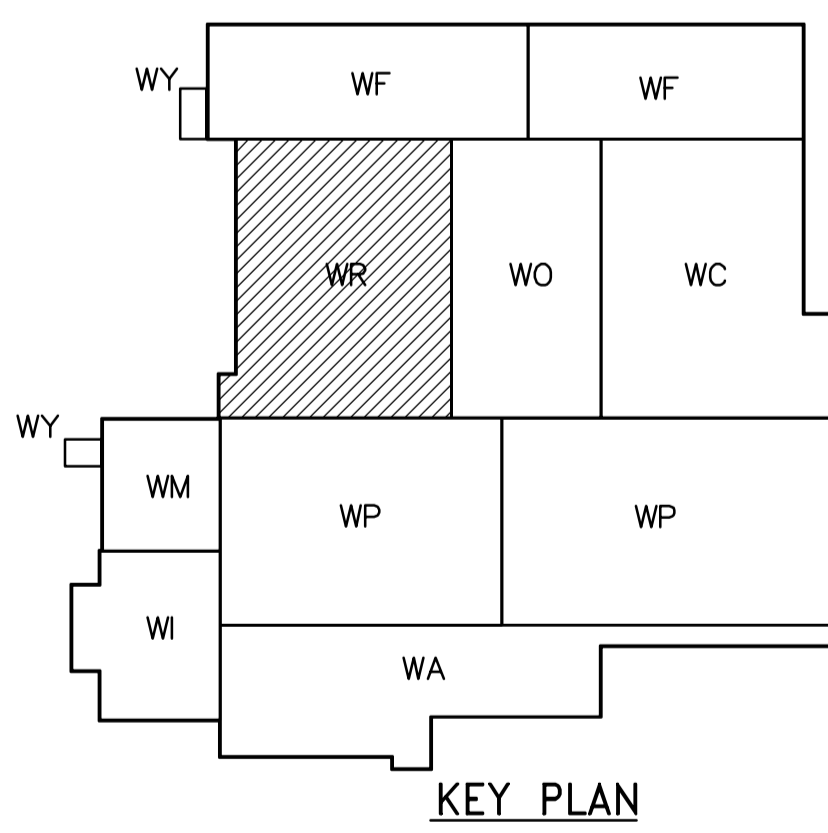

 APEGN Certificate of Authorization CH2M HILL Canada Ltd. No. 1441 Expiry: April 30, 2006	B.M. ELEV. <table border="1"> <tr><td> </td><td> </td><td> </td></tr> <tr><td> </td><td> </td><td> </td></tr> <tr><td> </td><td> </td><td> </td></tr> <tr><td> </td><td> </td><td> </td></tr> </table>													 Frederickson Cooper ARCHITECTS	 A Terra International Ltd. Company	ENGINEER'S SEAL	 THE CITY OF WINNIPEG WATER AND WASTE DEPARTMENT ENGINEERING DIVISION
DESIGNED BY LL CHECKED BY ND DRAWN BY TL APPROVED BY AHL SCALE: 1:100 RELEASED FOR CONSTRUCTION BY: R. SOROKOWSKI	ORIGINAL SIGNED BY L.D. LLEWELLYN 2006/03/29 CONSULTANT DRAWING NO. WR-E0122	WATER TREATMENT PLANT RESIDUALS HANDLING MECHANICAL AND ELECTRICAL ELECTRICAL RESIDUALS HANDLING AREA SECOND FLOOR PROCESS PLAN	CITY FILE NUMBER SHEET OF CITY DRAWING NUMBER 1-0601R-A-E0122-001-000														
00 ISSUED FOR TENDER NO. REVISIONS	06/03/29 DATE BY	2006/01/21 DATE	2006/03/29 DATE														