
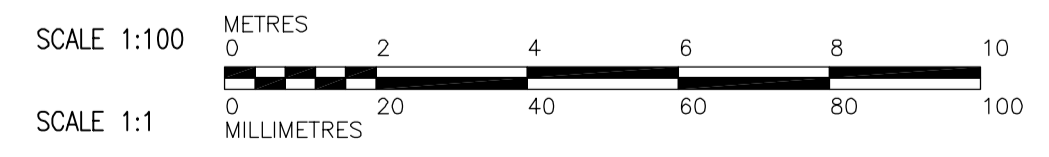


SECOND FLOOR PLAN  
1:100

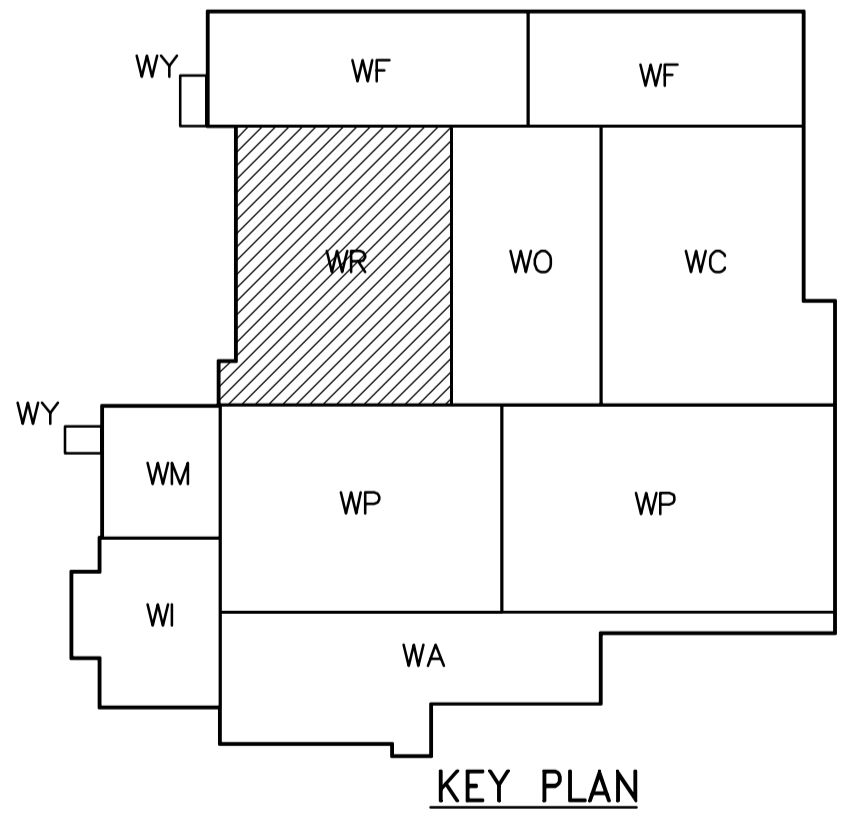

<p><b>APEGN</b> Certificate of Authorization CH2M HILL Canada Ltd. No. 1441 Expiry: April 30, 2006</p>	<p>Frederickson Cooper ARCHITECTS</p>		<p>A You International Ltd. Company</p>		ENGINEER'S SEAL ORIGINAL SIGNED BY D.K. CUDDINGTON 2006/03/29	<p><b>THE CITY OF WINNIPEG</b> WATER AND WASTE DEPARTMENT ENGINEERING DIVISION</p>
	DESIGNED BY TT CHECKED BY DL DRAWN BY AM APPROVED BY AHL		SCALE: 1:100 RELEASED FOR CONSTRUCTION BY: R. SOROKOWSKI		CITY FILE NUMBER SHEET OF	
	00 ISSUED FOR TENDER 06/03/29 TT NO. REVISIONS DATE BY		DATE 2005/07/04 DATE 2006/03/29		CITY DRAWING NUMBER 1-0601R-A-H0121-001-000	
					CONSULTANT DRAWING NO. WR-H0121	

WATER TREATMENT PLANT  
RESIDUALS HANDLING  
MECHANICAL AND ELECTRICAL

HVAC  
RESIDUALS HANDLING AREA  
SECOND FLOOR PLAN