


THIRD FLOOR PLAN  
1:100

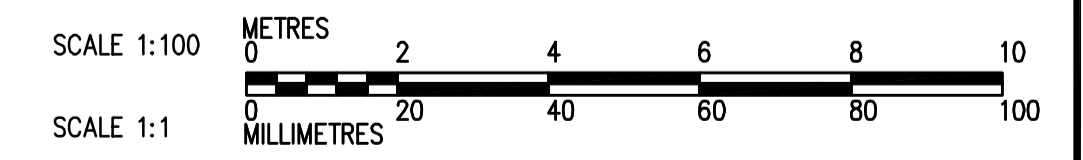

<p><b>APEGN</b> Certificate of Authorization CH2M HILL Canada Ltd. No. 1441 Expiry: April 30, 2006</p>	<p>Frederickson Cooper ARCHITECTS</p>	<p>EarthTech A Tyco International Ltd. Company</p>	ENGINEER'S SEAL	<p><b>THE CITY OF WINNIPEG</b> WATER AND WASTE DEPARTMENT ENGINEERING DIVISION</p>
			<p>DESIGNED BY JZ/SW DRAWN BY JMcP SCALE: 1:100</p>	
<p>00 ISSUED FOR TENDER 06/03/29 SW NO. REVISIONS DATE BY</p>	<p>DATE 2005/08/02</p>	<p>DATE 2006/03/29</p>	<p>CONSULTANT DRAWING NO. WR-H0132</p>	<p>CITY FILE NUMBER SHEET OF CITY DRAWING NUMBER 1-0601R-A-H0132-001-000</p>