
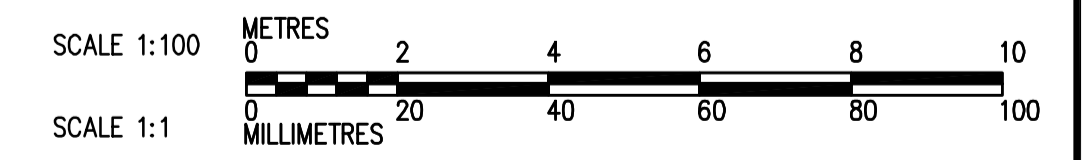


FOR THIS CONTRACT, END 75mm DRAIN PIPE AND 13mm TRAP PRIMER PIPE 300mm BELOW SLAB, TYP

NOT IN CONTRACT - FOR INFORMATION ONLY

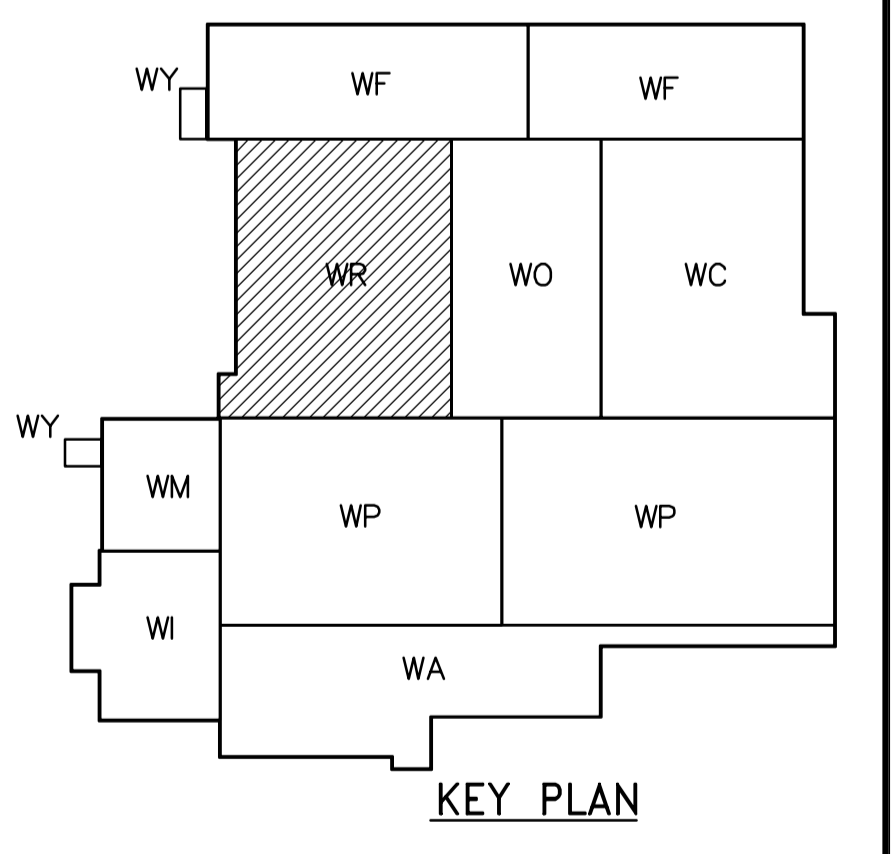

SECOND FLOOR PLAN
1:100

 APEGN Certificate of Authorization CH2M HILL Canada Ltd. No. 1441 Expiry: April 30, 2006	B.M. ELEV.	 Frederickson Cooper ARCHITECTS	 A Terra International Ltd. Company	ENGINEER'S SEAL	 THE CITY OF WINNIPEG WATER AND WASTE DEPARTMENT ENGINEERING DIVISION WATER TREATMENT PLANT RESIDUALS HANDLING FOUNDATIONS AND CONCRETE STRUCTURES PLUMBING PIPE EMBEDS RESIDUALS AREA SECOND LEVEL PLAN
	DESIGNED BY JZ/SW	CHECKED BY DL	ORIGINAL SIGNED BY D.K. CUDDINGTON	CITY FILE NUMBER	
	DRAWN BY JmCP	APPROVED BY DJT	2006/02/06	SHEET OF	
SCALE: 1:100	RELEASED FOR CONSTRUCTION BY: R. SOROKOWSKI	CONSULTANT DRAWING NO. WR-H9122	CITY DRAWING NUMBER 1-060R-A-H9122-001-00D		
00 ISSUED FOR TENDER 2006/02/03 SW	DATE 2005/08/02	DATE 2006/02/08			