

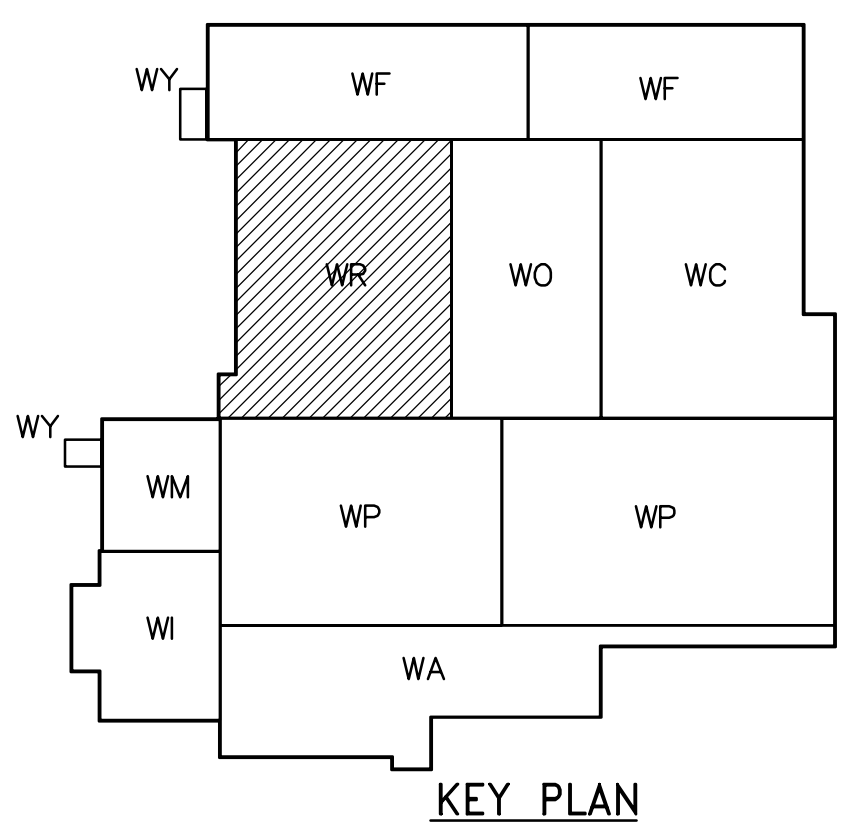


1 DETAIL  
1:50

THIRD FLOOR PLAN  
1:100

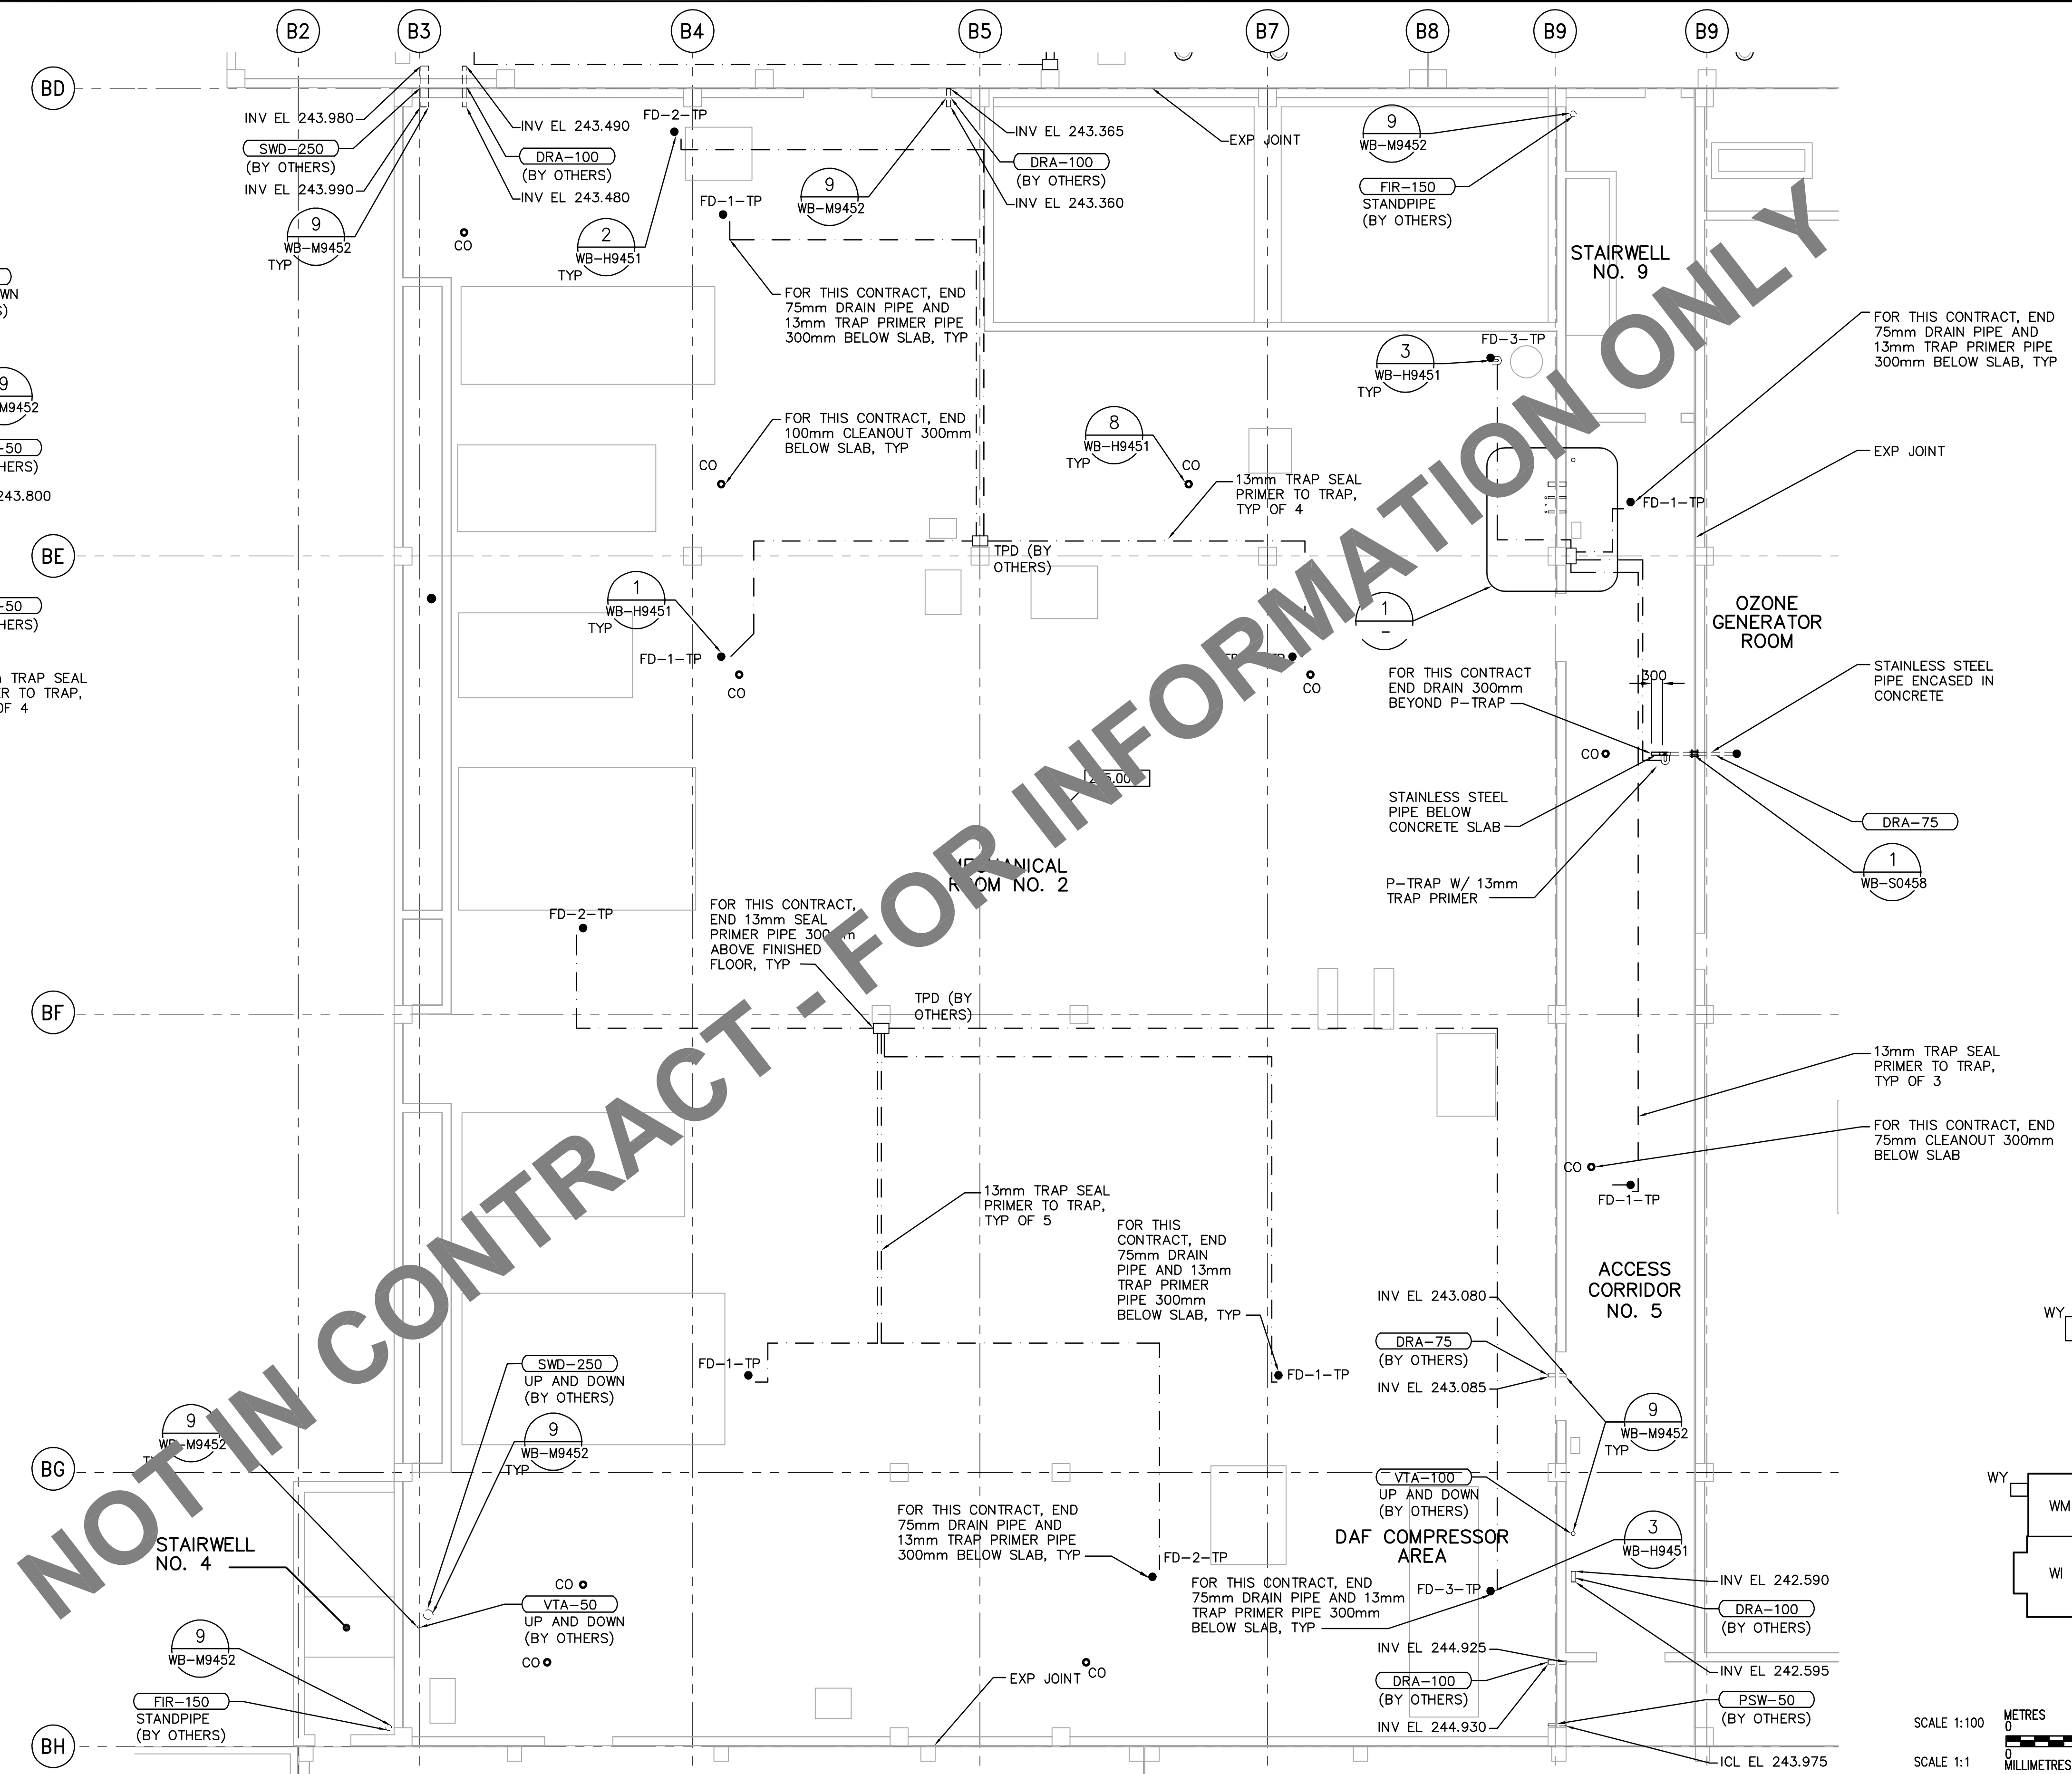

KEY PLAN

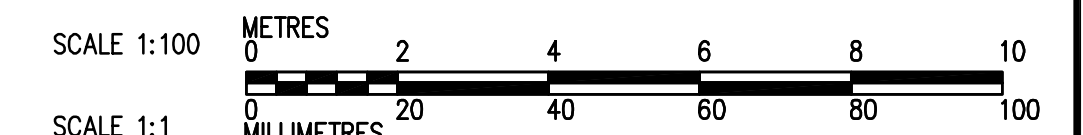

NOT IN CONTRACT - FOR INFORMATION ONLY

 <b>APECA</b> Certificate of Authorization CH2M HILL Canada Ltd. No. 1441 Expiry: April 30, 2006	B.M. ELEV. <table border="1" style="width: 100%; height: 40px;"> <tr><td> </td><td> </td><td> </td></tr> </table>				 Frederickson Cooper ARCHITECTS	 A Tyco International Ltd. Company	ENGINEER'S SEAL ORIGINAL SIGNED BY D.K. CUDDINGTON 2006/02/06 CONSULTANT DRAWING NO. WR-H9132	<b>THE CITY OF WINNIPEG</b> WATER AND WASTE DEPARTMENT ENGINEERING DIVISION WATER TREATMENT PLANT RESIDUALS HANDLING FOUNDATIONS AND CONCRETE STRUCTURES PLUMBING PIPE EMBEDS RESIDUALS AREA THIRD FLOOR PLAN	CITY FILE NUMBER SHEET OF CITY DRAWING NUMBER <b>1-060R-A-H9132-001-00D</b>
DESIGNED BY: JZ/SW DRAWN BY: JMcP SCALE: 1:100	CHECKED BY: DL APPROVED BY: DJT RELEASED FOR CONSTRUCTION BY: R. SOROKOWSKI DATE: 2006/02/08	ISSUED FOR TENDER: 2006/02/03 SW NO. REVISIONS:                      DATE BY:	DATE: 2005/08/02 DATE: 2006/02/08	00 01 02 50	1:100 METRES 1:1 MILLIMETRES	1:100 METRES 1:1 MILLIMETRES			