



PLAN AT ELEVATION 239.000
WR-M0111 1:50

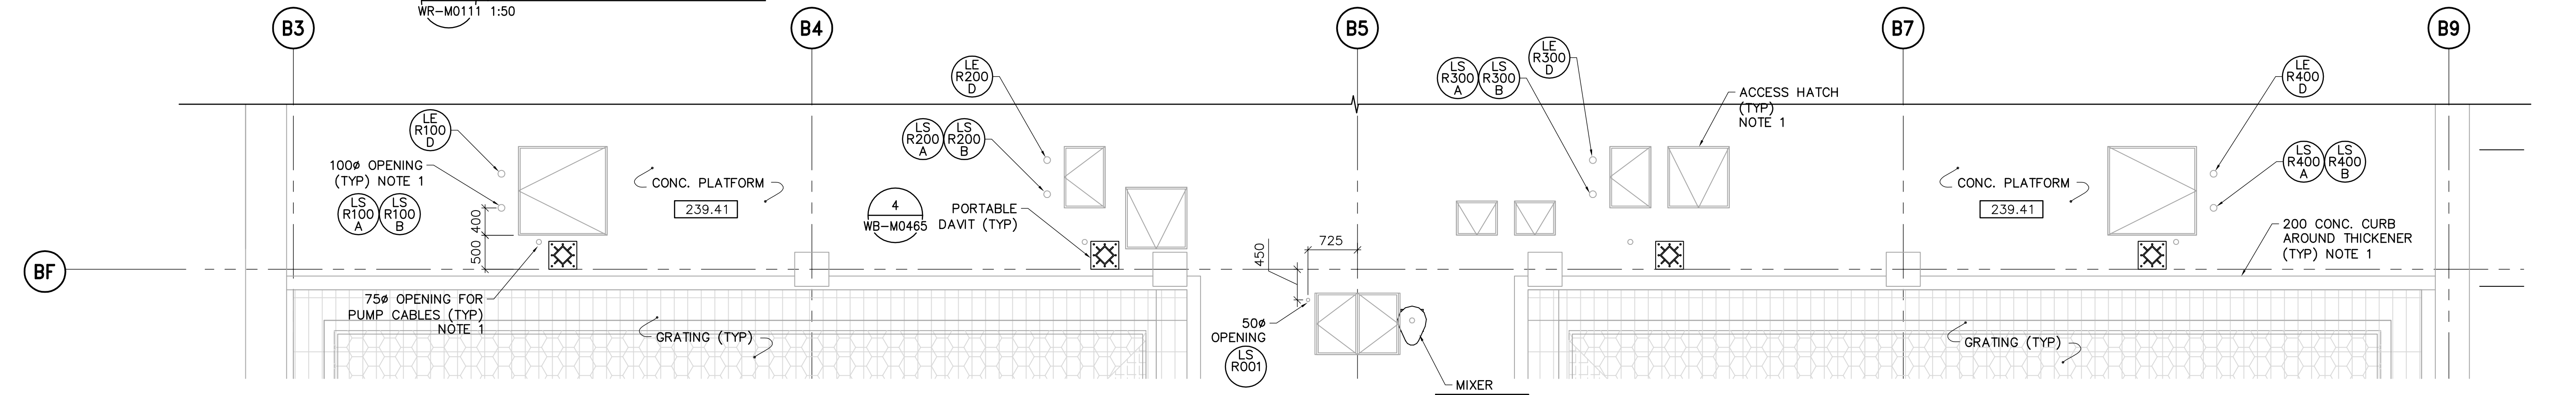

PLAN AT ELEVATION 239.410
WR-M0121 1:50

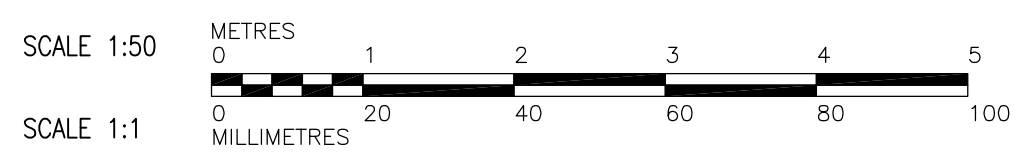

- NOTES:
1. TO BE SUPPLIED AND INSTALLED UNDER BID OPPORTUNITY No. 583-2005.
 2. FOR ADDITIONAL INFORMATION ON PIPE EMBEDS REFER TO SERIES WR-M9000 DRAWINGS.

<p>APEGM Certificate of Authorization Earth Tech Canada Inc. No. 730 Expiry: April 30, 2006</p>	B.M. ELEV.	<p>Frederickson Cooper ARCHITECTS</p>	<p>EarthTech A Tyco International Ltd. Company</p>	ENGINEER'S SEAL	<p>THE CITY OF WINNIPEG WATER AND WASTE DEPARTMENT ENGINEERING DIVISION</p>		
				DESIGNED BY: SM		CHECKED BY: SRB	ORIGINAL SIGNED BY: S.R. BILEVICIUS
				DRAWN BY: JBC		APPROVED BY: AHL	2006/03/29
				SCALE: 1:50		RELEASED FOR CONSTRUCTION BY: R. SOROKOWSKI	CONSULTANT DRAWING NO. WR-M0113
	NO. REVISIONS	DATE	BY	DATE	<p>WATER TREATMENT PLANT RESIDUALS HANDLING MECHANICAL AND ELECTRICAL</p> <p>PROCESS MECHANICAL WASHWATER RECOVERY TANKS PROCESS PIPING PLAN</p>		
	00	ISSUED FOR TENDER	06/03/29	JBC	<p>CITY FILE NUMBER</p> <p>SHEET OF</p> <p>CITY DRAWING NUMBER</p> <p>1-0601R-A-M0113-001-000</p>		
				2005/09/29			
				2006/03/29			