


NOTE:  
1. FOR ADDITIONAL INFORMATION ON PIPE EMBEDS REFER TO SERIES WR-M9000 DRAWINGS.

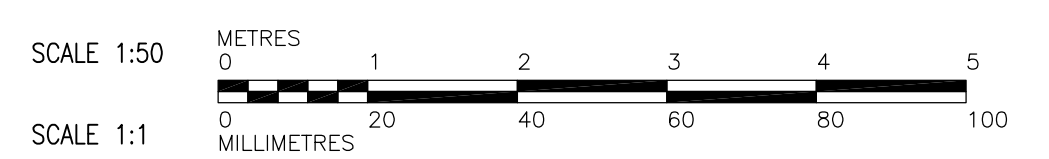

<p><b>APEGA</b> Certificate of Authorization Earth Tech Canada Inc. No. 730 Expiry: April 30, 2006</p>	<p>B.M. ELEV.</p>	<p>Frederickson Cooper ARCHITECTS</p>	<p>EarthTech A Tyco International Ltd. Company</p>	<p>ENGINEER'S SEAL</p>	<p><b>THE CITY OF WINNIPEG</b> WATER AND WASTE DEPARTMENT ENGINEERING DIVISION</p>
	<p>DESIGNED BY: SM</p> <p>DRAWN BY: JBC</p> <p>SCALE: 1:50</p>			<p>CHECKED BY: SRB</p> <p>APPROVED BY: AHL</p> <p>RELEASED FOR CONSTRUCTION BY: R. SOROKOWSKI</p>	
<p>00 ISSUED FOR TENDER 06/03/29 JBC</p> <p>NO. REVISIONS DATE BY</p>	<p>DATE 2005/09/29</p>	<p>DATE 2006/03/29</p>	<p>DATE 2006/03/29</p>	<p>PROCESS MECHANICAL SECOND FLOOR PLAN GRAVITY THICKENERS</p>	<p>CITY DRAWING NUMBER 1-0601R-A-M0122-001-000</p>