


PLAN AT ELEVATION 239.410  
WR-M0121 1:25

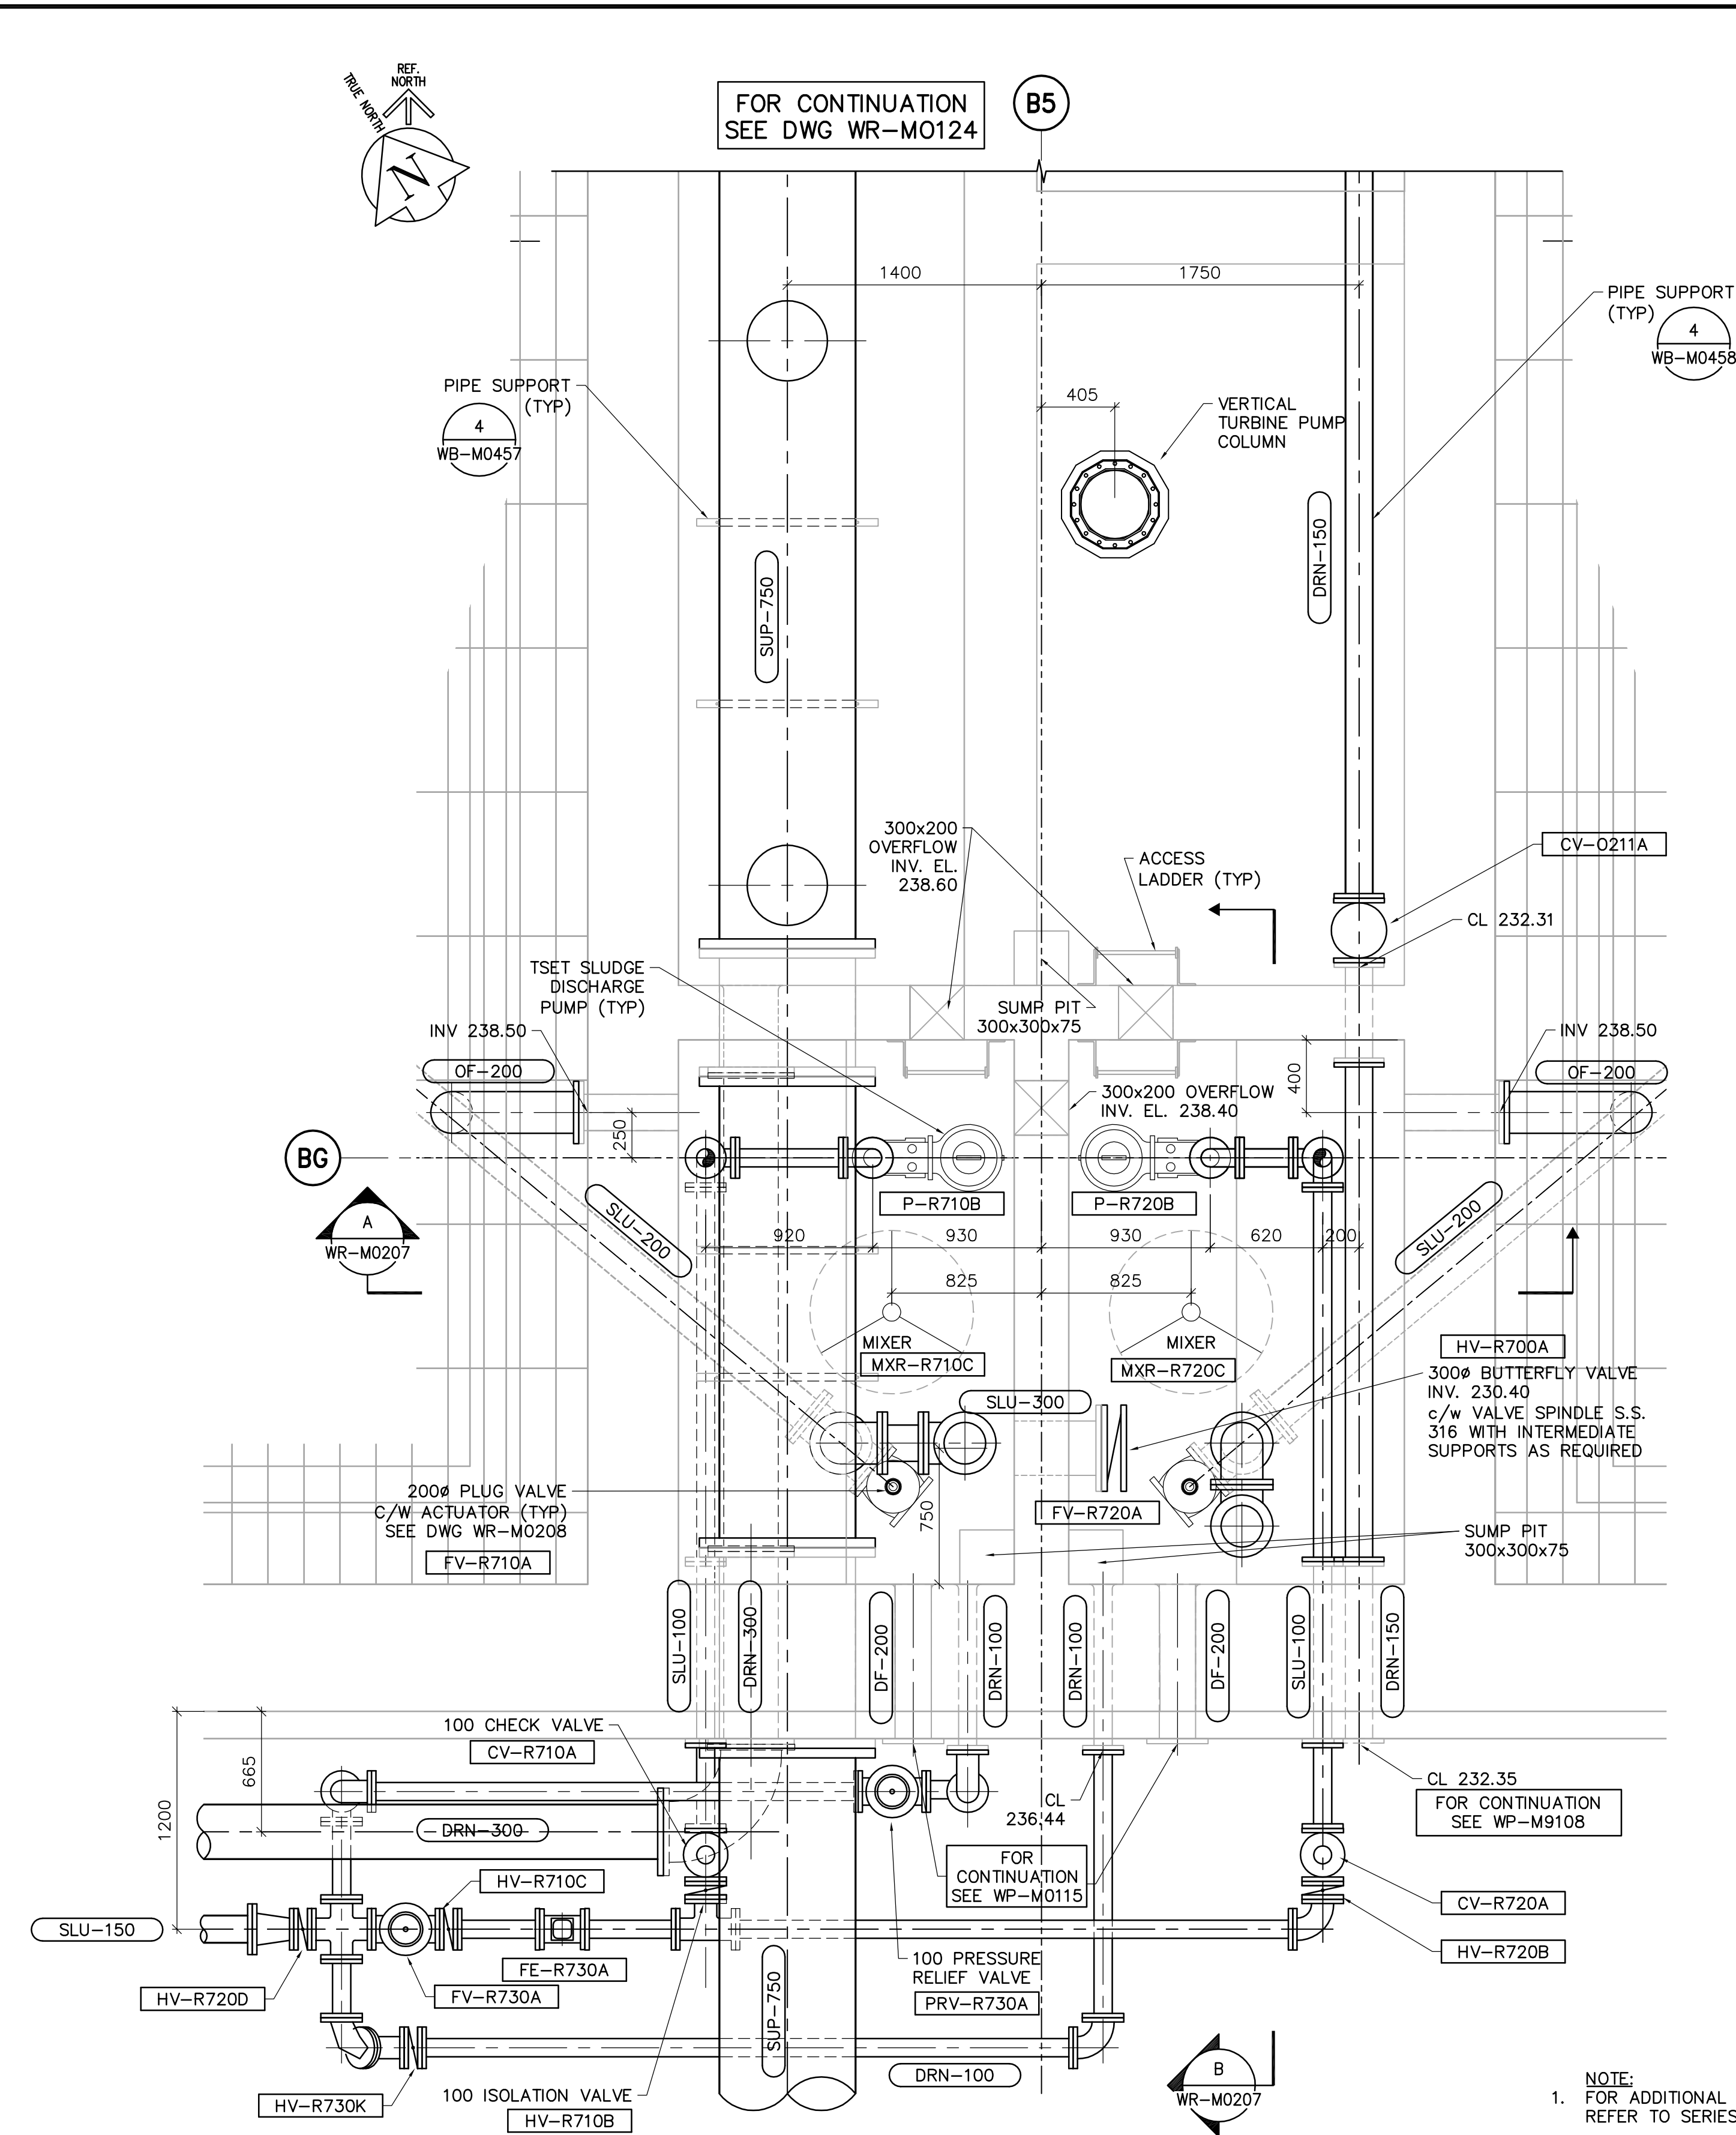

PLAN AT ELEVATION 239.000  
WR-M0111 1:25

NOTE:  
1. FOR ADDITIONAL INFORMATION ON PIPE EMBEDS REFER TO SERIES WR-M9000 DRAWINGS.

SCALE 1:25 METRES  
SCALE 1:1 MILLIMETRES

<p>Certificate of Authorization Earth Tech Canada Inc. No. 730 Expiry: April 30, 2006</p>	B.M. ELEV.	<p>Frederickson Cooper ARCHITECTS</p>	<p>A Tech International Ltd. Company</p>	ENGINEER'S SEAL	<p>THE CITY OF WINNIPEG WATER AND WASTE DEPARTMENT ENGINEERING DIVISION</p>	
	DESIGNED BY SM			CHECKED BY SRB		ORIGINAL SIGNED BY S.R. BILEVICIUS
	DRAWN BY JBC			APPROVED BY AHL		2006/03/29
	SCALE: 1:25			RELEASED FOR CONSTRUCTION BY: R. SOROKOWSKI		CONSULTANT DRAWING NO. WR-M0123
00 ISSUED FOR TENDER 06/03/29 JBC	NO. REVISIONS	DATE BY DATE 2005/09/29	DATE 2006/03/29	PROCESS MECHANICAL SECOND FLOOR PLAN THICKENED SLUDGE EQUALIZATION TANKS	CITY FILE NUMBER SHEET OF CITY DRAWING NUMBER 1-0601R-A-M0123-001-000	