


NOTE: REFER TO STRUCTURAL DRAWINGS FOR HATCH LOCATIONS

ROOF PLAN - BIOREACTOR 2
SCALE : 1:100

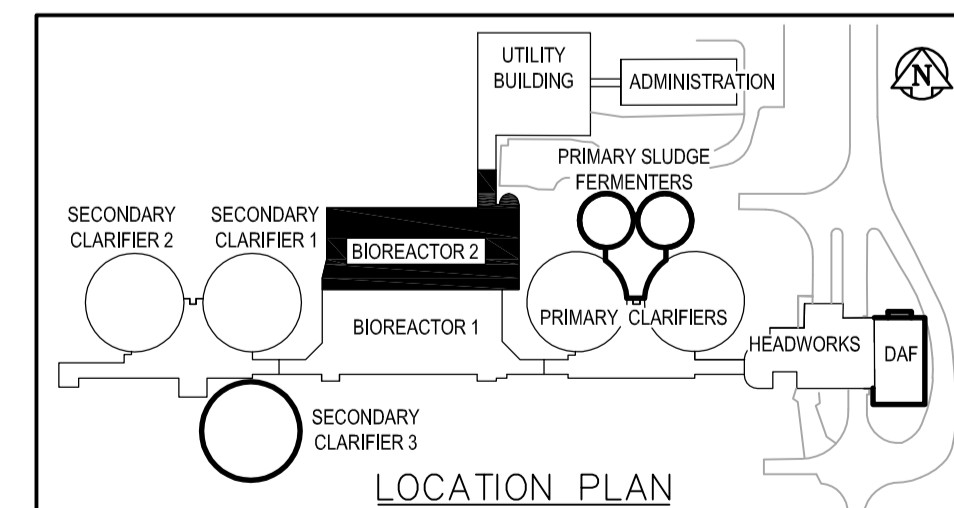

B.M. ELEV.		EarthTech A Tyco International Ltd. Company		ENGINEER'S SEAL	
DESIGNED BY	LK	CHECKED BY	NC	ORIGINAL SIGNED BY	N. COOPER
DRAWN BY	LK	APPROVED BY	JEH	DATE	2006/05/26
HOR. SCALE: AS NOTED		RELEASED FOR CONSTRUCTION BY:		CONSULTANT DRAWING NO.	
VERTICAL SCALE:		J. VEILLEUX		SA5.03	
NO. REVISIONS	DATE	BY	DATE	DATE	DATE
00	21-2006 ADDENDUM 3	06/05/25	LK	2006/05/19	2006/05/26

THE CITY OF WINNIPEG
WATER AND WASTE DEPARTMENT
ENGINEERING DIVISION

WEWPC
BIOLOGICAL NUTRIENT REMOVAL UPGRADE
CONTRACT No. 3

ARCHITECTURAL
AREA S - BIOREACTOR 2
ROOF GUARDRAIL PLAN

CITY FILE NUMBER
SHEET OF
CITY DRAWING NUMBER