


1 PLAN @ STAIR
FA1.01 1:50

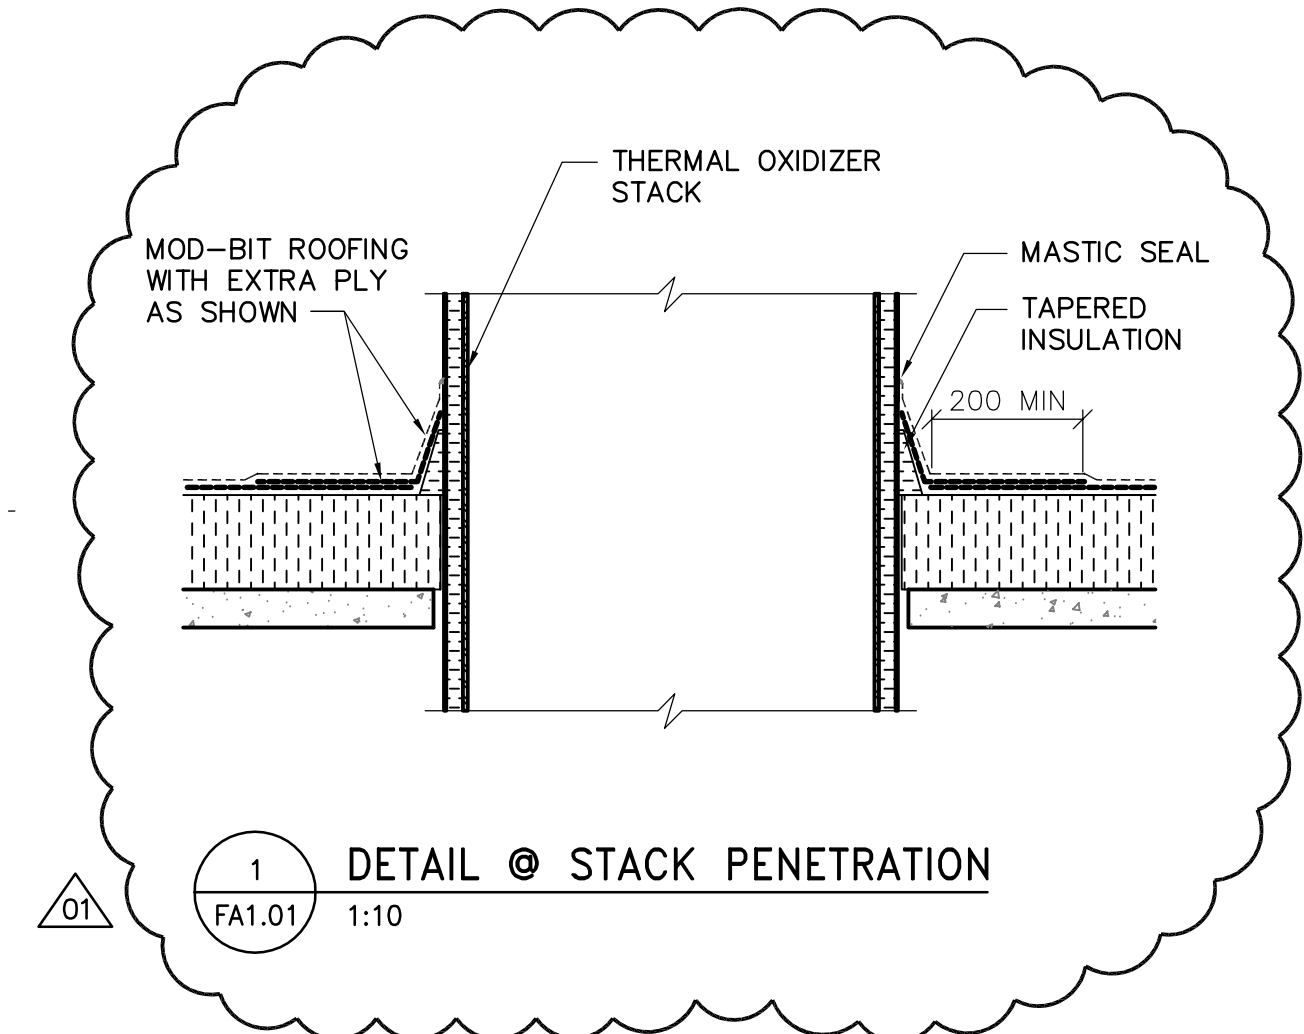

1 DETAIL @ STACK PENETRATION
FA1.01 1:10

1 ROOF PLAN
FA1.01 1:100



B.M. ELEV.		 A Tyco International Ltd. Company		ENGINEER'S SEAL		 THE CITY OF WINNIPEG WATER AND WASTE DEPARTMENT ENGINEERING DIVISION	
				ORIGINAL SIGNED BY N. COOPER 2006/04/26			
DESIGNED BY	NC	CHECKED BY	NC	CONSULTANT DRAWING NO. FA1.01		WEWPC BIOLOGICAL NUTRIENT REMOVAL UPGRADE CONTRACT No. 3	
DRAWN BY	LK/AL	APPROVED BY	JEH				
HOR. SCALE: AS NOTED		RELEASED FOR CONSTRUCTION BY:		CITY FILE NUMBER		SHEET 1 OF 6	
VERTICAL SCALE: AS NOTED		J. VEILLEUX					
NO. REVISIONS	DATE	BY	DATE	2006/01/03	2006/04/26	CITY DRAWING NUMBER	