




**PUMP ROOM UNDER MEZZANINE - LIGHTING PLAN**  
SCALE: 1:100

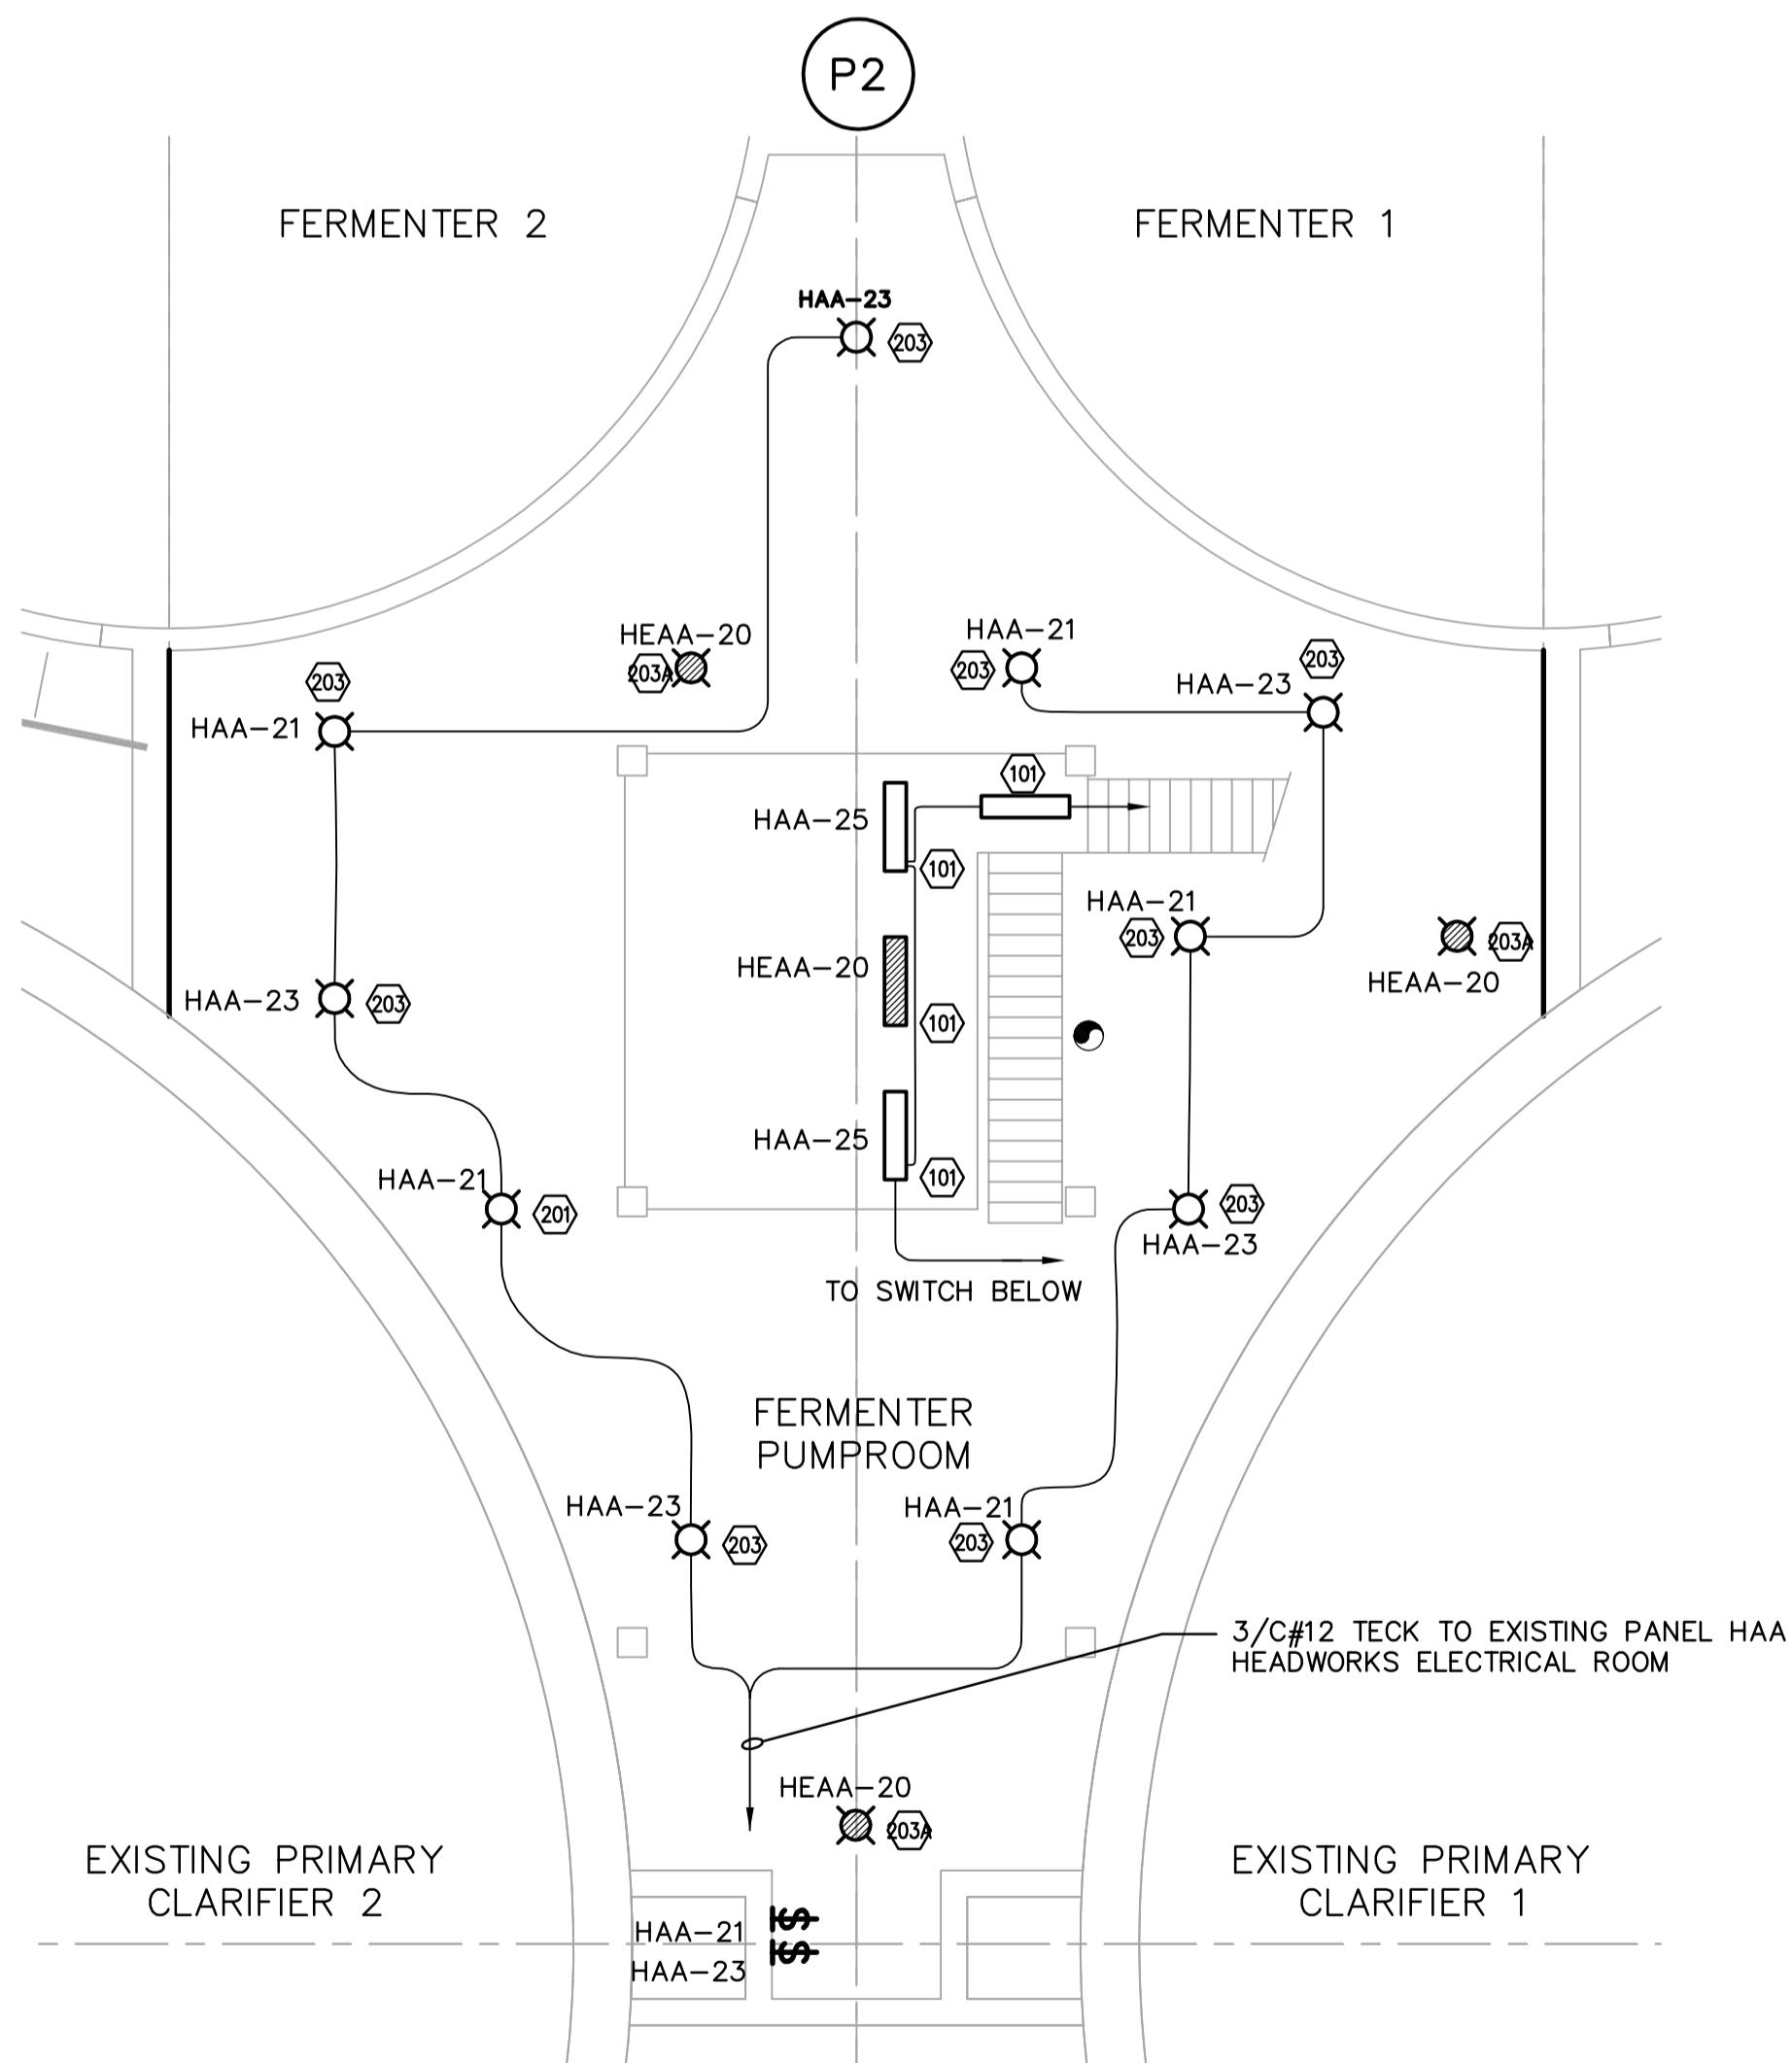

**FERMENTER PUMP ROOM - LIGHTING PLAN**  
SCALE: 1:100

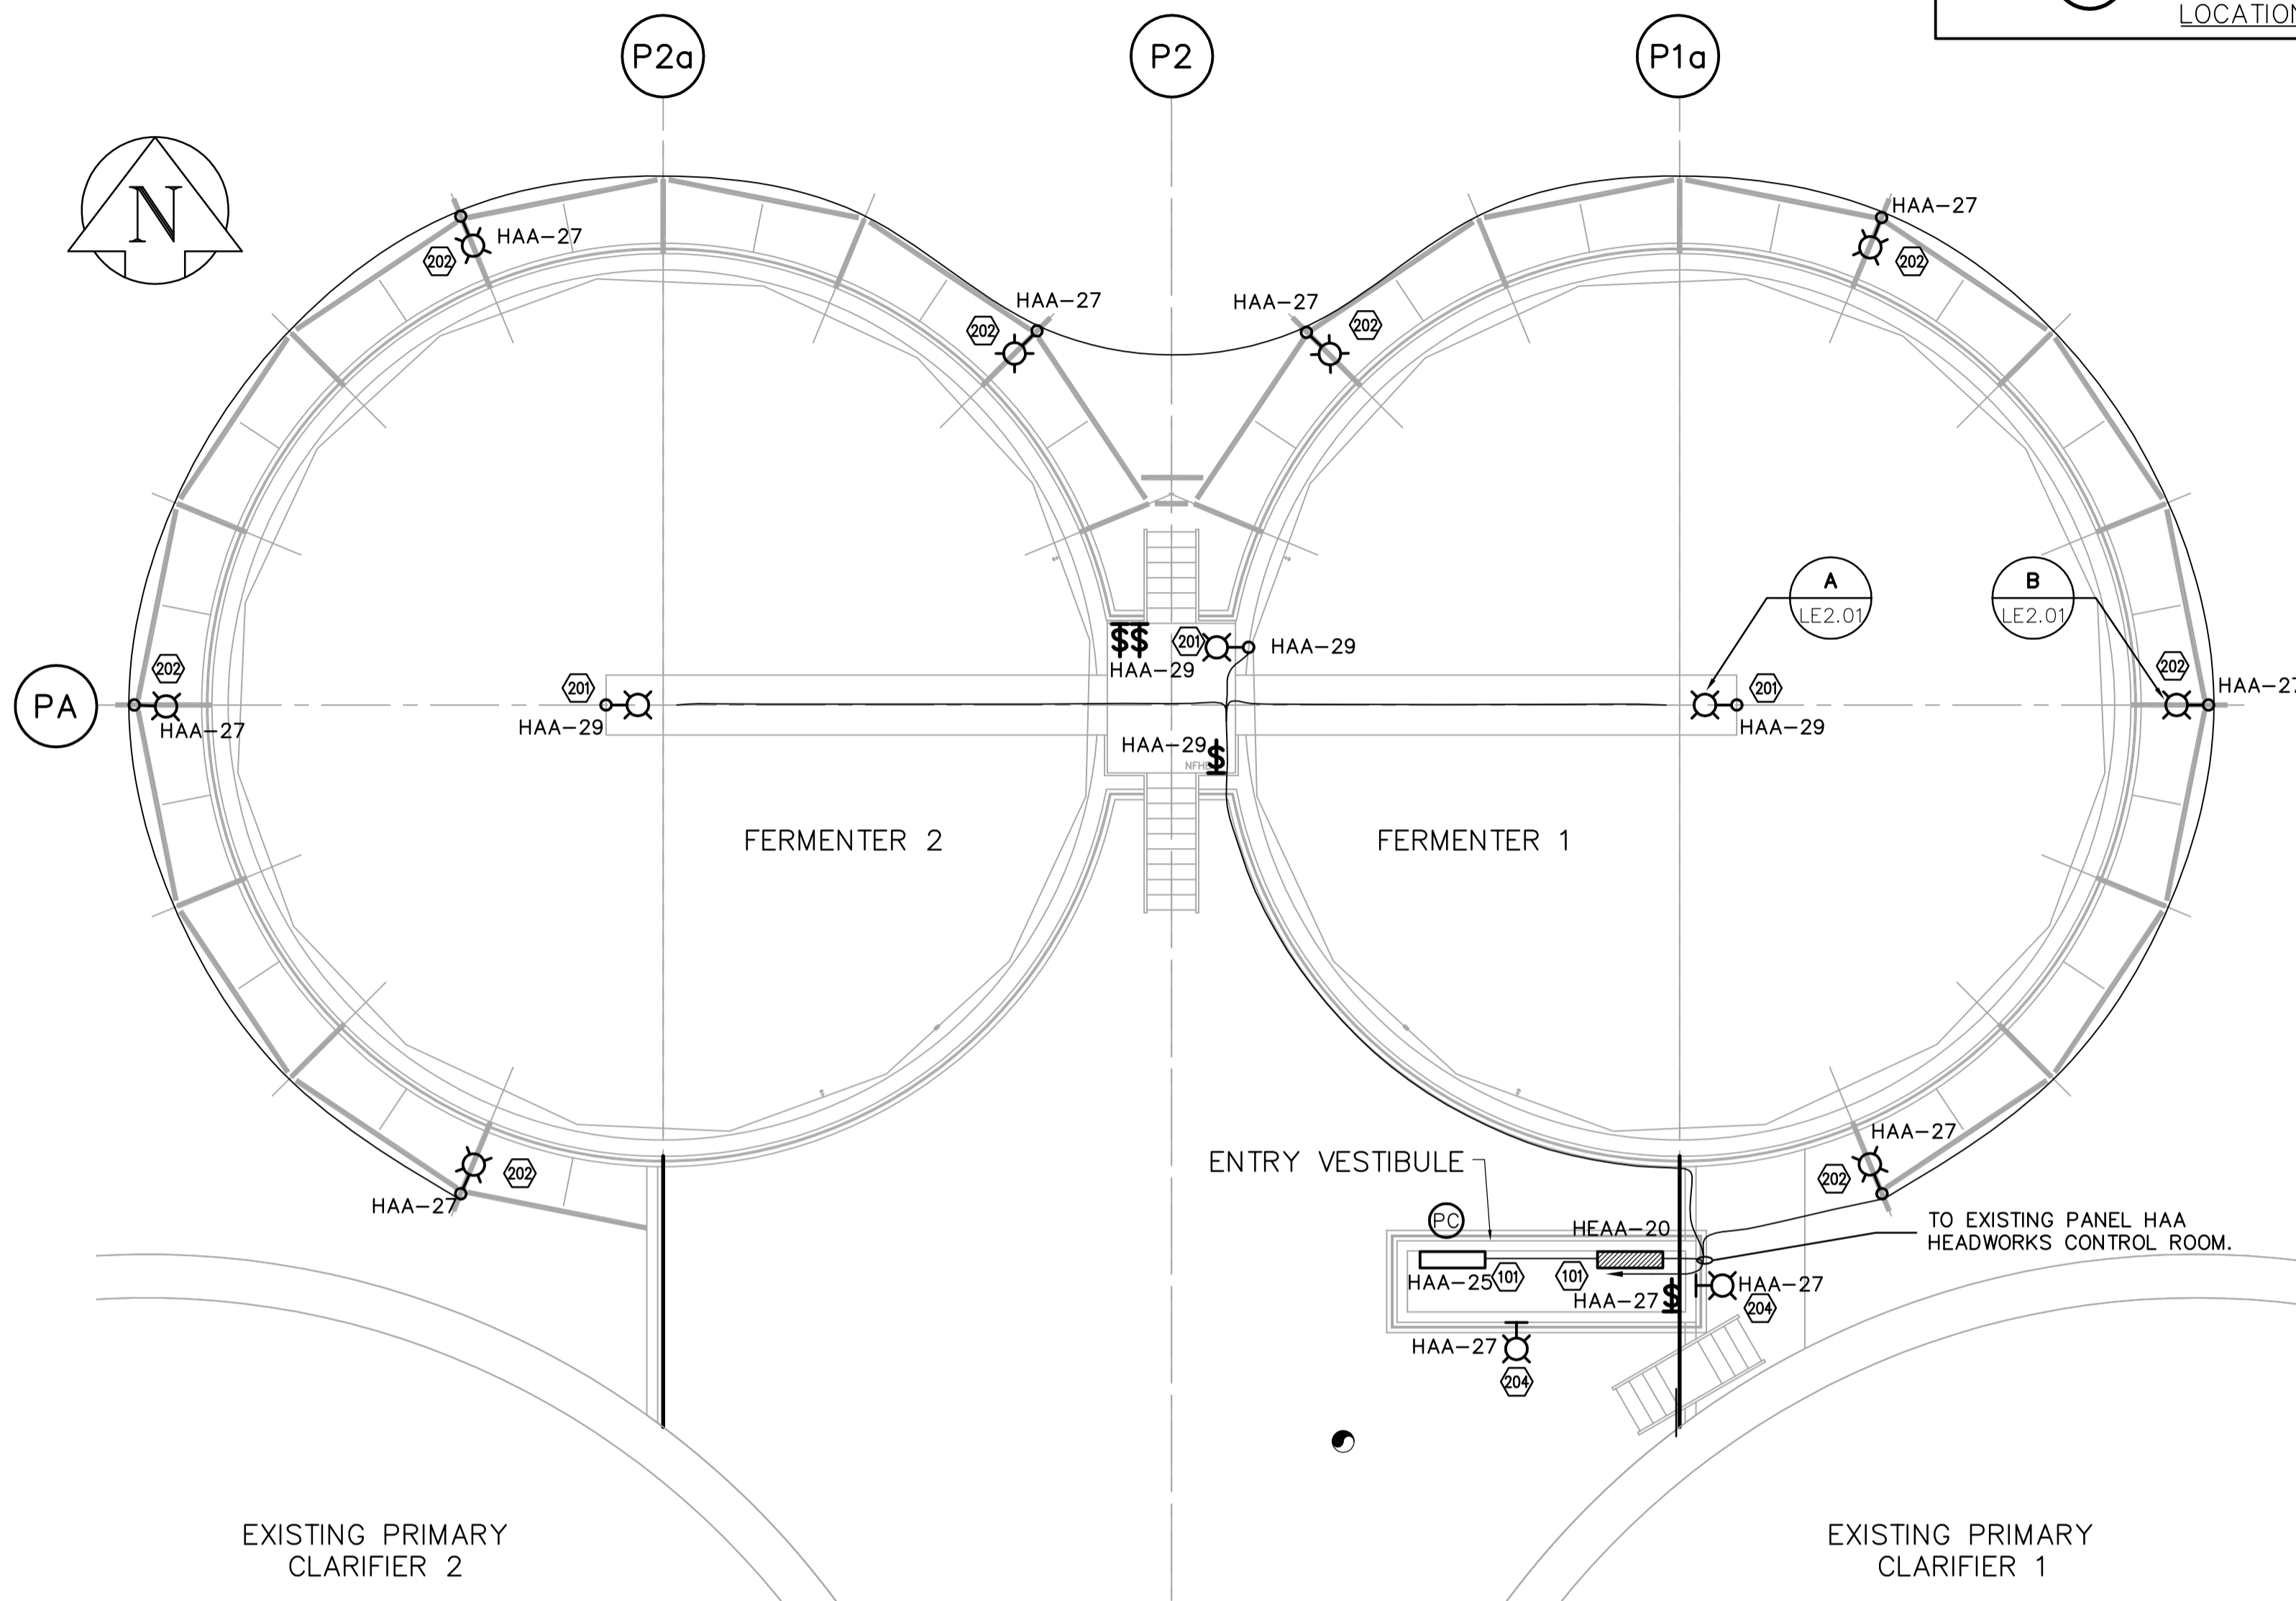

**FERMENTER ROOF - LIGHTING PLAN**  
SCALE: 1:100

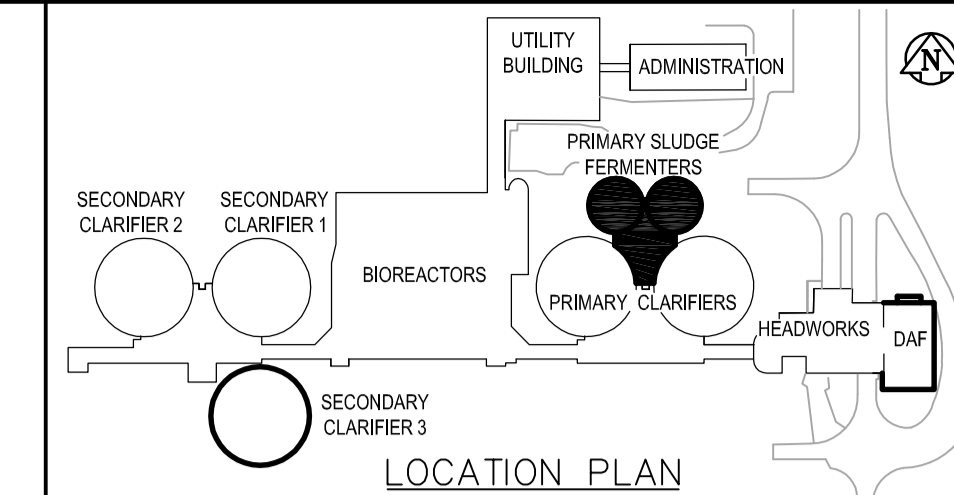

- DRAWING NOTES**
- COORDINATE LUMINAIRE CONNECTIONS WITH MECHANICAL PIPING AND DUCTWORK. WHERE REQUIRED SUSPEND LUMINAIRES BELOW SUCH EQUIPMENT.
- GENERAL NOTES**
- COORDINATE WITH OTHER TRADES TO PREVENT CONFLICTS.
  - USE PVC JACKETED HITECK CABLE FOR ALL POWER WIRING.
  - WIRING FOR LIGHTING, RECEPTACLES AND COMMUNICATIONS TO IN RIGID ALUMINUM CONDUIT.
  - ALL CONDUIT TO BE 21mmØ MINIMUM UNLESS OTHERWISE NOTED.



B.M. ELEV.	<b>EarthTech</b> A Tyco International Ltd. Company		ENGINEER'S SEAL
	DESIGNED BY: GSN	CHECKED BY: PS	ORIGINAL SIGNED BY: P. STRYK
	DRAWN BY: ERC	APPROVED BY: JEH	2006/04/26
	HOR. SCALE: AS NOTED	RELEASED FOR CONSTRUCTION BY: J. VEILLEUX	CONSULTANT DRAWING NO. FE1.01
00 ISSUED FOR TENDER	06/04/26	2005/11/22	2006/04/26
NO. REVISIONS	DATE	BY	

**THE CITY OF WINNIPEG**  
WATER AND WASTE DEPARTMENT  
ENGINEERING DIVISION

**WEWPCC**  
BIOLOGICAL NUTRIENT REMOVAL UPGRADE  
CONTRACT 3

ELECTRICAL  
AREA F- PRIMARY SLUDGE FERMENTERS  
LIGHTING AND SYSTEMS PLANS

CITY FILE NUMBER  
SHEET OF  
CITY DRAWING NUMBER