




C STAIR SECTION
FS2.04 1:25

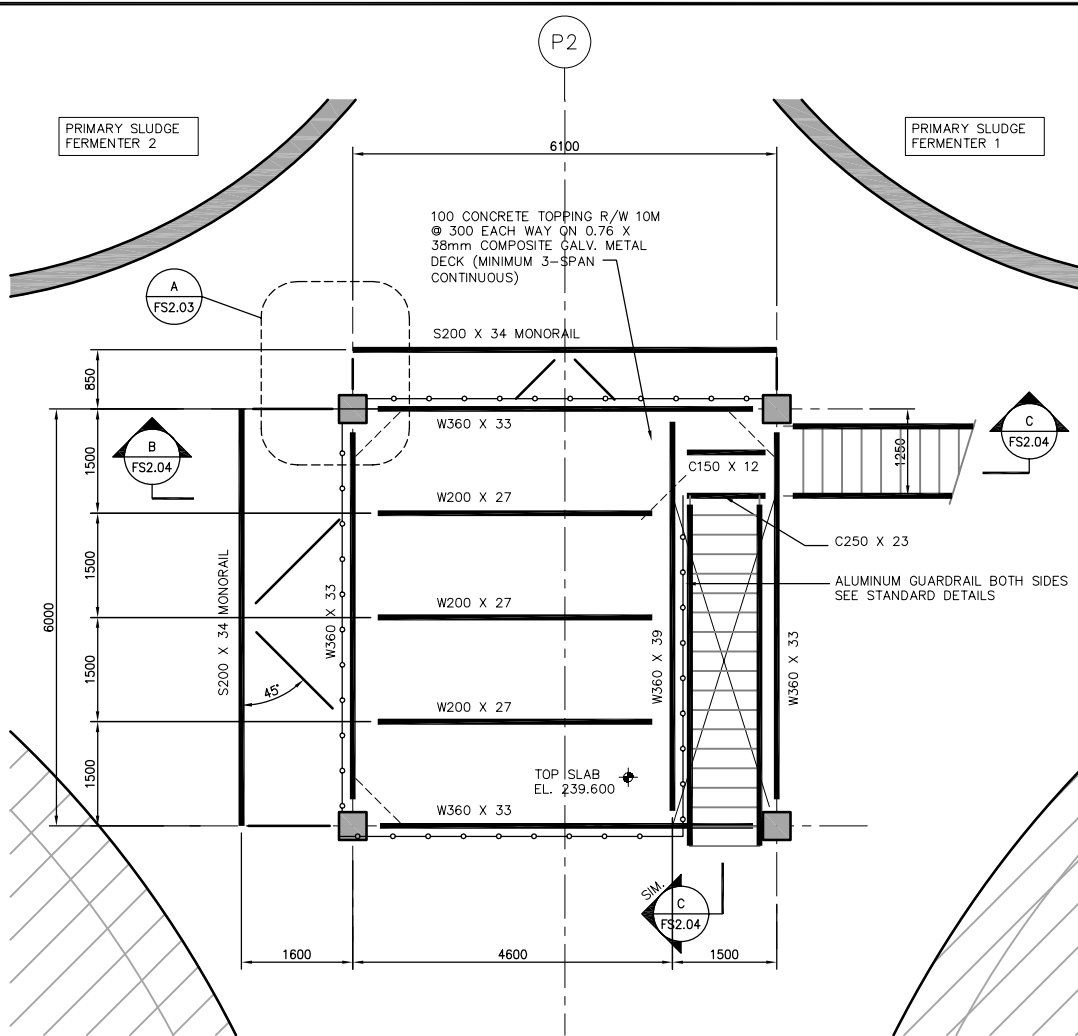


MEZZANINE FRAMING PLAN @ EL. 239.600 TOC
SCALE: 1:50

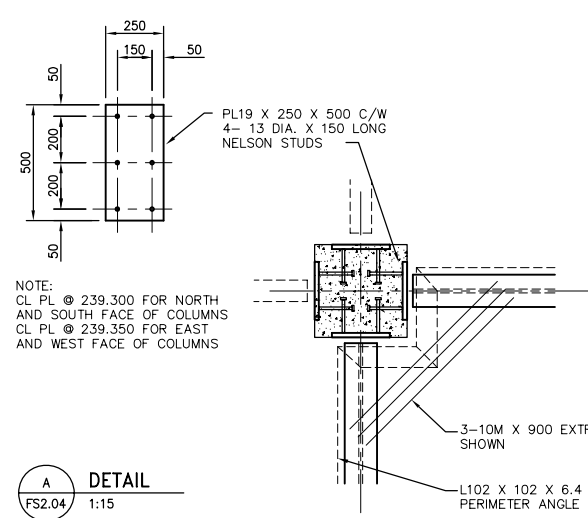


A DETAIL
FS2.04 1:15

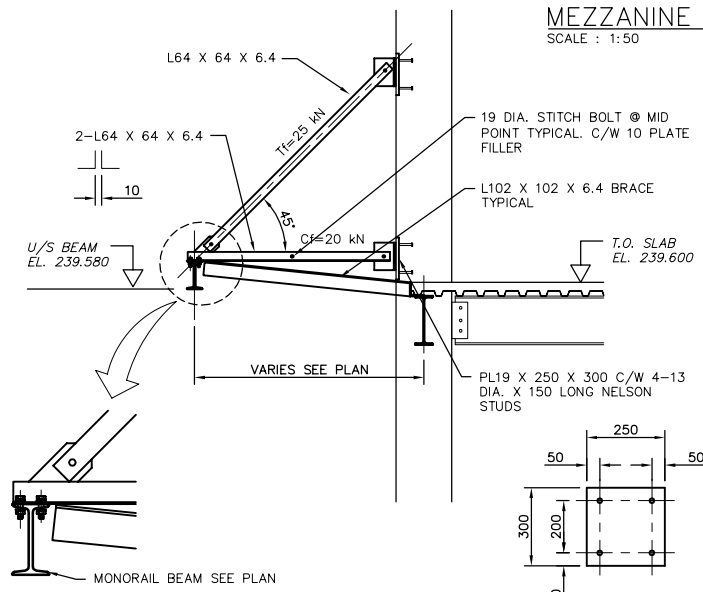

B MONORAIL SUPPORT DETAIL
FS2.04 1:25

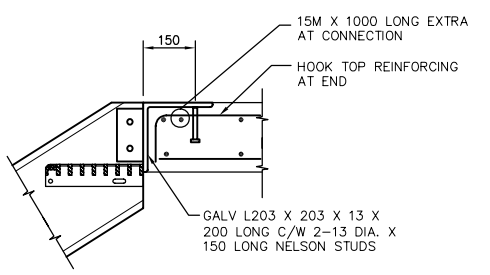

D DETAIL
FS2.04 1:10

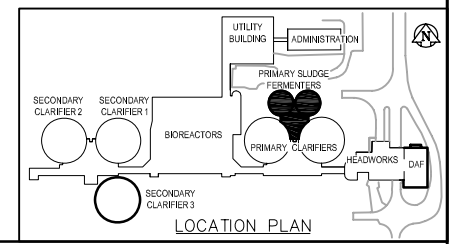

B.M. ELEV.	DESIGNED BY	CHECKED BY	ENGINEER'S SEAL
	CJG	CJG	ORIGINAL SIGNED BY C.J. GENTILE 2006/04/25
	NV	JEH	
	HOR. SCALE: AS NOTED VERTICAL SCALE: J.VEILLEUX		CONSULTANT DRAWING NO. FS2.04
00	ISSUED FOR TENDER	06/04/26	DATE 2006/03/10
	NO. REVISIONS	DATE	DATE 2006/04/26

EarthTech
A Tyco International Ltd. Company

THE CITY OF WINNIPEG
WATER AND WASTE DEPARTMENT
ENGINEERING DIVISION

WEWPC
BIOLOGICAL NUTRIENT REMOVAL UPGRADE
CONTRACT No. 3

STRUCTURAL
AREA F - PRIMARY SLUDGE FERMENTERS
MEZZANINE FRAMING AND DETAILS

CITY FILE NUMBER
SHEET OF
CITY DRAWING NUMBER