



1 NEW ROOF PLAN
SA6.02 SCALE 1:50

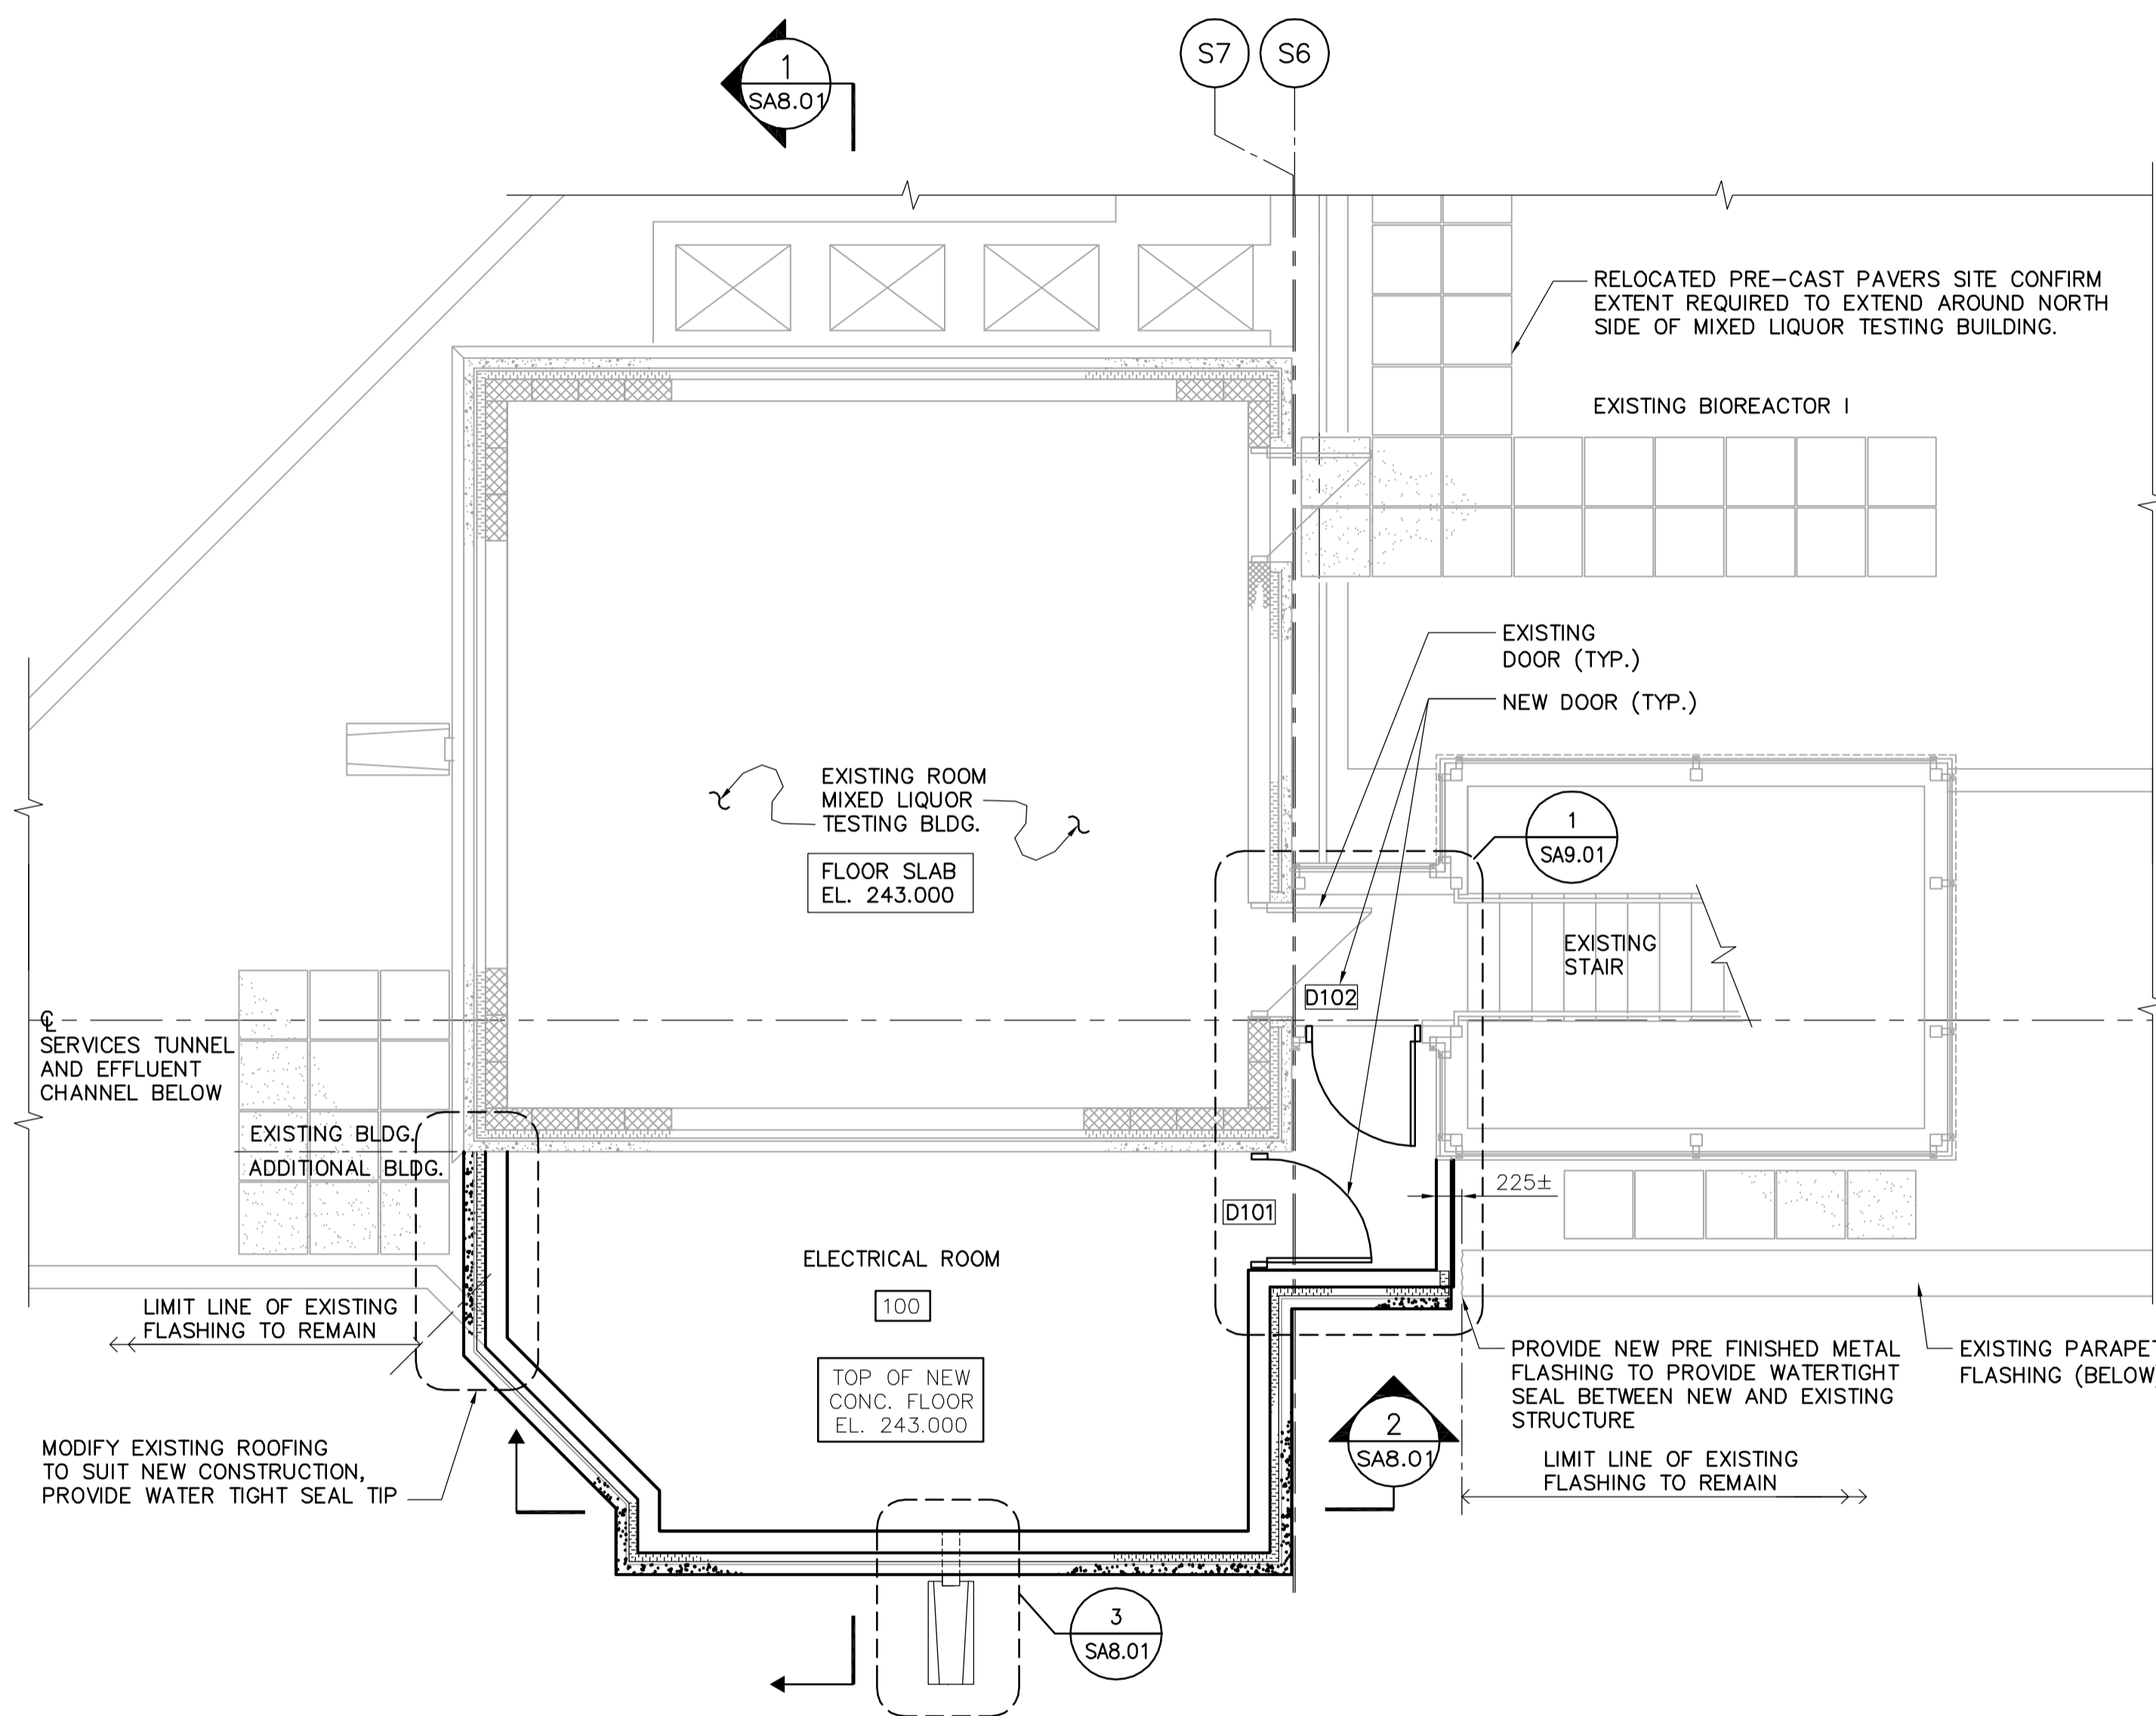

2 NEW MAIN FLOOR PLAN
SA6.02 SCALE 1:50

DRAWING NOTES:

1. DIMENSIONS NOTED ARE APPROXIMATE. SITE CONFIRM ALL DIMENSION PRIOR TO CONSTRUCTION.

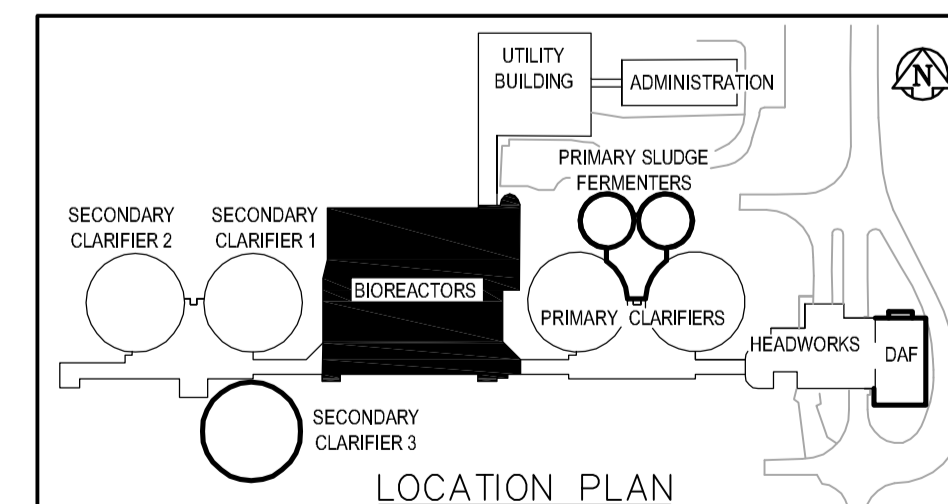

		ENGINEER'S SEAL ORIGINAL SIGNED BY N. COOPER 2006/04/26		THE CITY OF WINNIPEG WATER AND WASTE DEPARTMENT ENGINEERING DIVISION	
DESIGNED BY: GGP CHECKED BY: NC DRAWN BY: GGP APPROVED BY: JEH		CONSULTANT DRAWING NO. SA6.02		CITY FILE NUMBER SHEET 2 OF 5 CITY DRAWING NUMBER	
HOR. SCALE: AS NOTED VERTICAL SCALE: AS NOTED		RELEASED FOR CONSTRUCTION BY: J. VEILLEUX		WEWPC BIOLOGICAL NUTRIENT REMOVAL UPGRADE CONTRACT No. 3	
NO. REVISIONS DATE BY DATE		00 ISSUED FOR TENDER 06/04/26 CMF 01 2005/12/27 02 2006/04/26		ARCHITECTURAL AREA S - BIOREACTORS ELECTRICAL ROOM NEW ROOF & MAIN FLOOR PLANS	