


1 NEW MAIN FLOOR PLAN
SS6.01 SCALE 1:50


NOTE:

1. DIMENSIONS NOTED ARE APPROXIMATE. SITE CONFIRM ALL DIMENSIONS PRIOR TO CONSTRUCTION.
2. SHORE EXISTING STRUCTURE AS REQUIRED TO SUIT NEW CONSTRUCTION

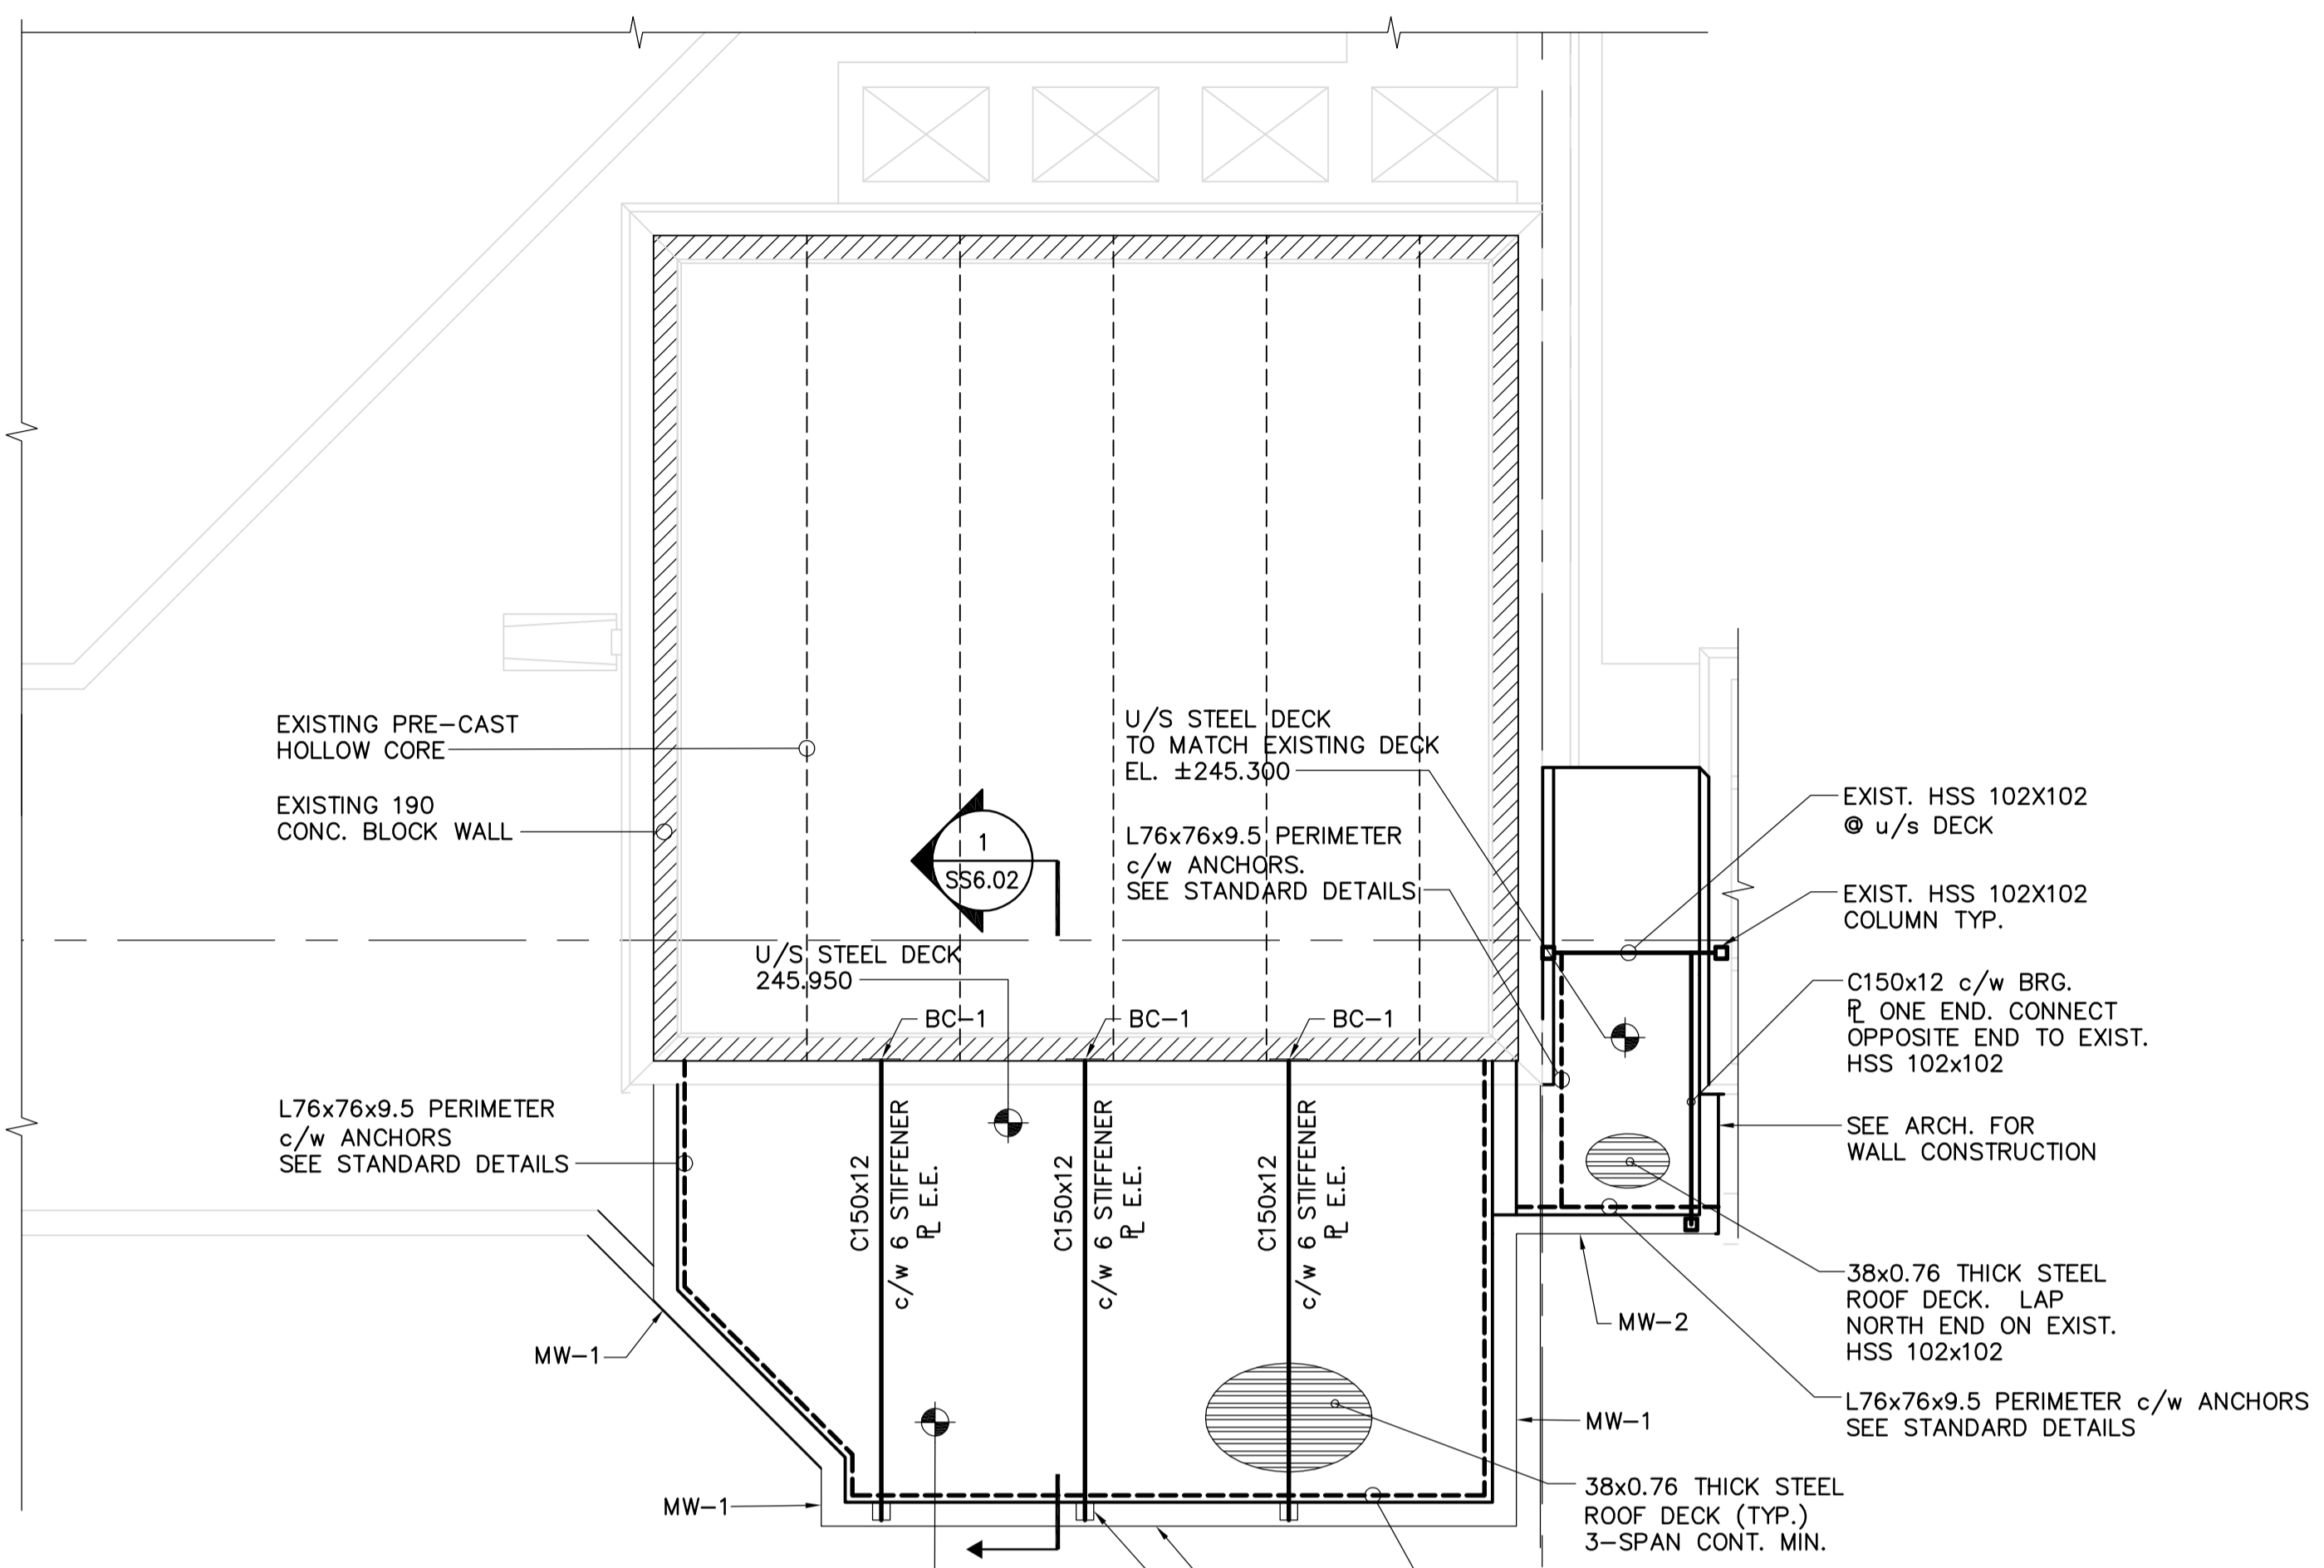

2 NEW ROOF PLAN
SS6.01 SCALE 1:50

MW-1	190 CONC. BLOCK	1-15M VERT. @ 1000 c/c
MW-2	140 CONC. BLOCK	1-10M VERT. @ 1000 c/c

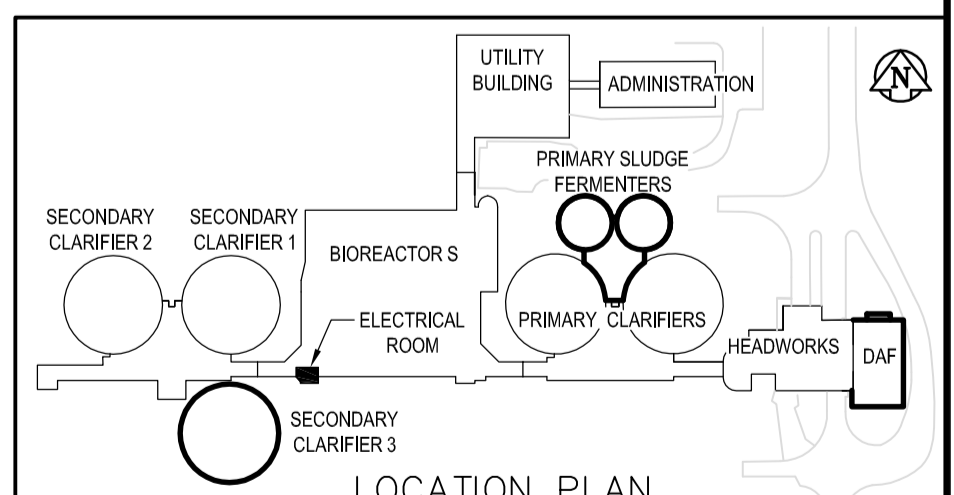

B.M. ELEV.		EarthTech A Tyco International Ltd. Company		ENGINEER'S SEAL	
DESIGNED BY	AA/JB	CHECKED BY	AA/JB	ORIGINAL SIGNED BY	J. BETKE
DRAWN BY	WDB	APPROVED BY	JEH	DATE	2006/04/26
HOR. SCALE: AS NOTED		RELEASED FOR CONSTRUCTION BY:		CONSULTANT DRAWING NO.	
VERTICAL SCALE: AS NOTED		J. VEILLEUX		SS6.01	
NO.	REVISIONS	DATE	BY	DATE	2006/04/26
00	ISSUED FOR TENDER	06/04/26	CMF	DATE	2006/04/26

THE CITY OF WINNIPEG
WATER AND WASTE DEPARTMENT
ENGINEERING DIVISION

WEWPCC
EFFLUENT DISINFECTION FACILITY
CONTRACT No. 2

STRUCTURAL
AREA S - BIOREACTORS
ELECTRICAL ROOM PLANS

CITY FILE NUMBER
SHEET OF
CITY DRAWING NUMBER