



1 MEZZANINE PLAN  
TA1.02 1:100

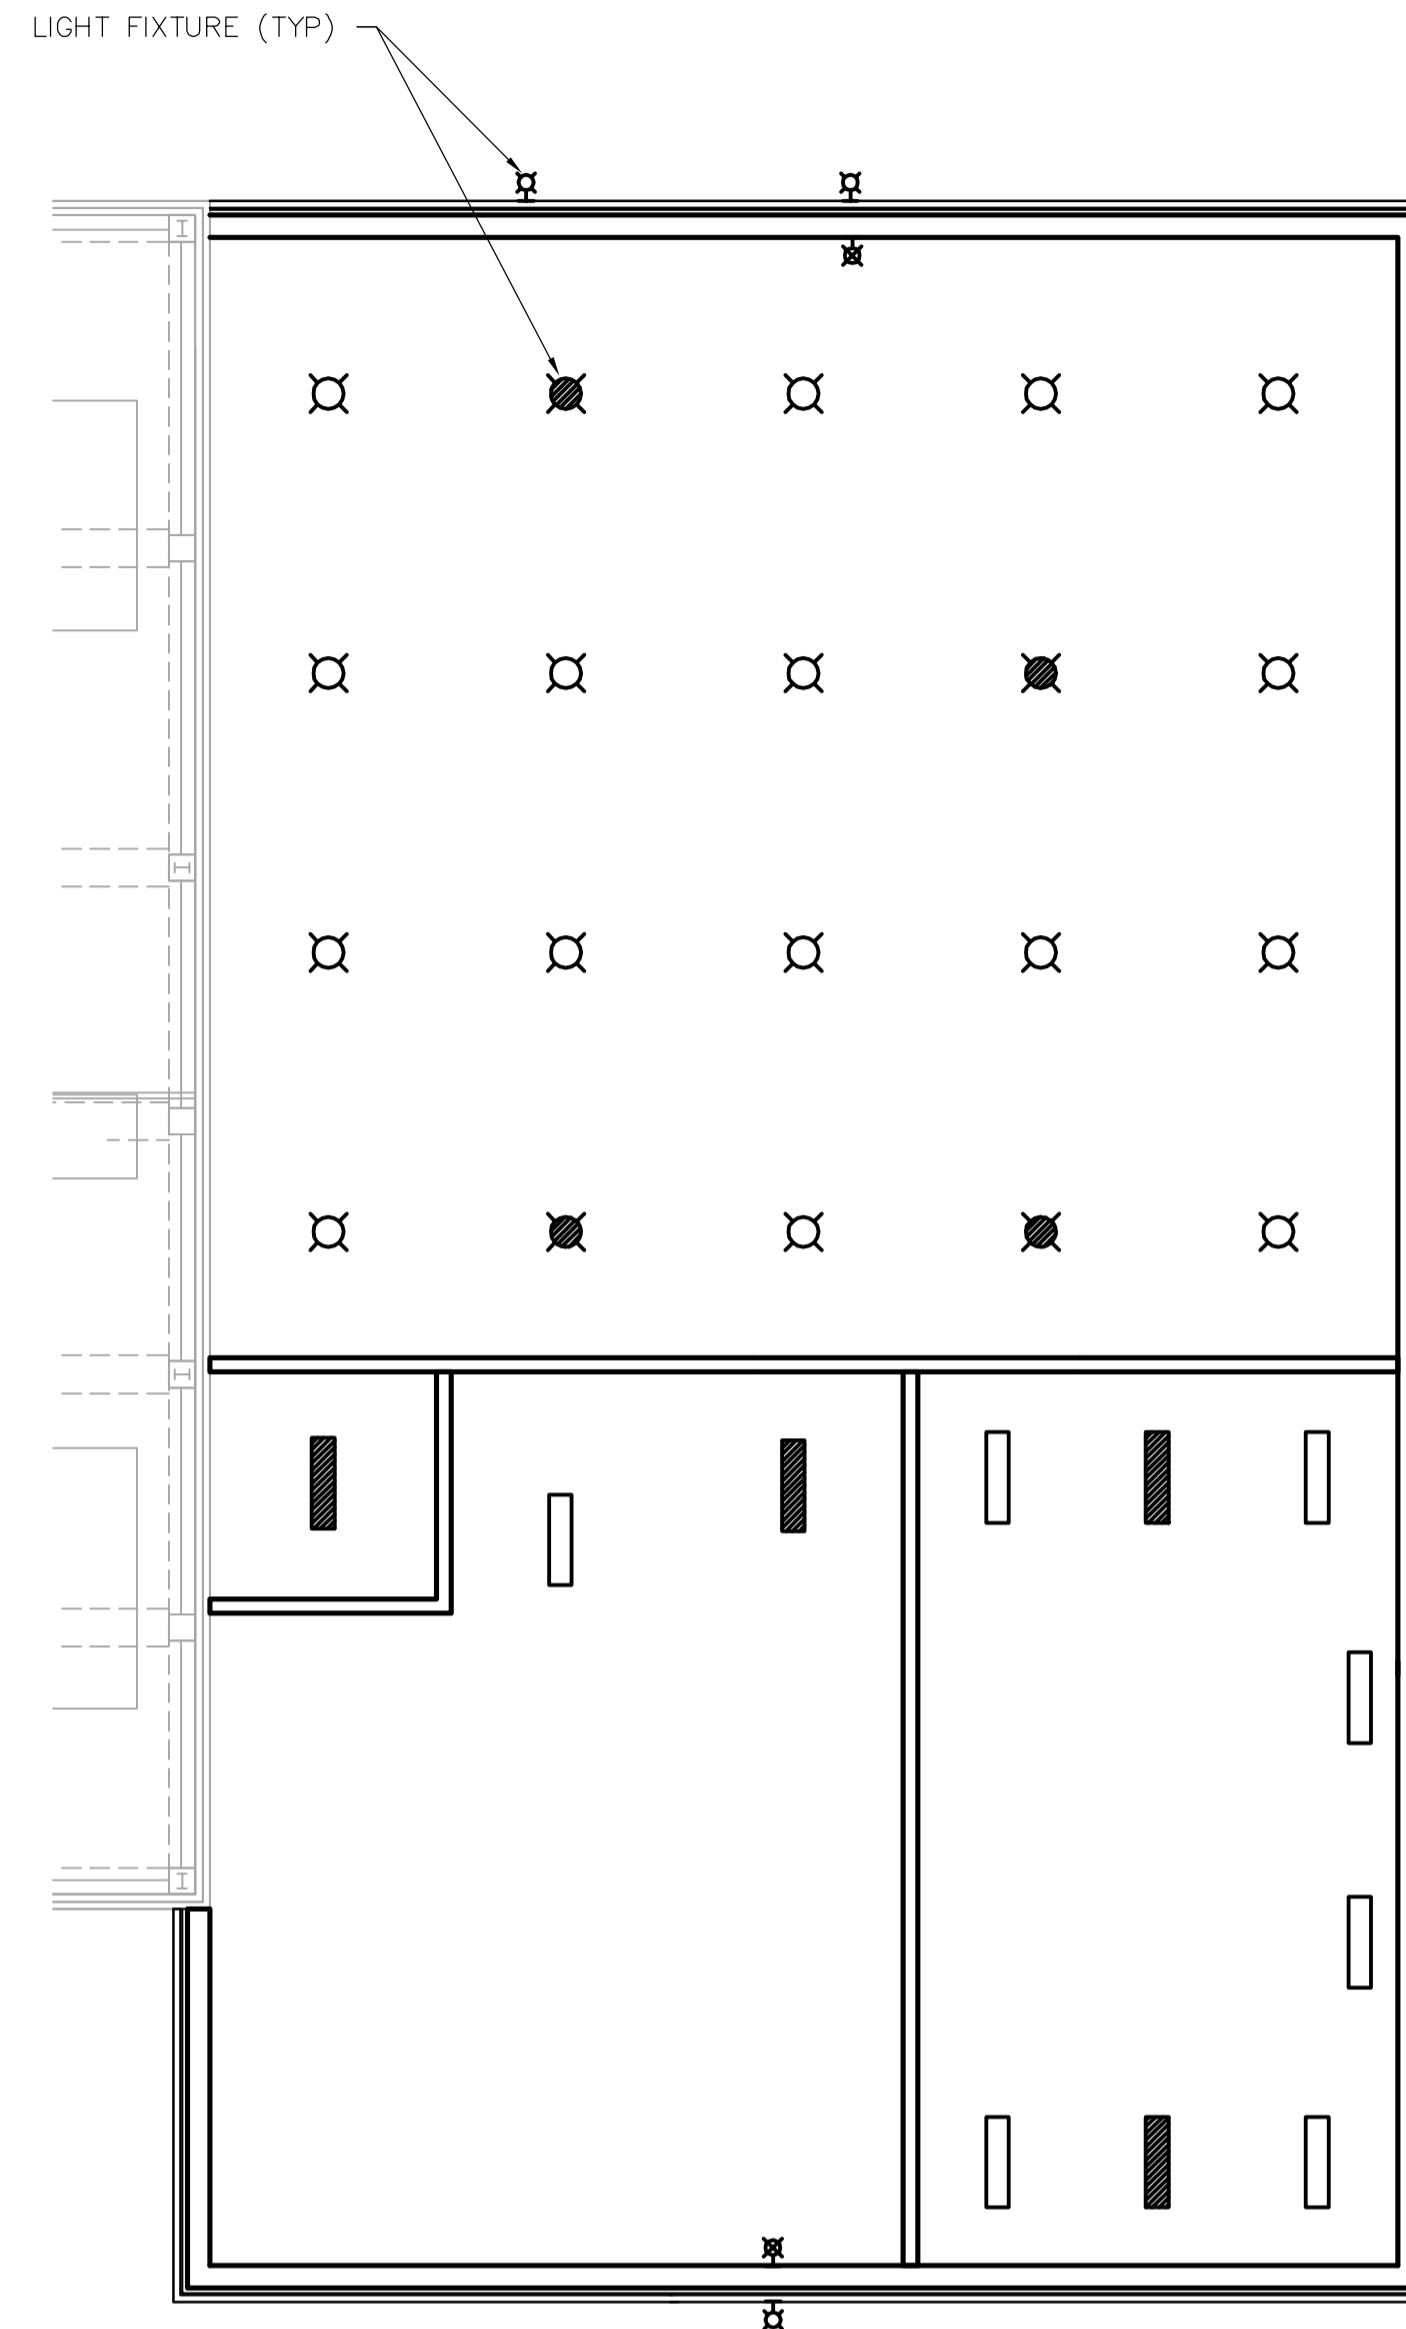

2 MAIN FLOOR REFLECTED CEILING PLAN  
TA1.02 1:100

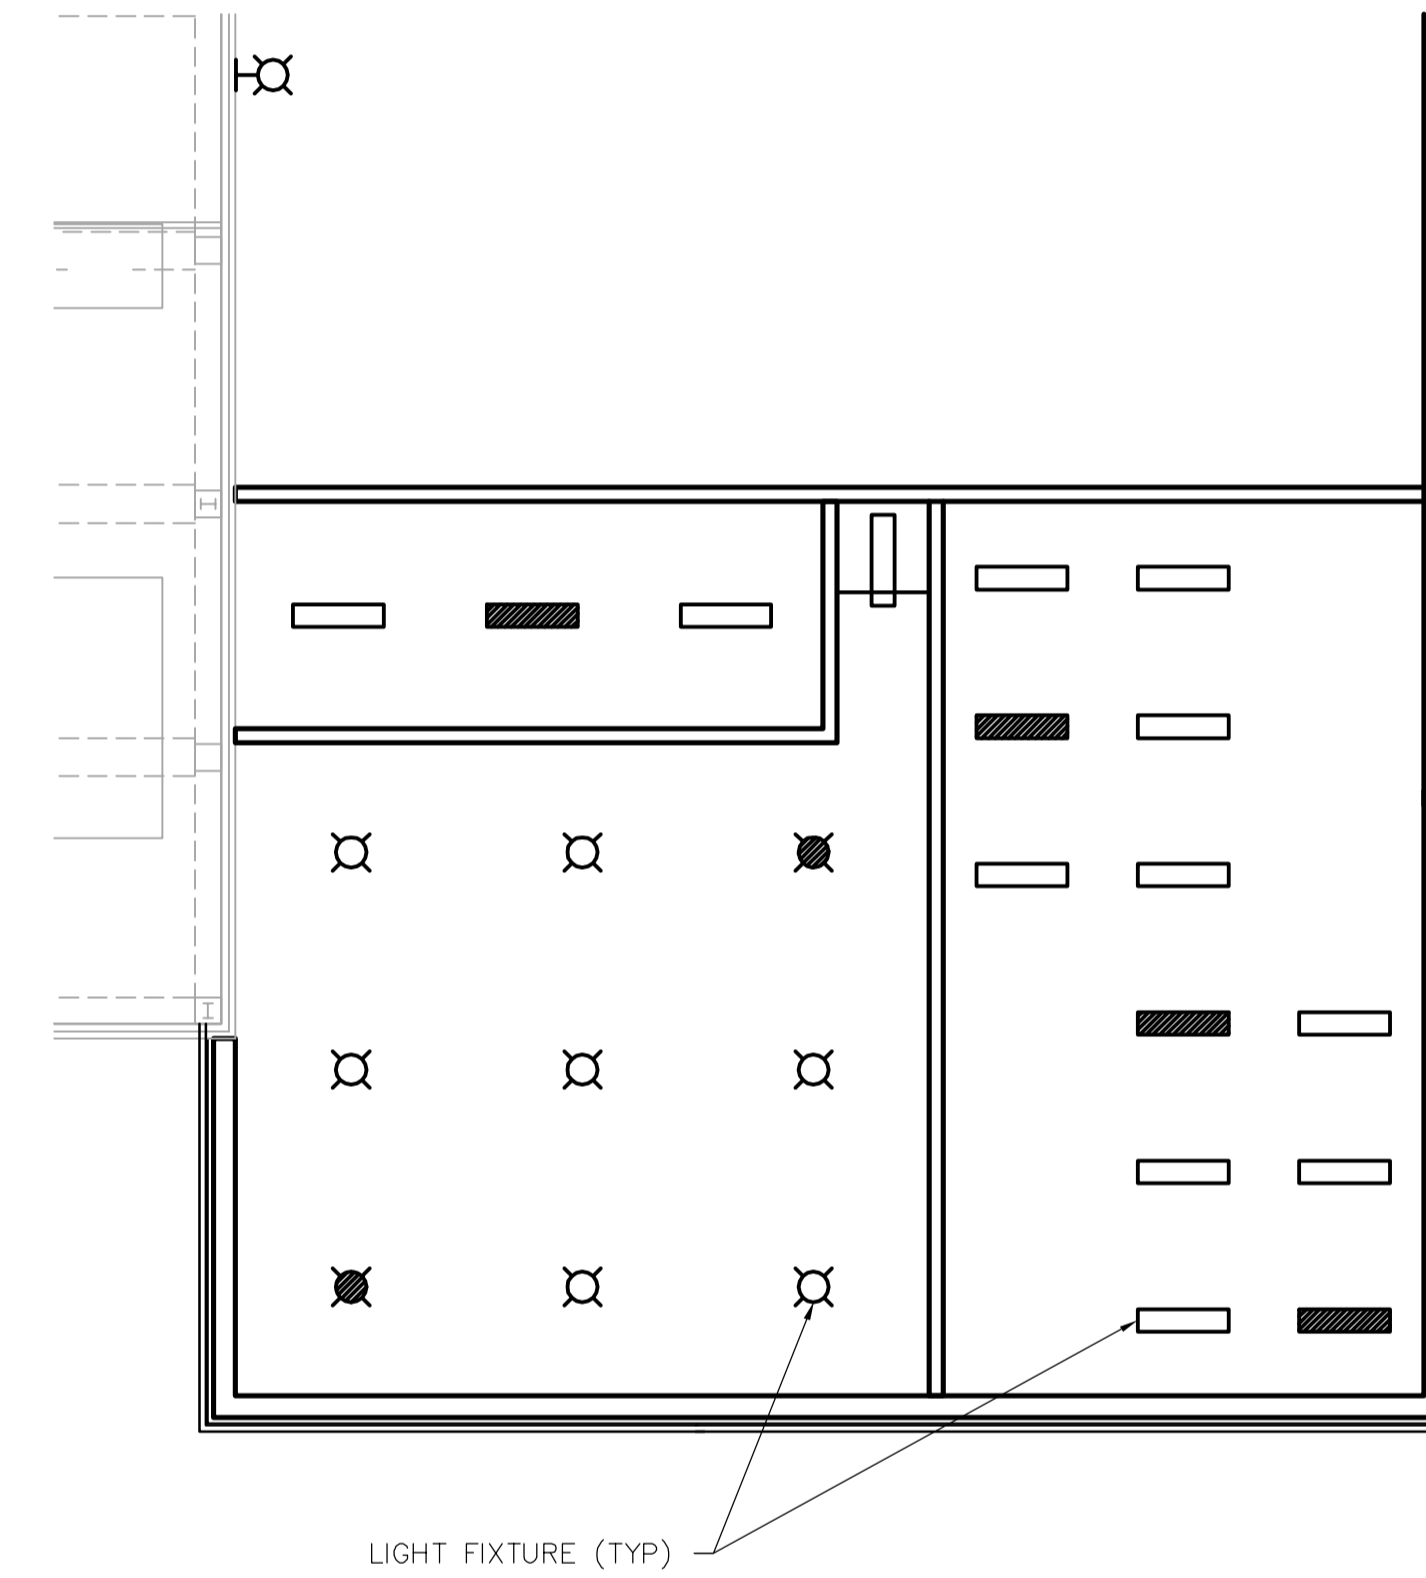


3 MEZZANINE REFLECTED CEILING PLAN  
TA1.02 1:100

DOOR SCHEDULE

DOOR NO	TO ROOM	DOOR				FRAME						HDW GROUP	FIRE RATING	GRILLES	COMMENTS		
		SIZE	SWING	TYPE	MAT	CORE	FINISH	COLOUR	PROFILE	MAT	TYPE					FINISH	COLOUR
D201A	MECHANICAL	45x900x2150	LH	1	HM	HC	PT	A	2	HM	WLD	PT	A	1	N/A	N/A	
D201B	EXTERIOR	45x900x2150	RH	1	HM	INSUL	PT	A	1	HM	WLD	PT	A	4	N/A	N/A	BLANK EXTERIOR
D202	ELECTRICAL	45x900x2150	RH	1	HM	HC	PT	A	2	HM	WLD	PT	A	1	N/A	N/A	

FINISH SCHEDULE

ROOM NO	ROOM NAME	FLOOR				WALLS								CEILING			COMMENTS								
		FLOORING		BASE		NORTH		EAST		SOUTH		WEST		CEILING											
		MAT	COLOUR	MAT	COL	MAT	FINISH	COLOUR	MAT	FINISH	COLOUR	MAT	FINISH	COLOUR	MAT	FINISH		COLOUR	HGT	AFF					
201	MECHANICAL	EPOXY	A	EPXY COV	A	CB	PT	C	CB	PT	C	CB	PT	C	CB	PT	C	CB	PT	C	METAL	PT	BLACK	+/-3750	
202	ELECTRICAL	EPOXY	A	EPXY COV	A	CB	PT	C	CB	PT	C	CB	PT	C	CB	PT	C	CB	PT	C	METAL	PT	BLACK	+/-3950	

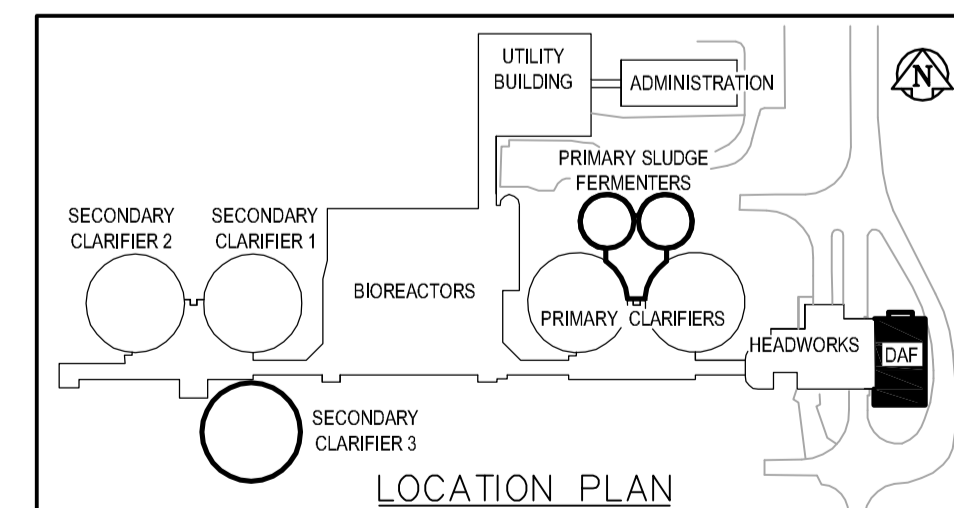

B.M. ELEV. DESIGNED BY: NC CHECKED BY: NC DRAWN BY: LK APPROVED BY: JEH HOR. SCALE: AS NOTED VERTICAL SCALE: AS NOTED RELEASED FOR CONSTRUCTION BY: J. VEILLEUX NO. REVISIONS: 00 DATE: 06/04/26 BY: LK DATE: 2006/01/03 DATE: 2006/04/26	<b>EarthTech</b> A Tyco International Ltd. Company	ENGINEER'S SEAL ORIGINAL SIGNED BY: N. COOPER DATE: 2006/04/26	<b>THE CITY OF WINNIPEG</b> WATER AND WASTE DEPARTMENT ENGINEERING DIVISION WEWPC BIOLOGICAL NUTRIENT REMOVAL UPGRADE CONTRACT No. 3 ARCHITECTURAL AREA T - DAF THICKENER BUILDING MEZZANINE FLOOR AND REF CEILING PLANS, & SCHEDULES	CITY FILE NUMBER SHEET 2 OF 6 CITY DRAWING NUMBER
		CONSULTANT DRAWING NO. TA1.02		
		DATE: 2006/01/03 DATE: 2006/04/26		
		DATE: 2006/01/03 DATE: 2006/04/26		