



CODE


- 1. PENTHOUSE
- 2. CHIMNEY
- 3. AIR COND. UNITS
- 4. SIGN SUPPORT
- 5. VENTILATOR
- 6. VENT PIPE
- 7. DRAIN
- 8. SKYLIGHT
- 9. EAVESTROUGH
- 10. FIRE WALL
- 11. TANK
- 12. STUB COLUMN
- 13. GRAVEL STOP
- 14. HATCH
- 15. SCUPPER
- 16. PITCH BOXES
- 17. ANTENNA
- 18. GUYWIRE
- 19.
- 20.

PARAPET

CONTROL JOINT

FULL ROOF REPLACEMENT

PARTIAL ROOF REPLACEMENT

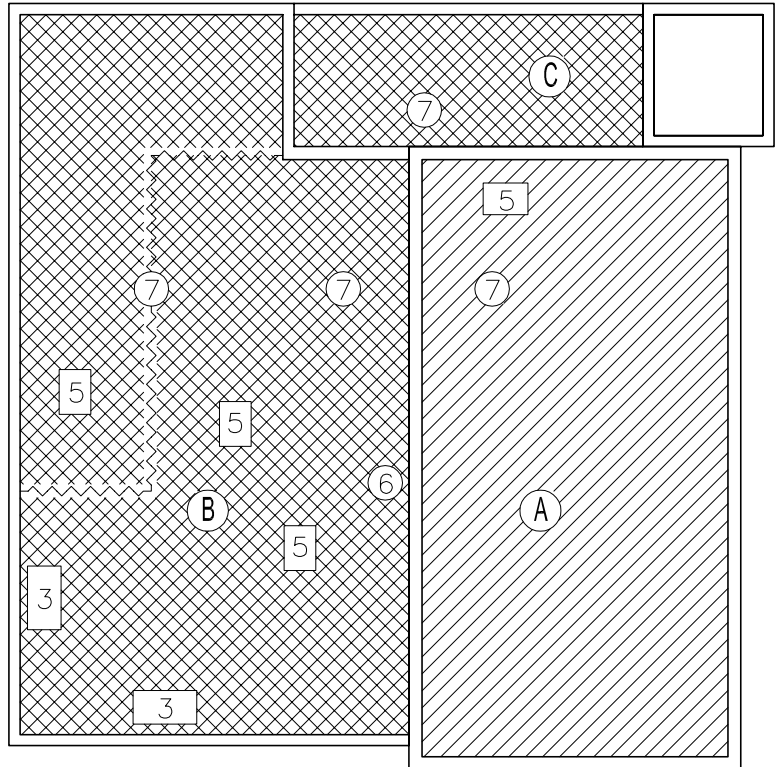

CITY OF WINNIPEG
 PLANNING, PROPERTY &
 DEVELOPMENT DEPARTMENT
 CIVIC ACCOMMODATIONS DIVISION
 300-65 GARRY STREET R3C 4K4

PROJECT
FIRE STATION NO. 12
ROOF REPLACEMENT
 1710 GROVENOR AVE.

SHEET TITLE
ROOF PLAN

DRAWN BY

DNJ

CHECKED BY

LOR

APPROVED BY

LOR

DATE

2006.04.19

eFILE

2006033V0.dwg

SCALE

1/8" = 1'-0"

PROJECT

NO. 2006-033

SHEET NO.

A1