



1 EXHAUST FAN BUILDING - HVAC PLAN
M1.02 SCALE 1:100

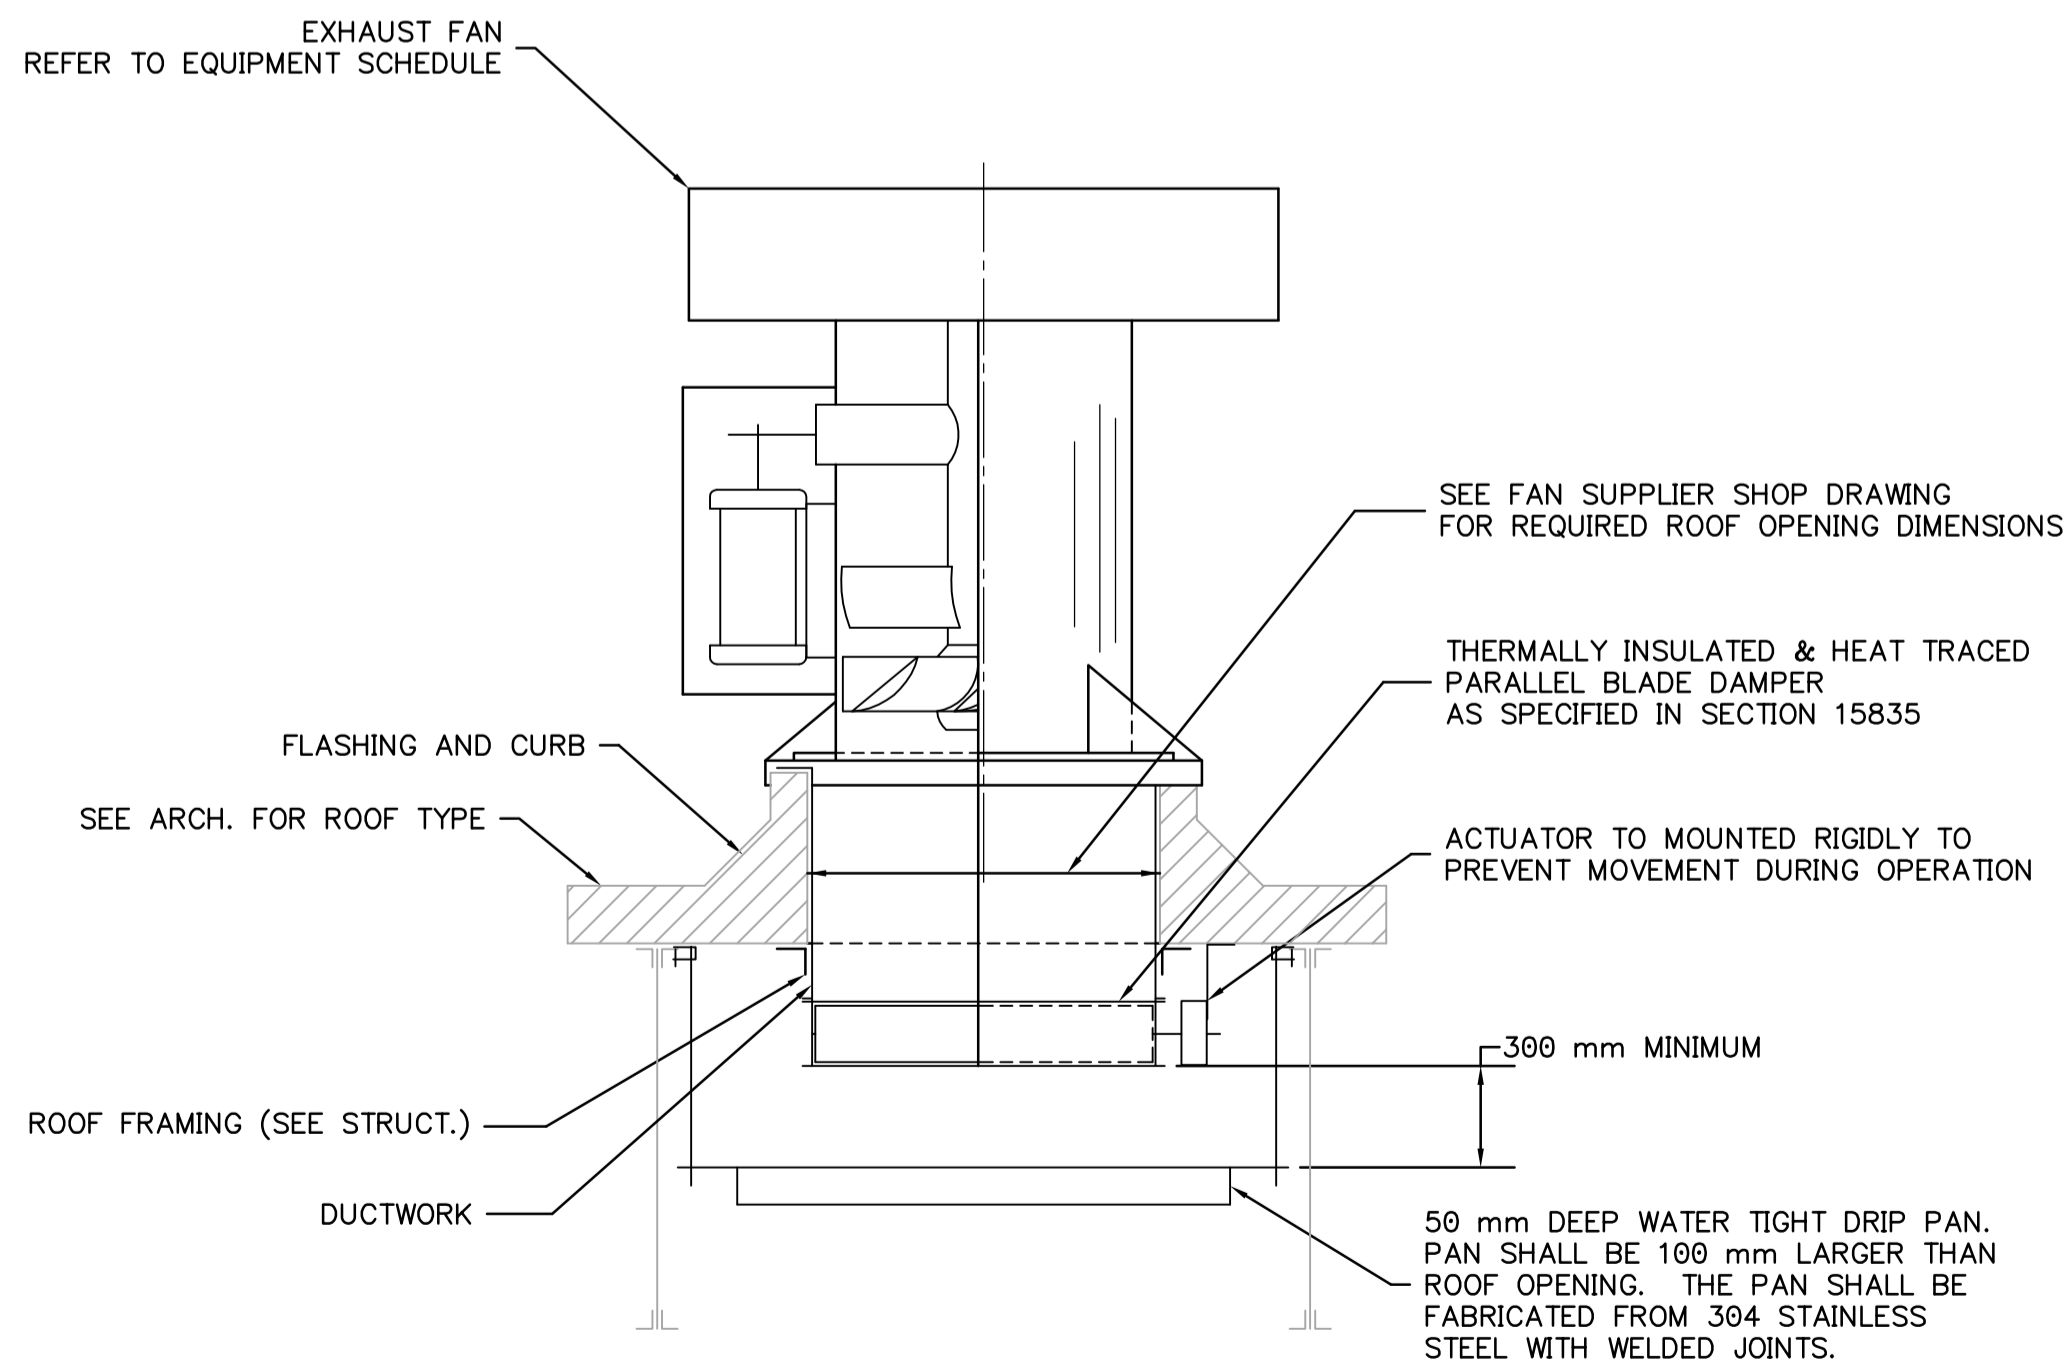


4 EXHAUST FAN ON ROOF DETAIL
M1.02 SCALE N.T.S.

GENERAL NOTE:
1. MECHANICAL CONTRACTOR SHALL PROVIDE AN APPROVED FIRE STOPPING SYSTEM IN FIRE RATED AREAS

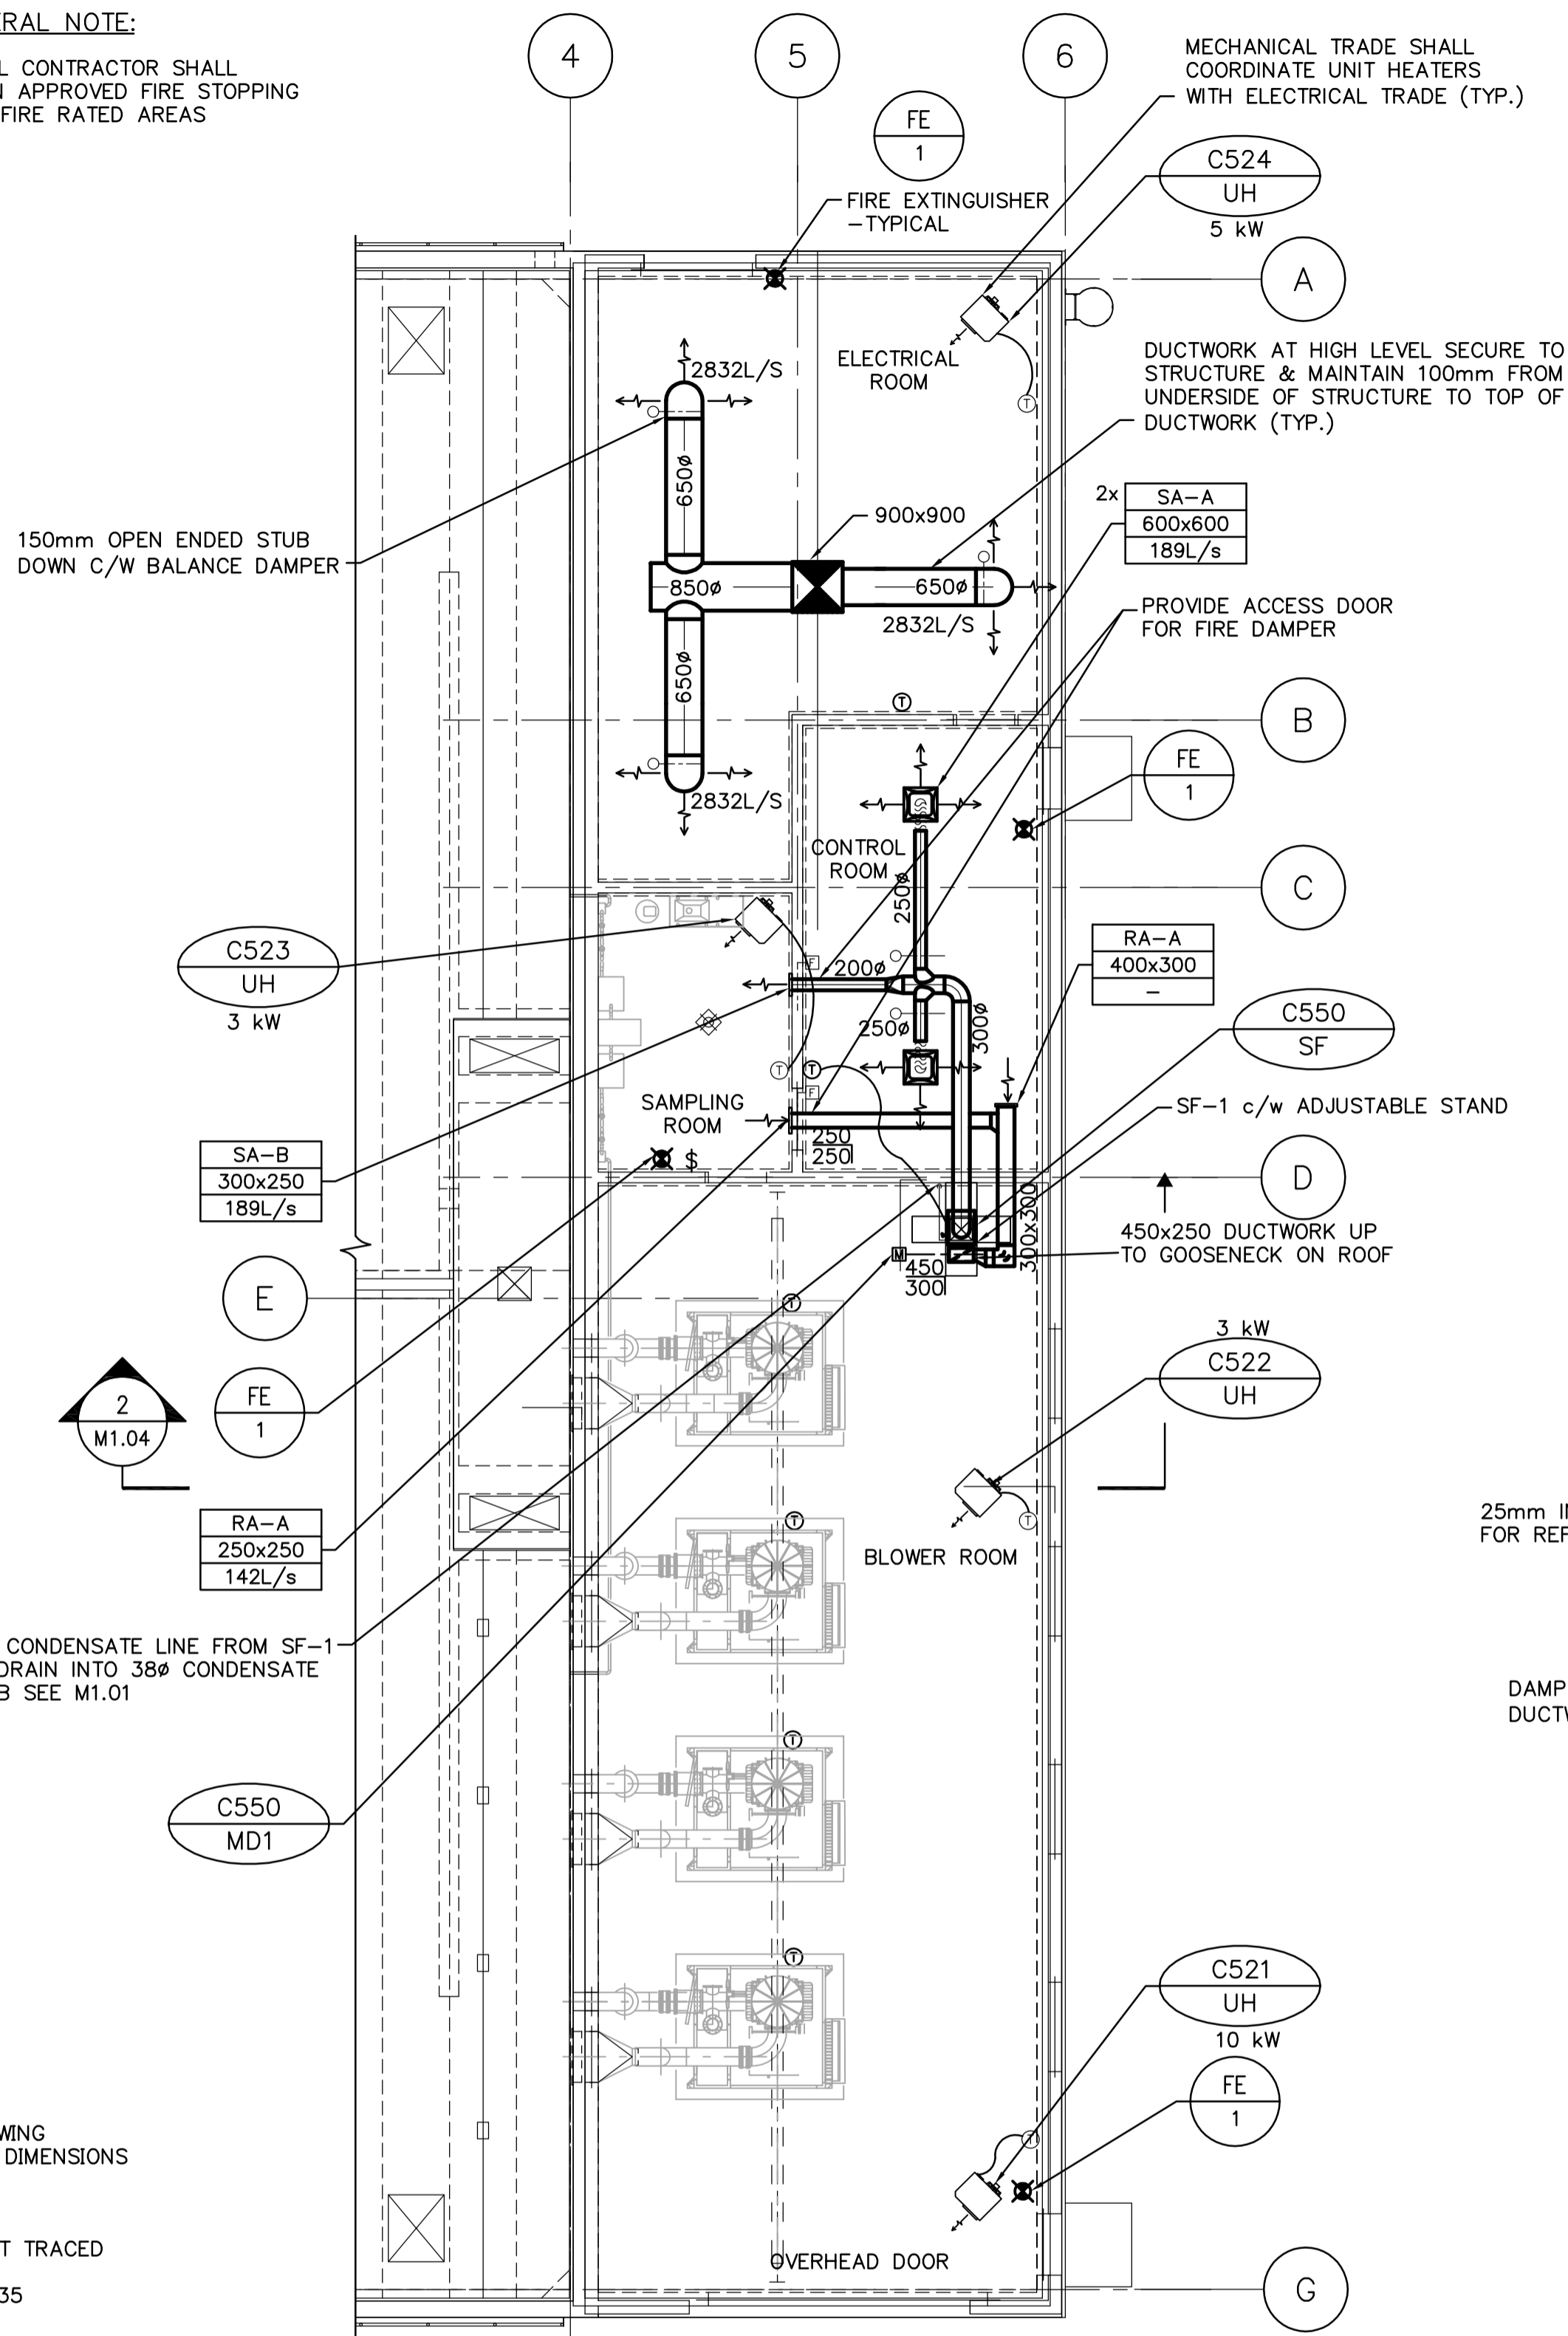

2 BLOWER BUILDING - HVAC FLOOR PLAN
M1.02 SCALE 1:100

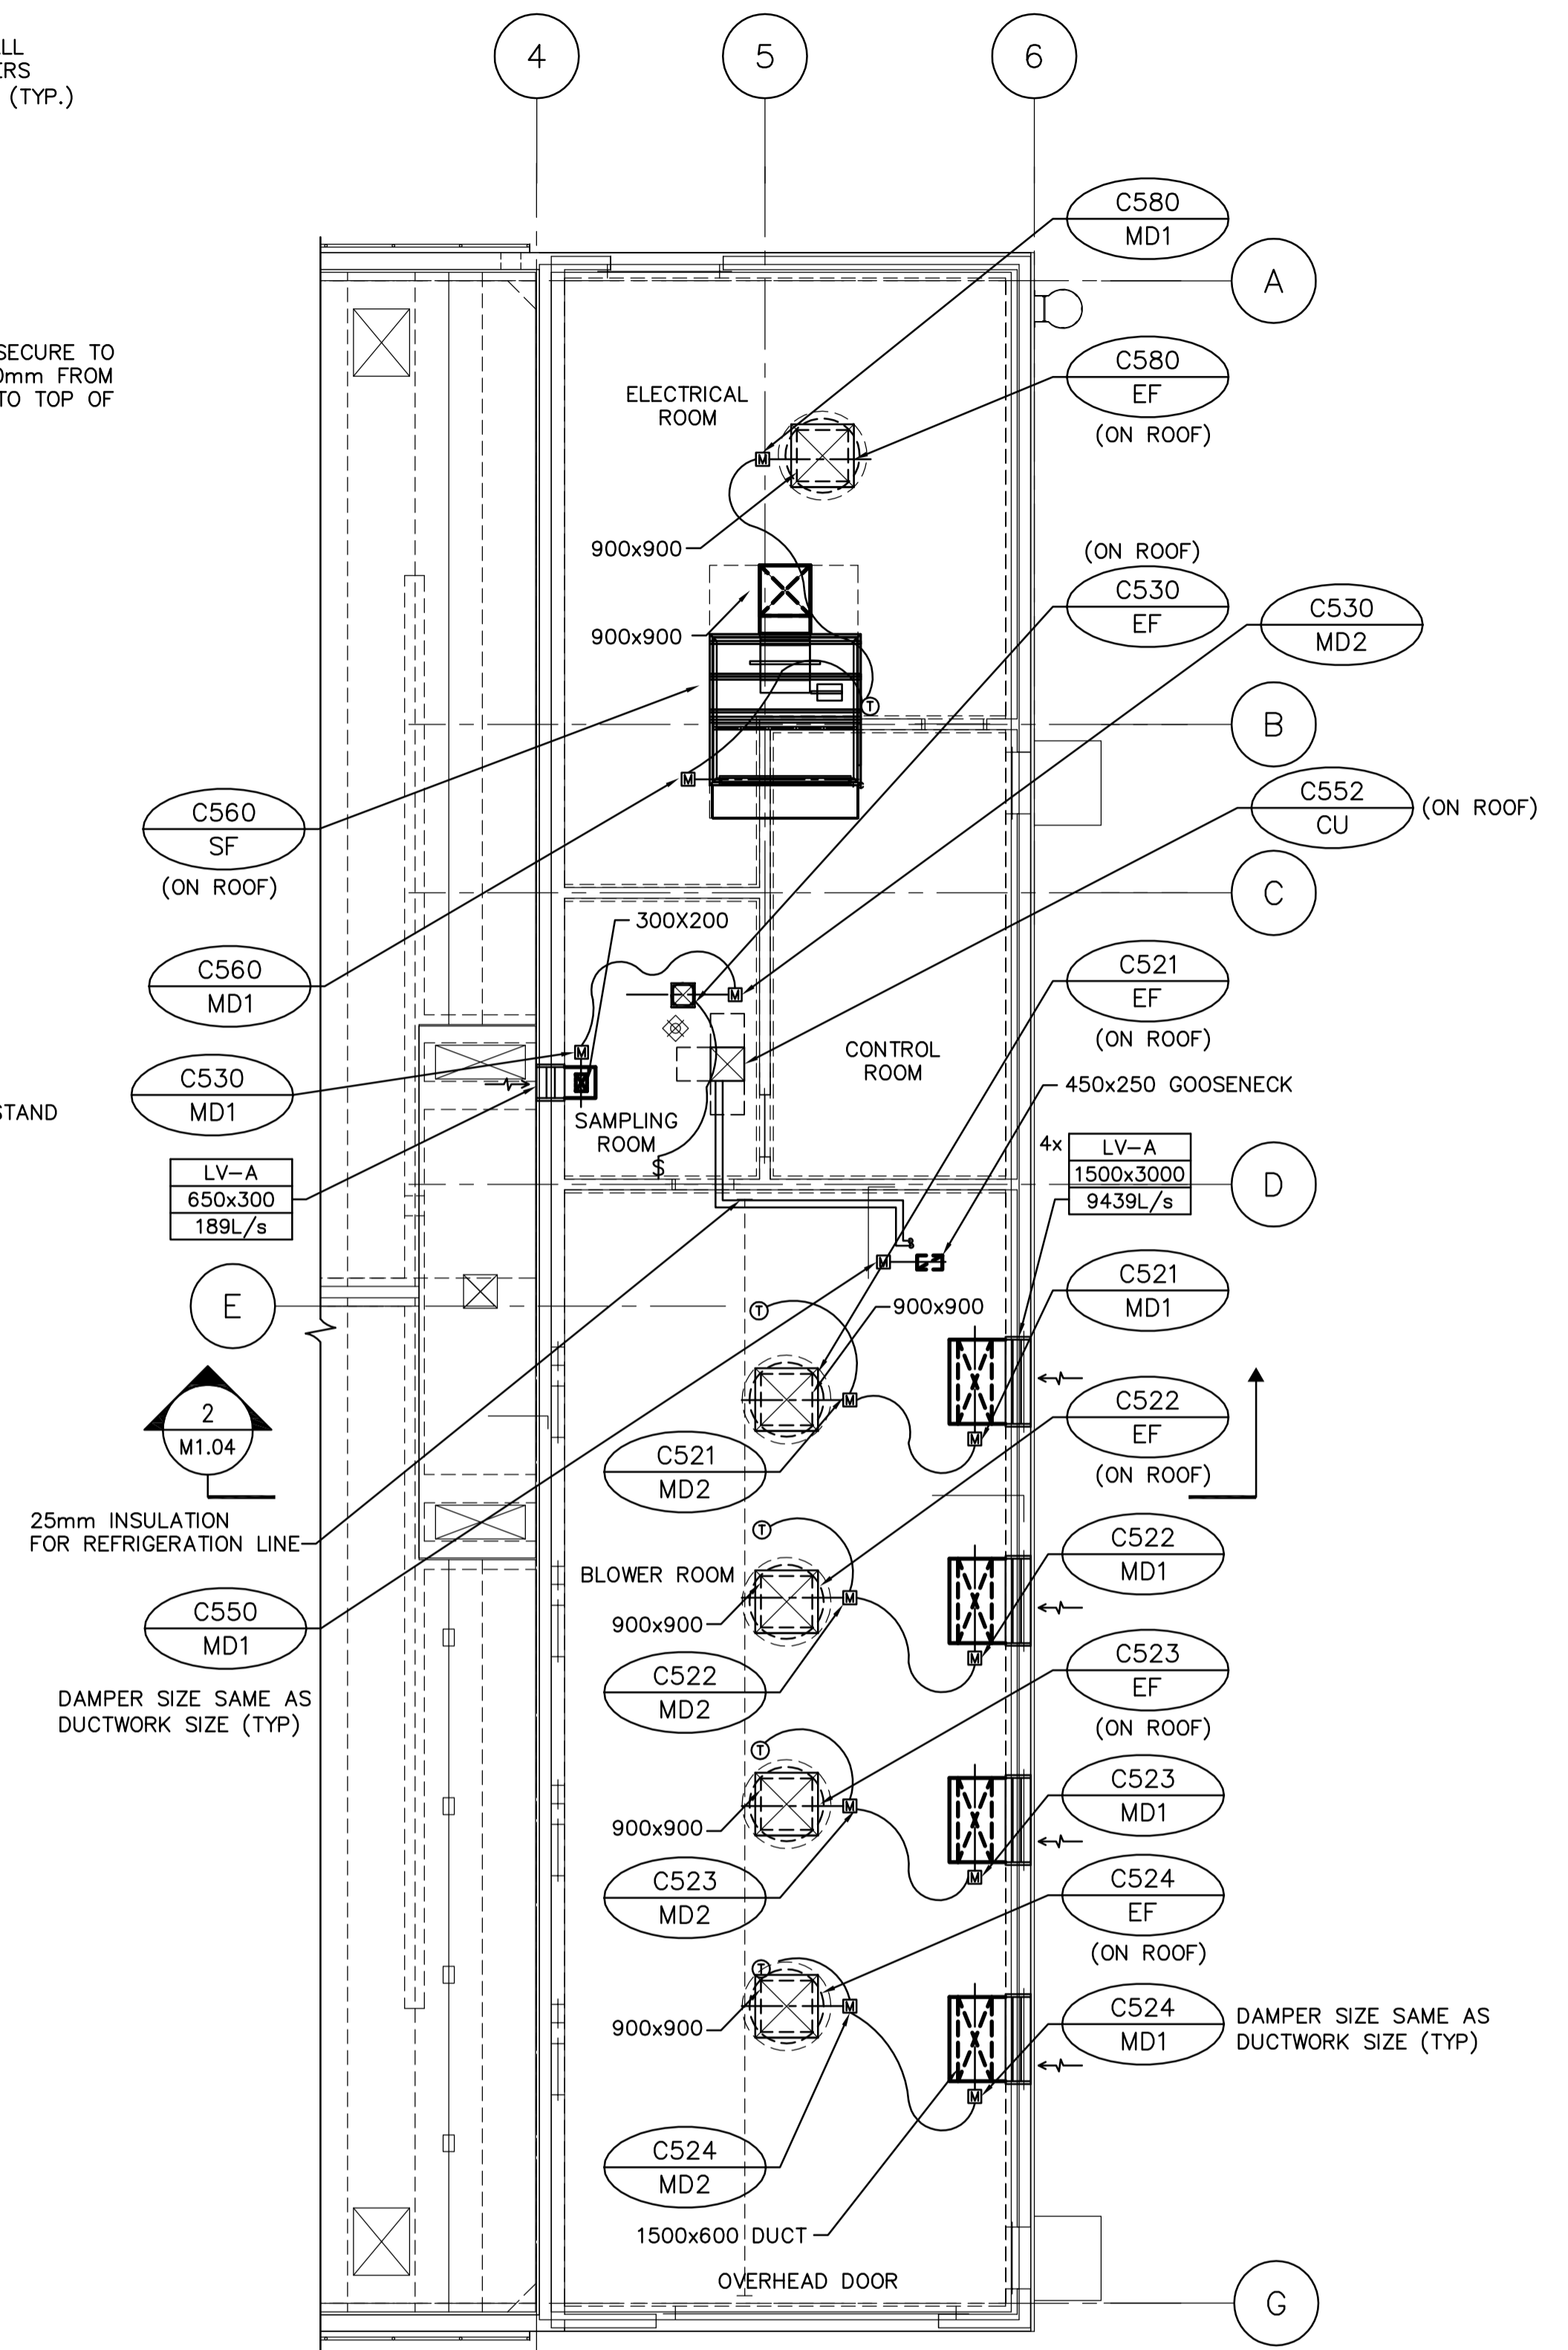

3 BLOWER BUILDING - HVAC ROOF & FLOOR PLAN
M1.02 SCALE 1:100

APEGM
Certificate of Authorization
Earth Tech Canada Inc.
No. 730 Expiry: April 30, 2007

| | |
|-------------------------------|------------|
| B.M. ELEV. | |
| DESIGNED BY | AB |
| CHECKED BY | AB |
| DRAWN BY | DJP |
| APPROVED BY | JEH |
| SCALE: | AS NOTED |
| RELEASED FOR CONSTRUCTION BY: | K. MARTENS |
| DATE | 2006/05/15 |
| DATE | 2006/05/15 |
| ISSUED FOR TENDER | 06/05/15 |
| NO. REVISIONS | DATE BY |

EarthTech
A Tyco International Ltd. Company

| | | | |
|-------------------------------|------------|-------------|------------|
| DESIGNED BY | AB | CHECKED BY | AB |
| DRAWN BY | DJP | APPROVED BY | JEH |
| SCALE: | AS NOTED | | |
| RELEASED FOR CONSTRUCTION BY: | K. MARTENS | | |
| DATE | 2006/05/15 | DATE | 2006/05/15 |

ENGINEER'S SEAL
ORIGINAL SIGNED BY
A. BURACHYNSKY
2006/05/15
CONSULTANT DRAWING NO.
M1.02

THE CITY OF WINNIPEG
WATER AND WASTE DEPARTMENT
ENGINEERING DIVISION

NEWPCC CENTRATE NUTRIENT TREATMENT
NITROGEN REMOVAL FACILITY

CITY FILE NUMBER
SHEET OF
CITY DRAWING NUMBER

MECHANICAL
BLOWER BUILDING AND EXHAUST FAN BUILDING
HVAC PLANS