


FOLEY AV

FOLEY AV

GIBBS ST

HIGHLAND AV

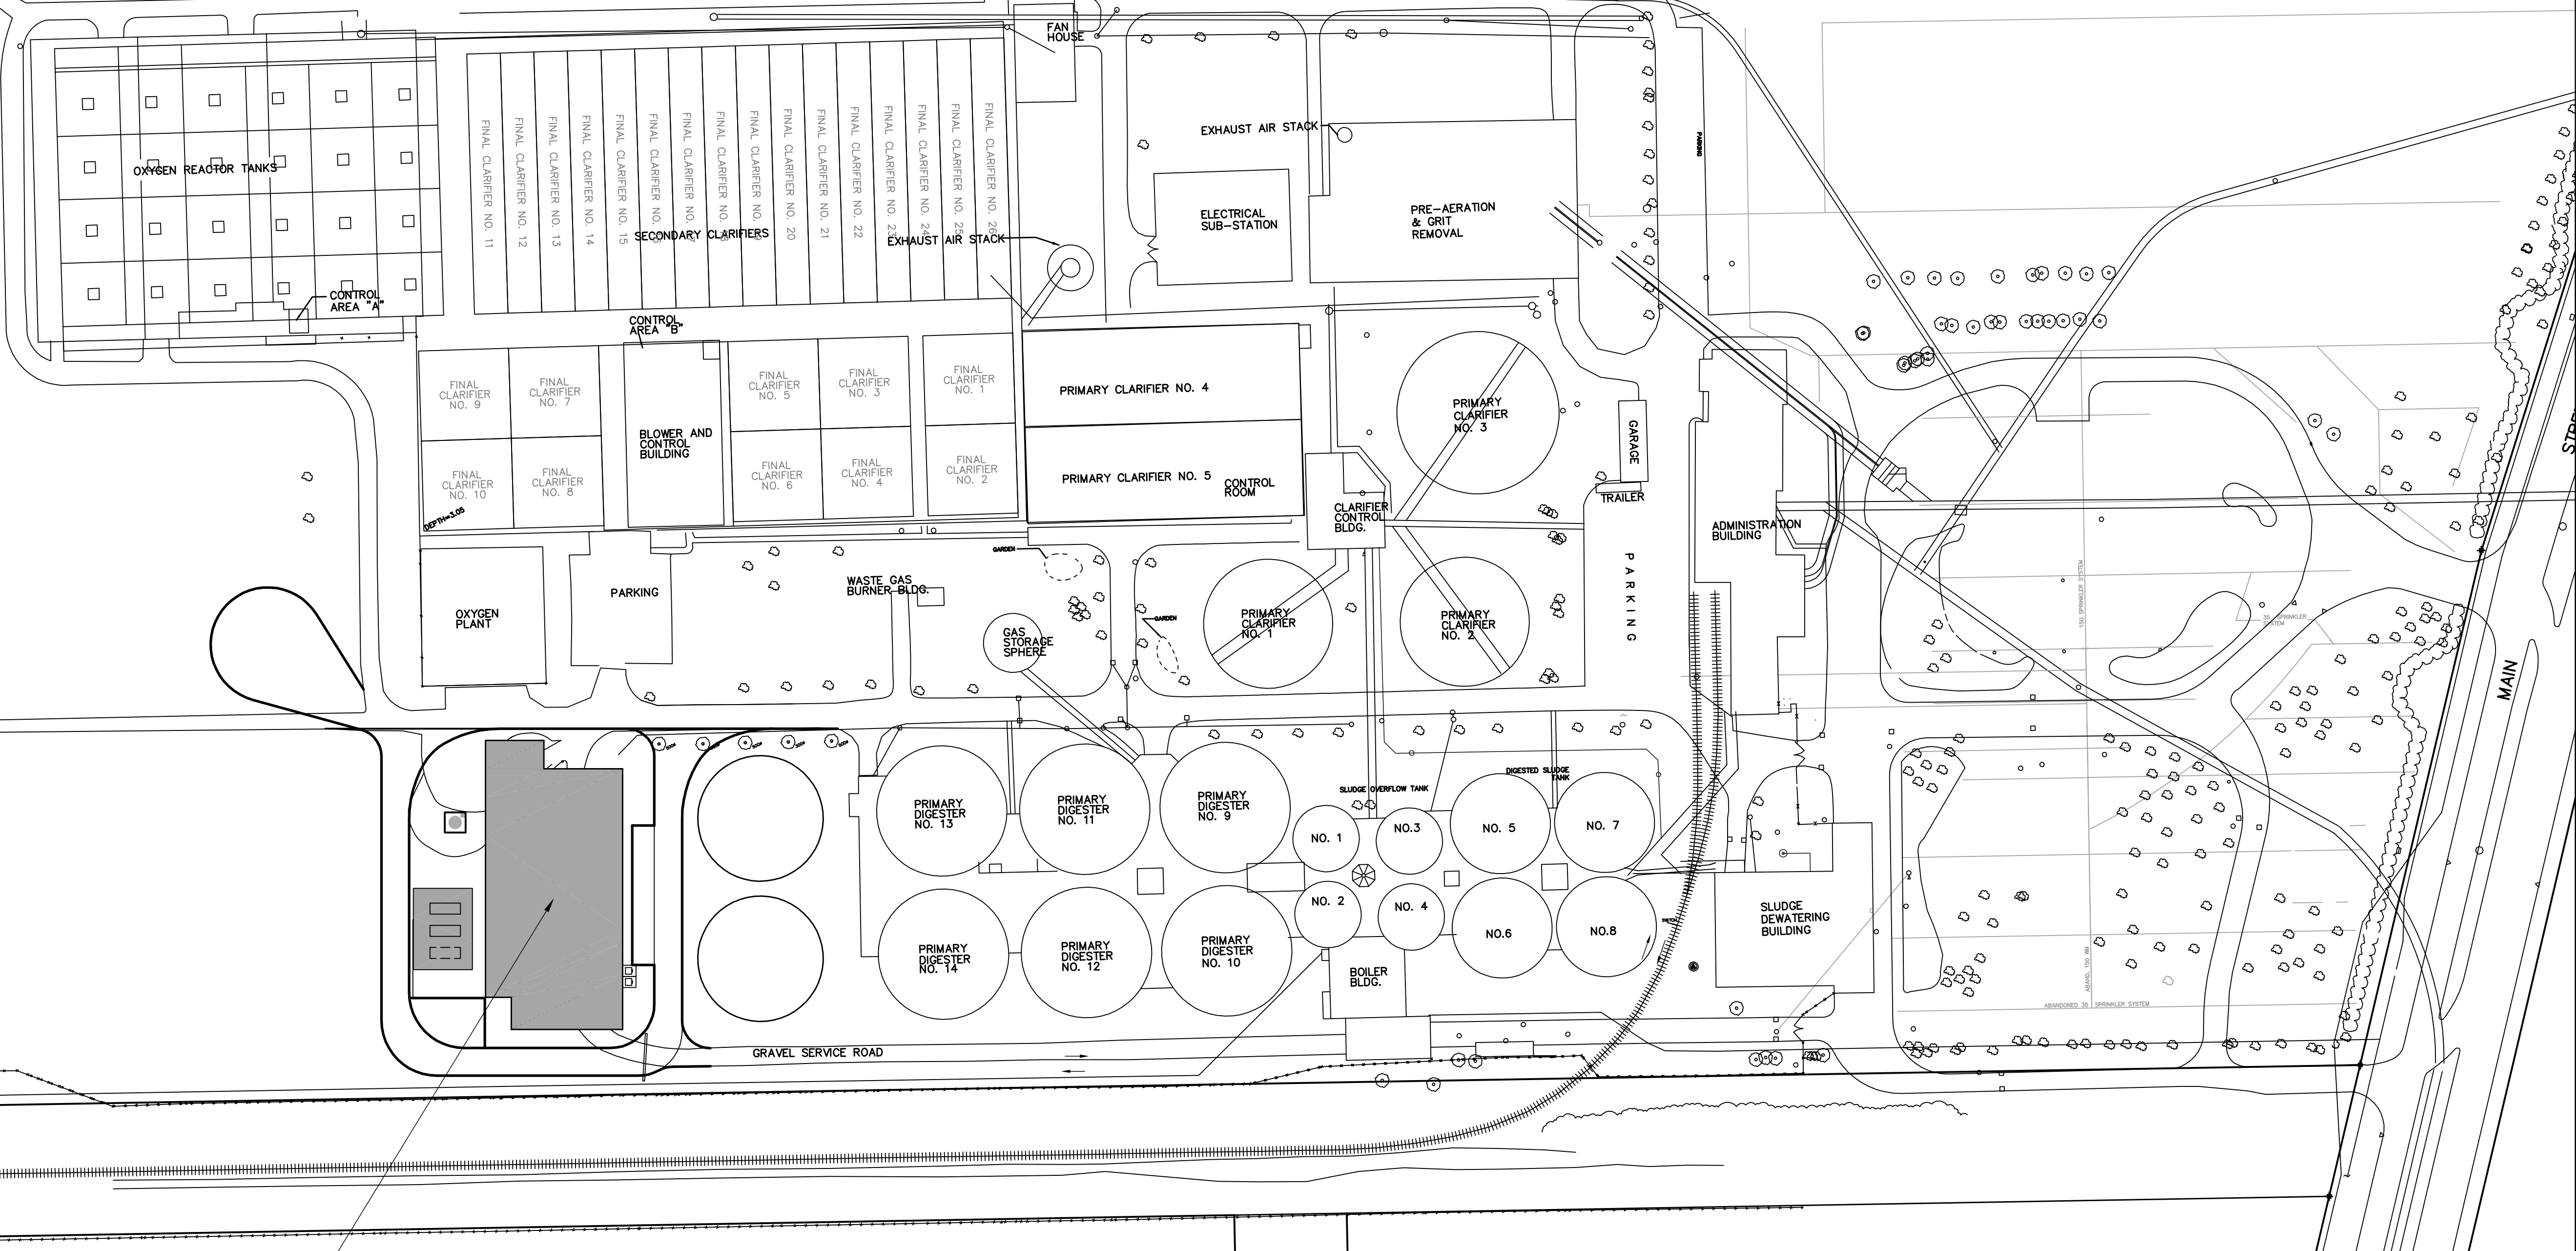

CENTRATE NITROGEN REMOVAL FACILITY

**SITE PLAN**  
SCALE 1:1000

NO.	REVISIONS	DATE	BY
B	ISSUED FOR REVIEW	06/02/24	SRP
A	ISSUED FOR CLIENT REVIEW	06/01/26	SRP

<p>A Tyco International Ltd. Company</p>	
DESIGNED BY: EM	CHECKED BY: SB
DRAWN BY: GLG	APPROVED BY:
SCALE: 1:1000	RELEASED FOR CONSTRUCTION BY:
DATE: 2005/09/30	DATE:

ENGINEER'S SEAL
<b>PRELIMINARY</b>
NOT FOR CONSTRUCTION
CONSULTANT DRAWING NO. D1.01

**THE CITY OF WINNIPEG**  
Winnipeg WATER AND WASTE DEPARTMENT  
ENGINEERING DIVISION

NEWPCC CENTRATE NUTRIENT TREATMENT  
NITROGEN REMOVAL FACILITY  
SUPPLY OF DECANTERS

GENERAL SITE PLAN

CITY FILE NUMBER  
SHEET OF  
CITY DRAWING NUMBER