





NOTES :

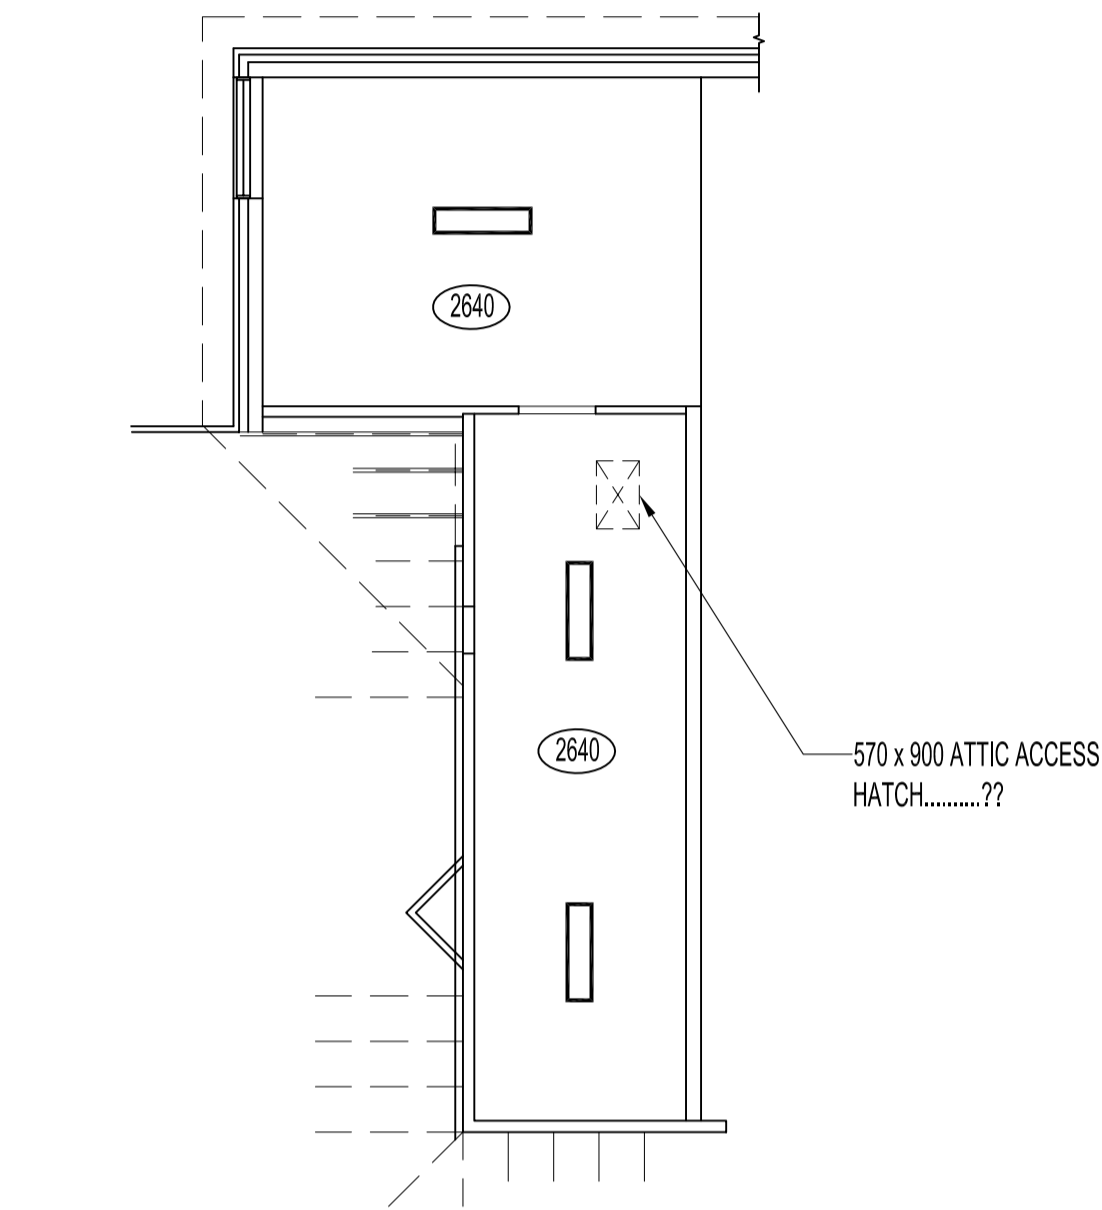

1 MEZZANINE FLOOR PLAN - REFLECTED CEILING
A5 SCALE 1:100

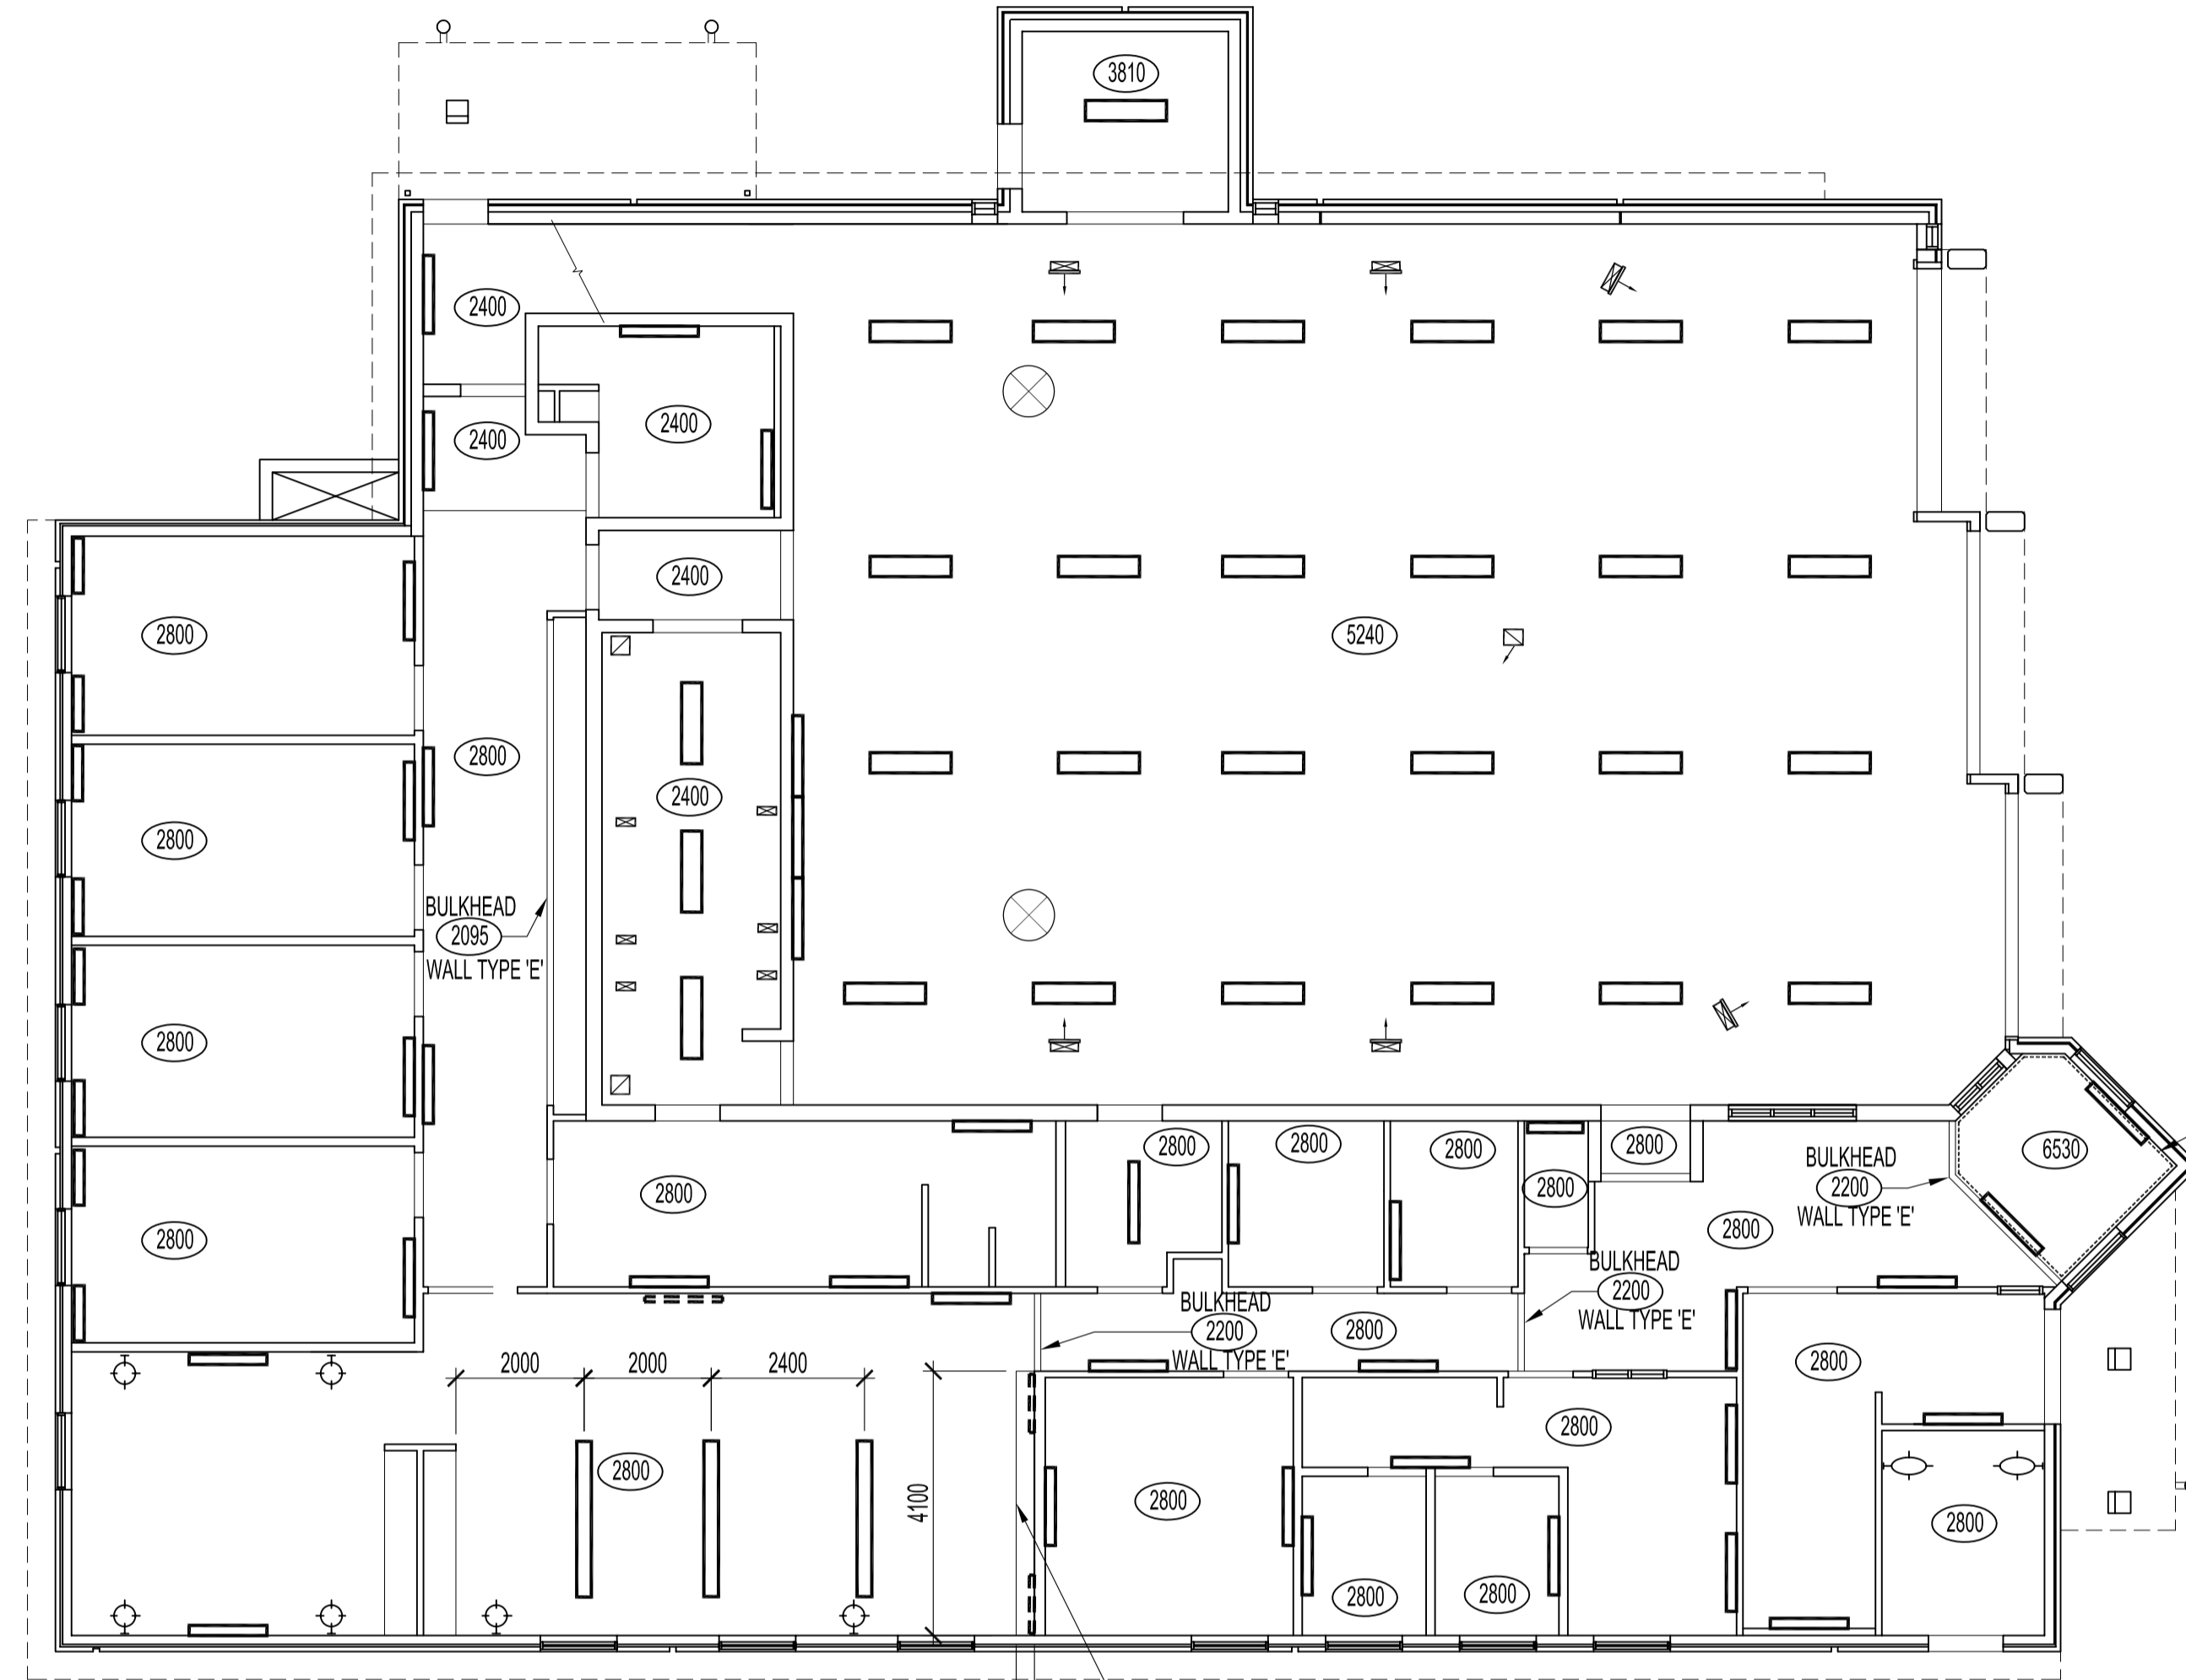

2 MAIN FLOOR PLAN - REFLECTED CEILING
A5 SCALE 1:100

ACOUSTICAL PANELS
BELOW LIGHTING
FIXTURES -SEE
FURNITURE & MILLWORK
DWG.

ORIGINAL STAMPED BY: R. K. FOK LI Arch.
DATE: 2006.07.18

CEILING LEGEND	
	CEILING HEIGHT
	WALL MOUNTED LIGHT FIXTURES
	WALL MOUNTED LIGHT FIXTURES (SCONCES)
	RECESSED CEILING LIGHT FIXTURES
	150 x 860 WALL MOUNTED FLUORESCENT LIGHT FIXTURES
	100 x 914 WALL MOUNTED (UNDER CABINETS) FLUORESCENT LIGHT FIXTURES
	100 x 1219 WALL MOUNTED (UNDER CABINETS) FLUORESCENT LIGHT FIXTURES
	150 x 1200 WALL MOUNTED FLUORESCENT LIGHT FIXTURES
	150 x 1200 CEILING MOUNTED FLUORESCENT LIGHT FIXTURES
	150 x 1200 T8 WALL MOUNTED LAMP FIXTURES
	300 x 1200 FLUORESCENT LIGHT FIXTURES
	230 x 2400 T8 SUSPENDED LAMP FIXTURES
	AIR SUPPLY GRILLES
	EXHAUST /RETURN GRILLES
	CEILING FAN

NO.	REVISION/DESCRIPTION	BY	DATE
SEALS			

DRAWN BY	CHECKED BY	APPROVED
MMK		
DATE	2006.07.10	USER APPROVAL

CITY OF WINNIPEG
PLANNING, PROPERTY &
DEVELOPMENT DEPARTMENT
CIVIC ACCOMMODATIONS DIVISION
300 - 65 GARRY ST. R3C 4K4

PROJECT
WEST TRANSCONA
FIRE PARAMEDIC STATION 21

1446 REGENT AVENUE W.

SHEET TITLE
MAIN & MEZZANINE FLOOR PLANS
REFLECTED CEILING

METRIC
WHOLE NUMBERS ARE IN MILLIMETRES,
DECIMALIZED NUMBERS ARE IN METRES

SCALE	PROJECT NO.	SHEET NO.
AS SHOWN	2004-058	A5