
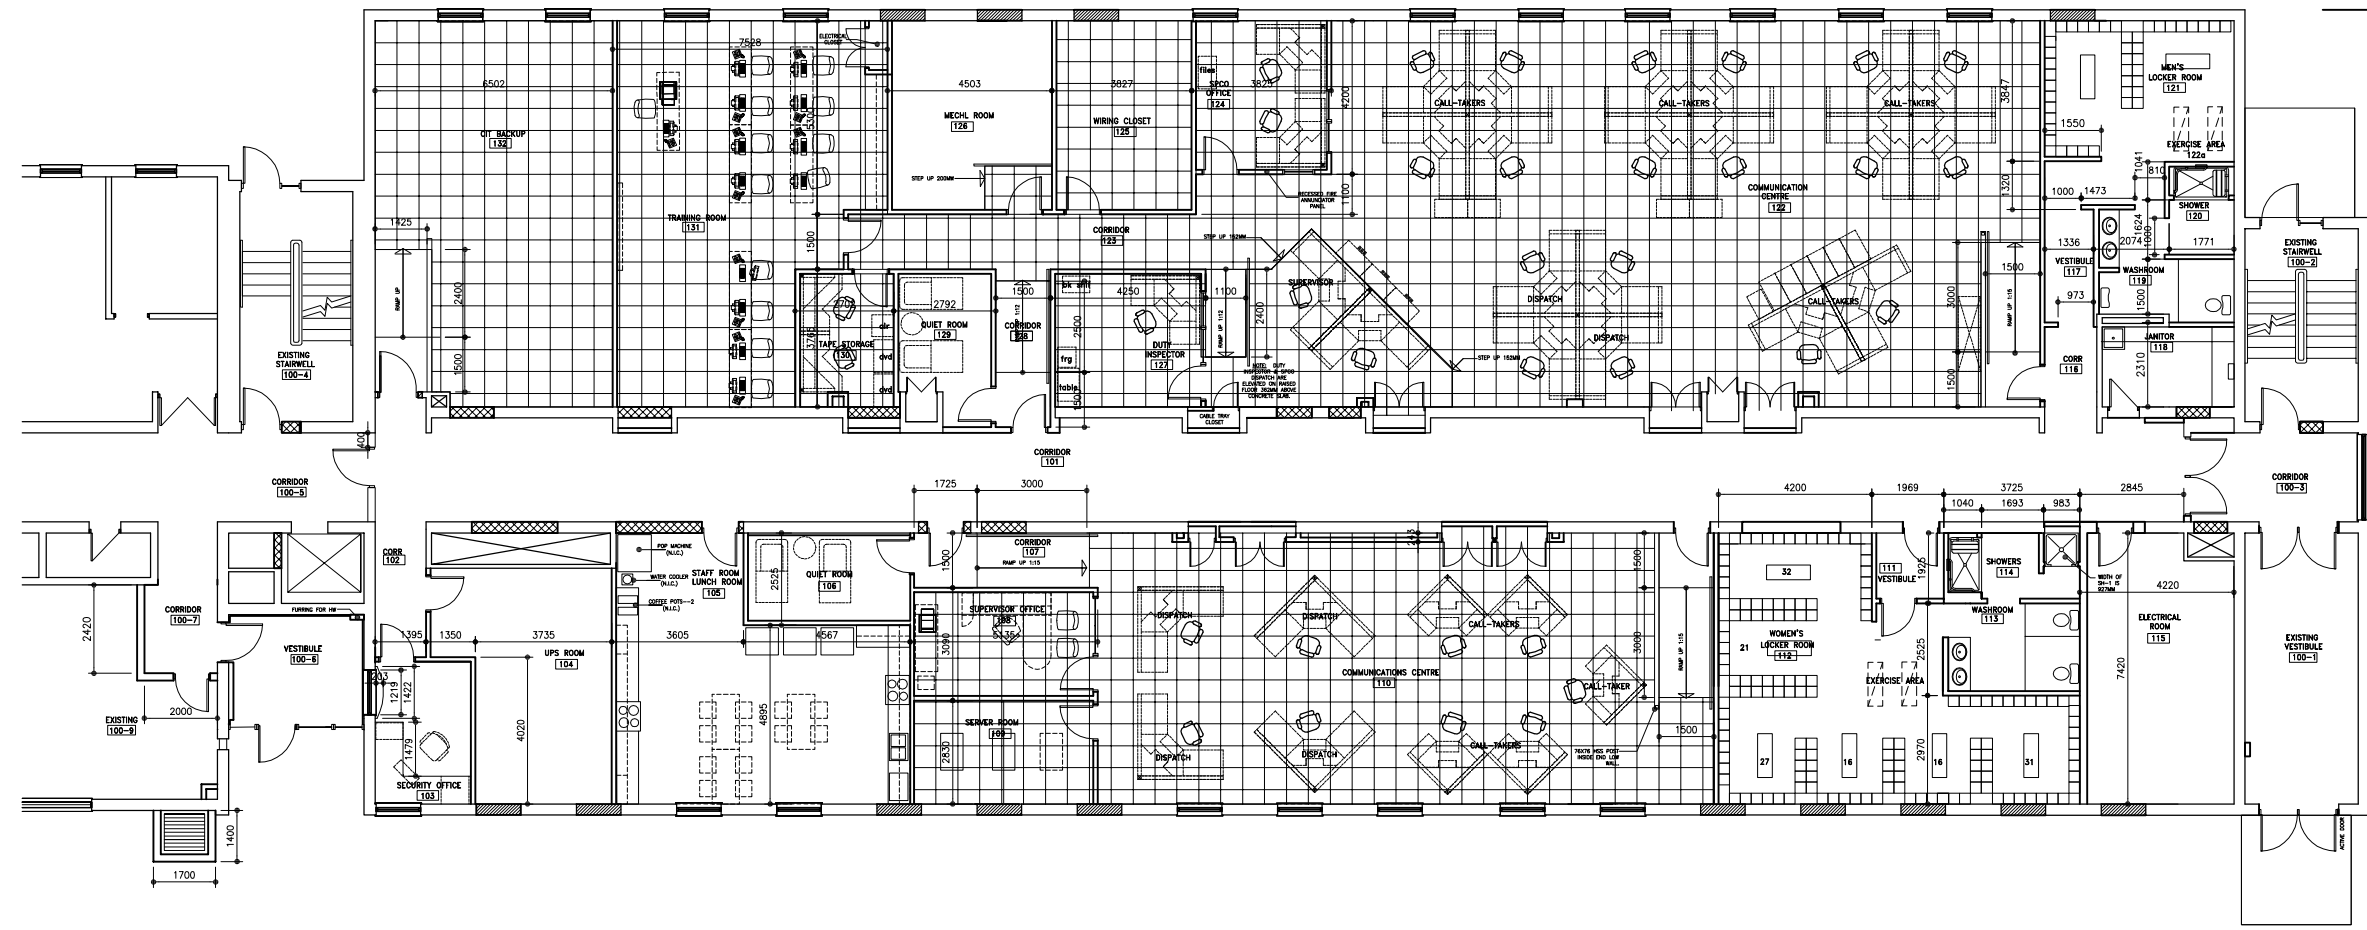
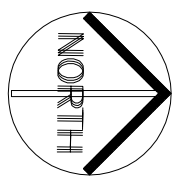


Note:  
The floor grid for this drawing A-4r is  
600 mm X 600 mm per each square.

| No. | REVISION ISSUED PLOTTED | DATE |
|-----|-------------------------|------|
| 1   |                         |      |
| 2   |                         |      |
| 3   |                         |      |
| 4   |                         |      |
| 5   |                         |      |
| 6   |                         |      |

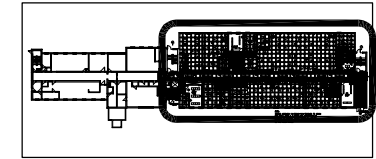

Police  
Service  
Department

Fire  
Paramedic  
Service  
Department

1  
A-4  
MAIN FLOOR PLAN

POLICE / FIRE / PARAMEDIC / CIT  
ALT COMMUNICATION CENTRES

700 ASSINBOINE PARK DR, CITY OF WINNIPEG

project

MAIN FLOOR PLAN  
REFLECTED CEILING PLAN

sheet title

consulting engineer

architectural seal

drawn by:

checked by:

project no. 04136

scale: 1:100

date: SEP 30, 2005

sheet no.

A-4r