



1 PLAN AT EL 228.35
WY-H0402 1:50

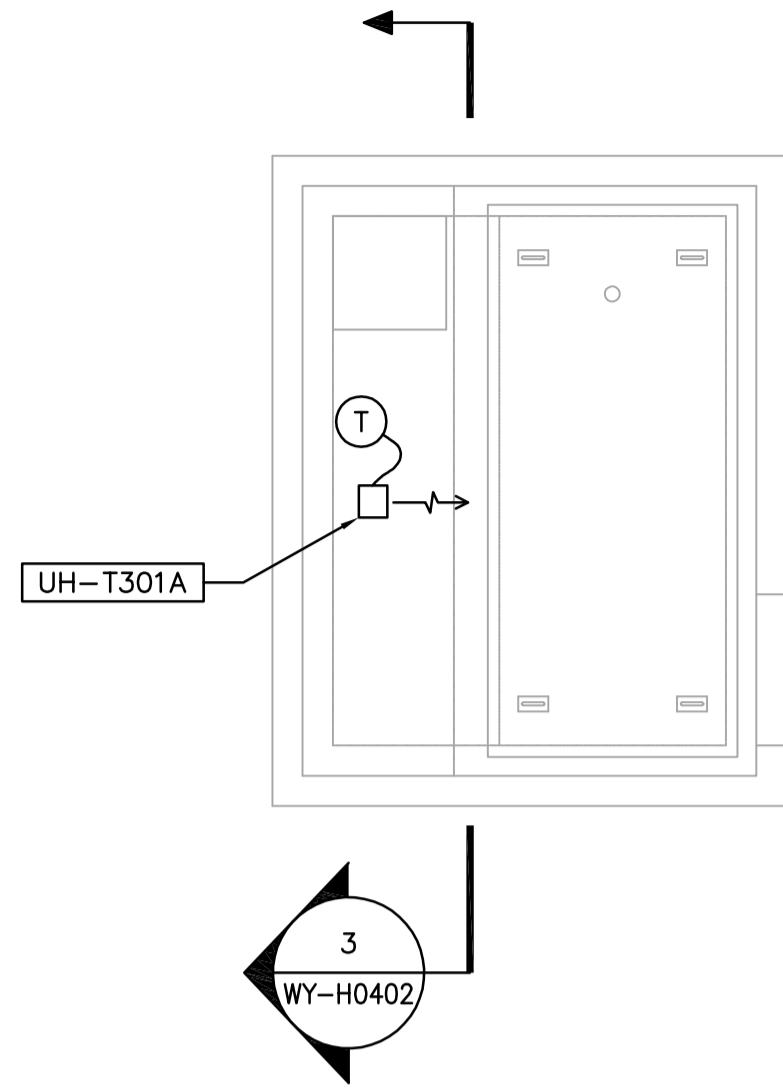


1 MAIN FLOOR PLAN
WY-H0402 1:50

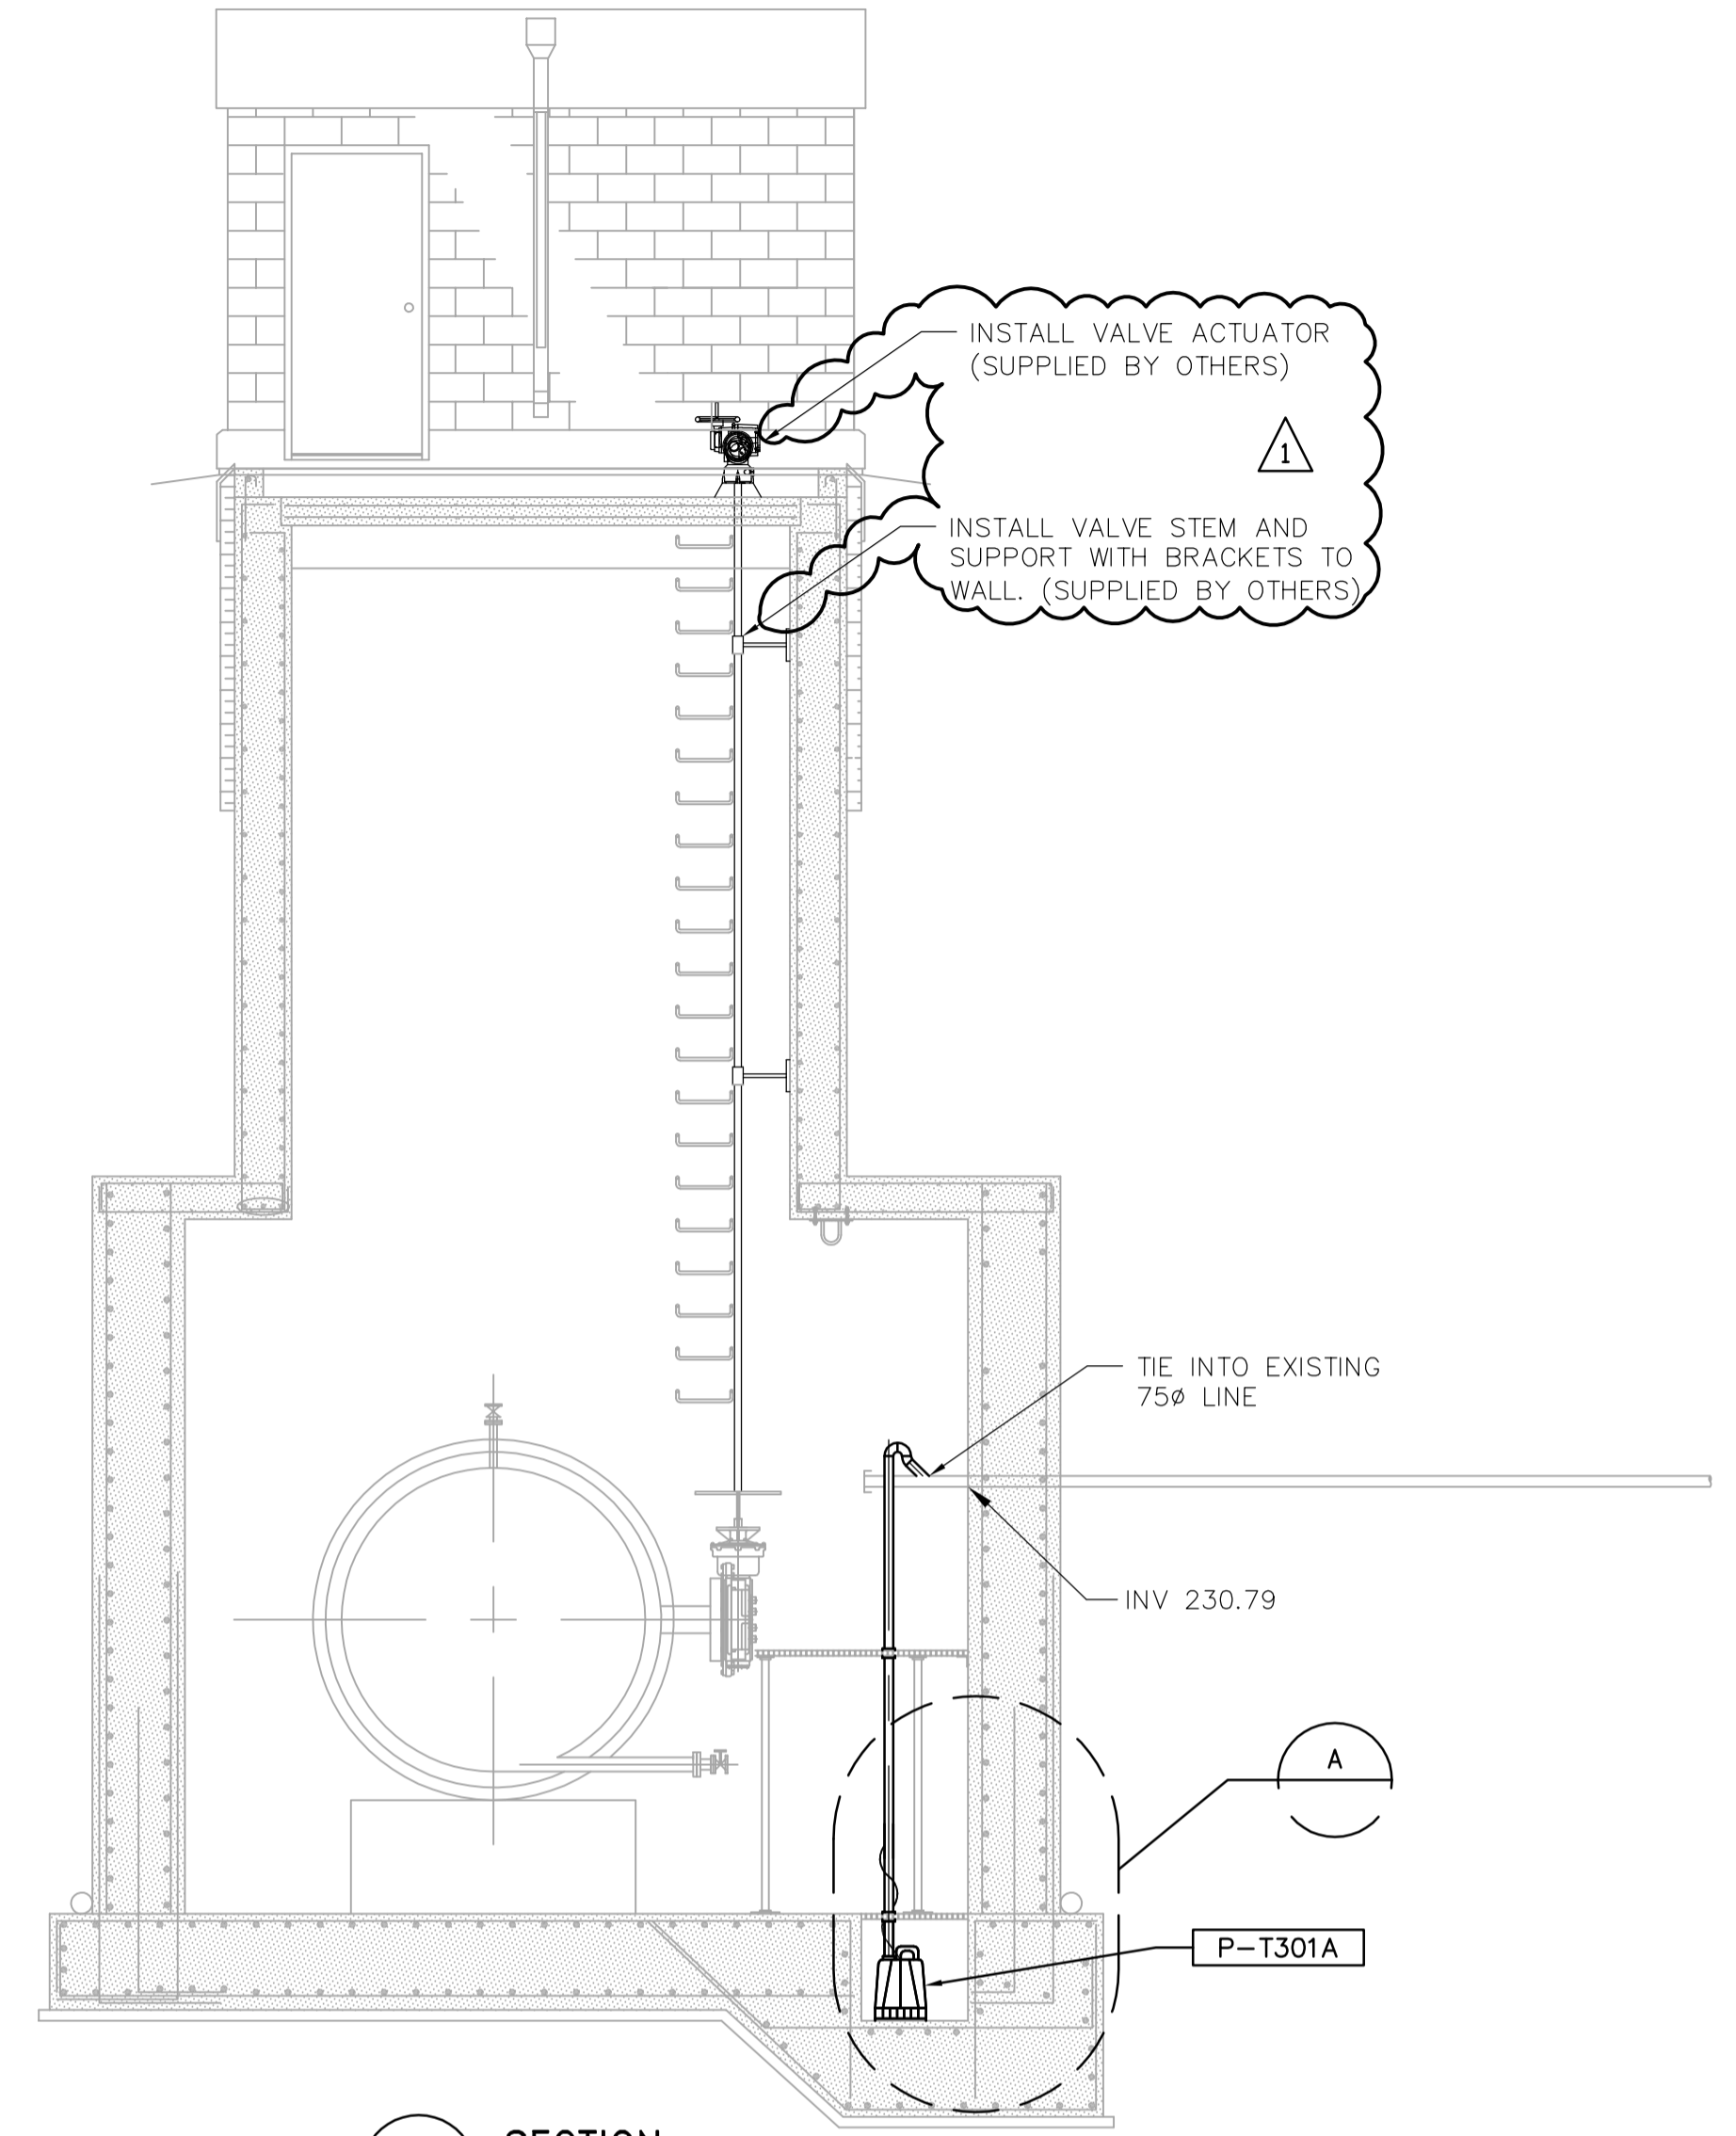

3 SECTION
WY-H0402 1:50

**CELL 1 TREATED WATER
VALVE CHAMBER**

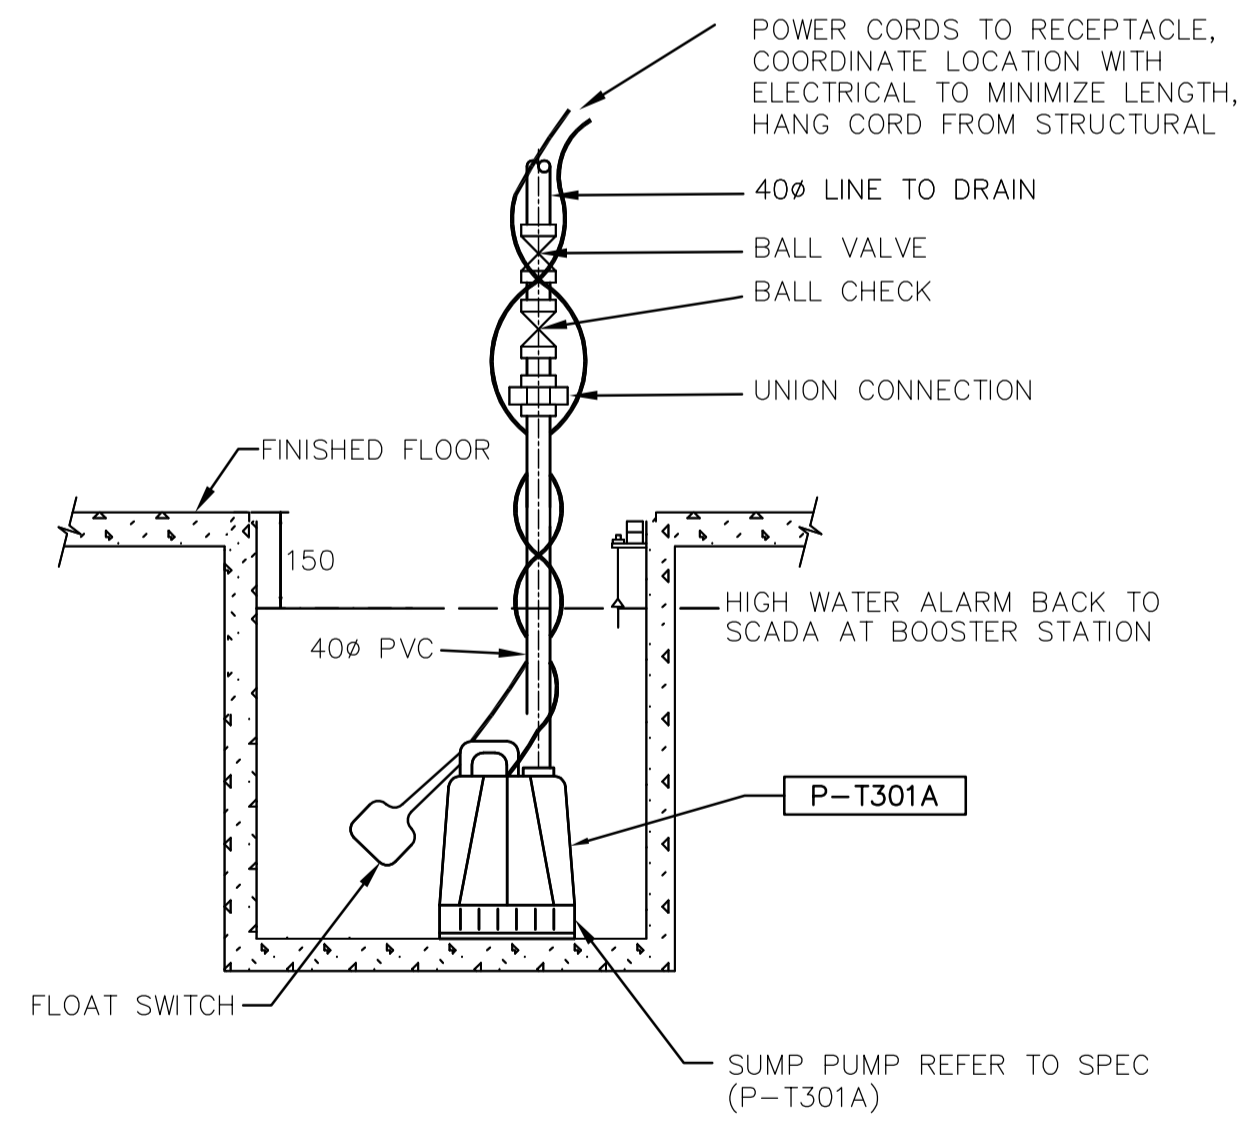

A SUMP PUMP DETAIL
NTS

<p>Certificate of Authorization Earth Tech Canada Inc. No. 730 Expiry: April 30, 2007</p>	B.M. ELEV.	<p>Frederickson Cooper ARCHITECTS</p>	<p>A Type International Ltd. Company</p>	ENGINEER'S SEAL	<p>THE CITY OF WINNIPEG WATER AND WASTE DEPARTMENT ENGINEERING DIVISION</p>	CITY FILE NUMBER		
				DESIGNED BY DC		CHECKED BY AB	ORIGINAL SIGNED BY	SHEET OF
				DRAWN BY DJ		APPROVED BY AHL	2006/08/30	
				SCALE: AS NOTED		RELEASED FOR CONSTRUCTION BY: R. SOROKOWSKI	CONSULTANT DRAWING NO. WY-H0402	CITY DRAWING NUMBER 1-0601Y-A-H0402-001-01D
	NO. REVISIONS	DATE	BY	DATE				
	01 498-2006 ADDENDUM 8	06/10/23	DC					
	00 ISSUED FOR TENDER	06/08/28	DC					