



COLOR LEGEND

HYDRO LINE (OVERHEAD)	---
HYDRO LINE (UNDERGROUND)	—
GAS LINE	— · — · — ·

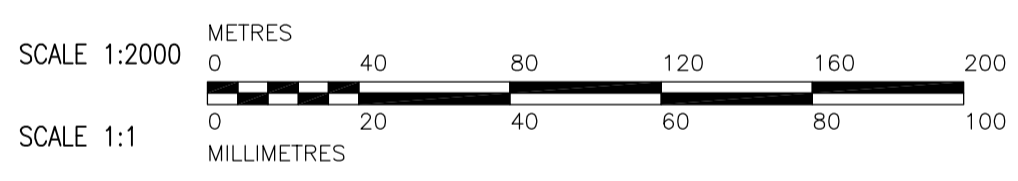

- MANITOBA HYDRO POINT OF SERVICE
- 2PR 24AWG TELEPHONE CABLE FOR PRIMARY METERING DIRECT BURIED. SEPARATE CABLE FOR TWO (2) MANITOBA HYDRO METERS LOCATED AT THE POINTS OF SERVICE
- SUPPLY AND INSTALL SCH 120 STEEL PIPE SLEEVES UNDER RAIL FOR TELEPHONE CABLE
- EXISTING MTS SERVICE PEDESTAL

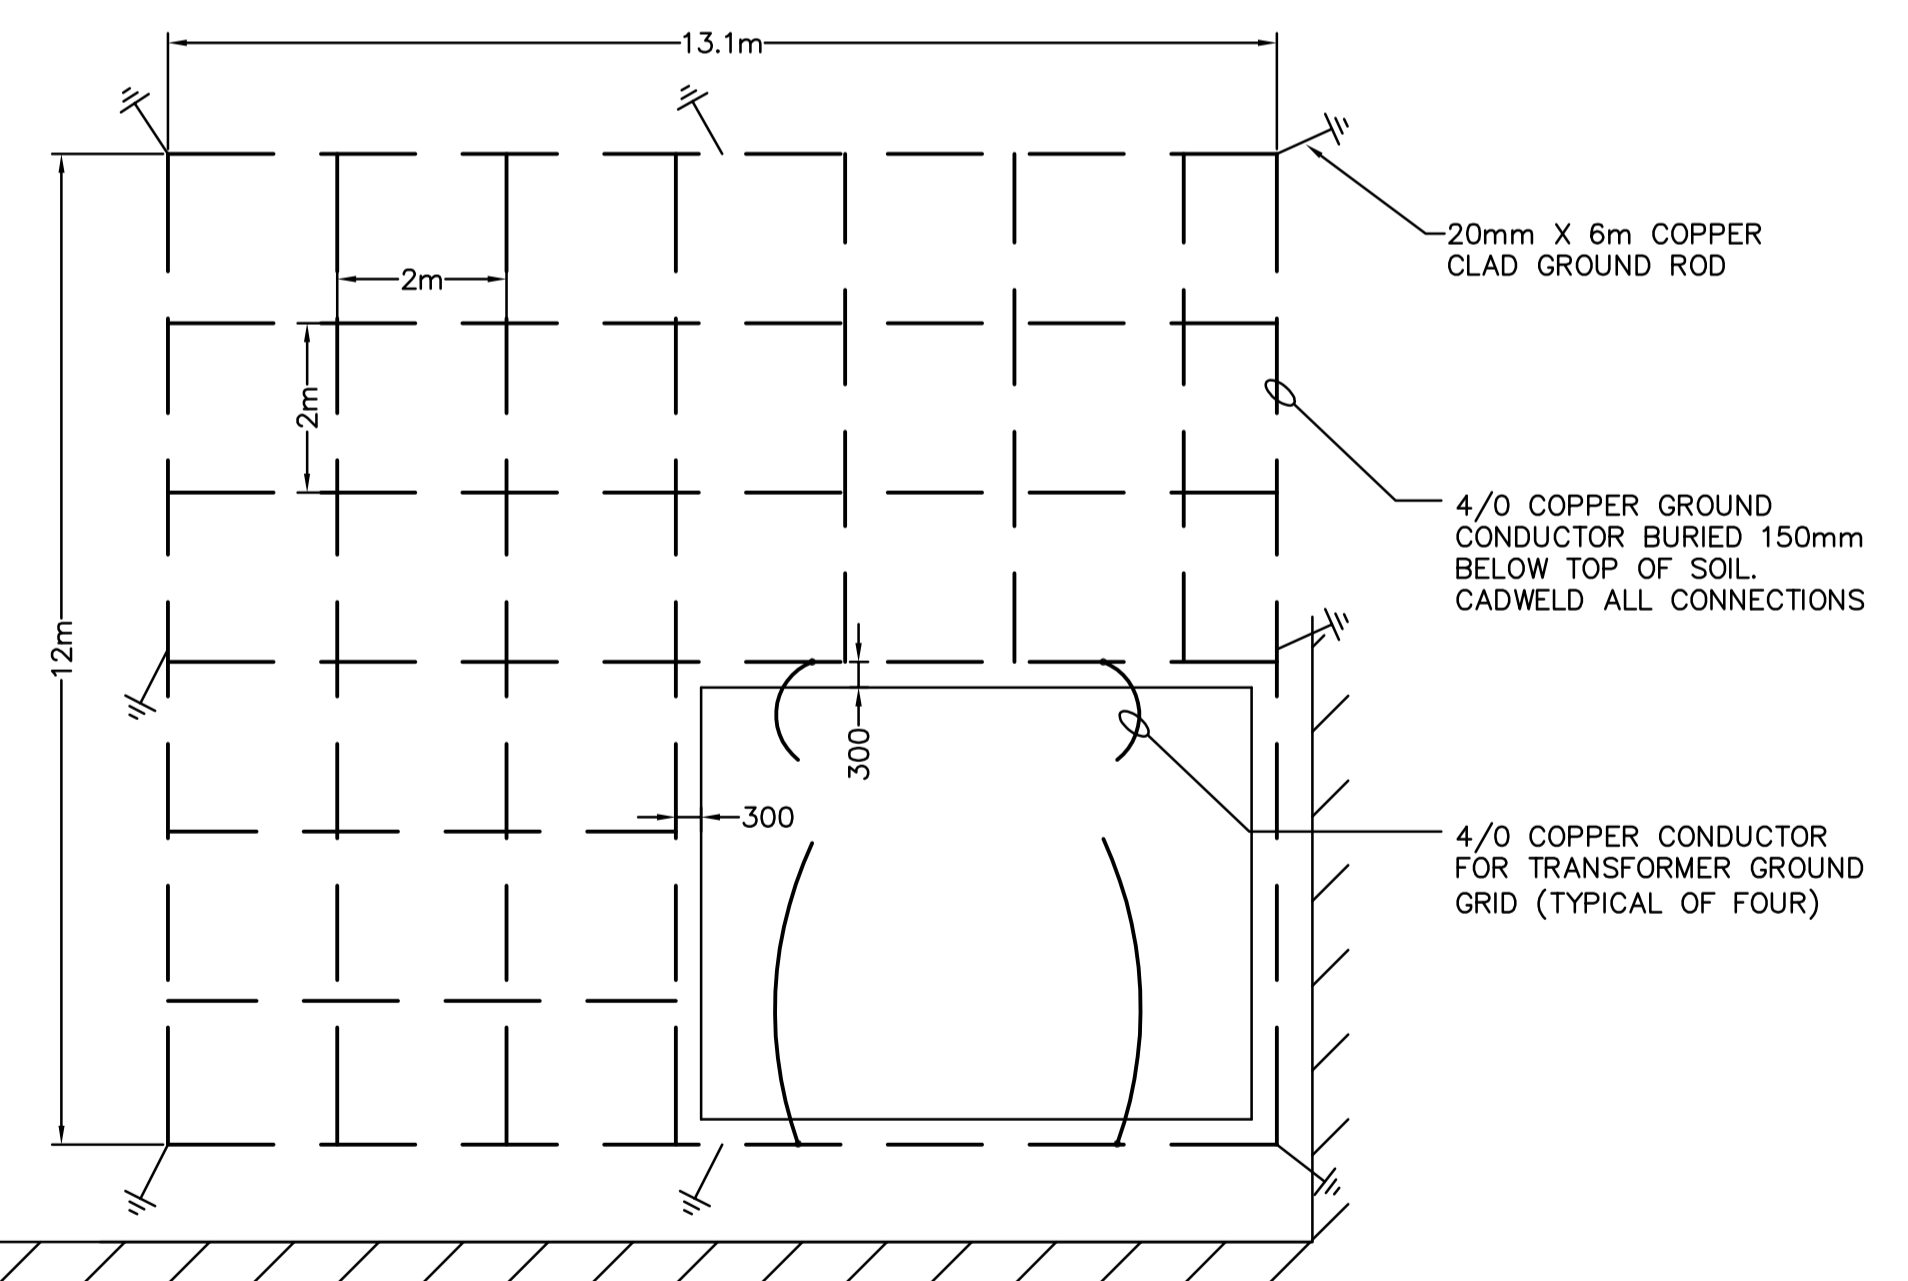

B DETAIL - WTP 4160/600V TRANSFORMER GROUND GRID
 WG-E0001 NTS

 Certificate of Authorization Earth Tech Canada Inc. No. 730 Expiry: April 30, 2007	B.M. ELEV.	 Frederickson Cooper ARCHITECTS DESIGNED BY: BLM DRAWN BY: ERC SCALE: AS SHOWN	 A Type International Ltd. Company CHECKED BY: PS APPROVED BY: AHL RELEASED FOR CONSTRUCTION BY: R. SOROKOWSKI	ENGINEER'S SEAL	 THE CITY OF WINNIPEG WATER AND WASTE DEPARTMENT ENGINEERING DIVISION		
				DESIGNED BY: BLM		CHECKED BY: PS	ORIGINAL SIGNED BY: B.L. MOORE
				DRAWN BY: ERC		APPROVED BY: AHL	2006/08/30
				SCALE: AS SHOWN		RELEASED FOR CONSTRUCTION BY: R. SOROKOWSKI	CONSULTANT DRAWING NO. WG-E0003
	00 ISSUED FOR TENDER 06/08/30 ERC	DATE 2006/08/15	DATE 2006/08/30	WATER TREATMENT PLANT STANDBY POWER GENERATOR	CITY FILE NUMBER		
	NO. REVISIONS	DATE	DATE	ELECTRICAL SITE DETAILS	SHEET OF		
					CITY DRAWING NUMBER		
					1-0601-A-E0003-001-000		