




1 SOUTH ELEVATION
WG-B0301 1:100

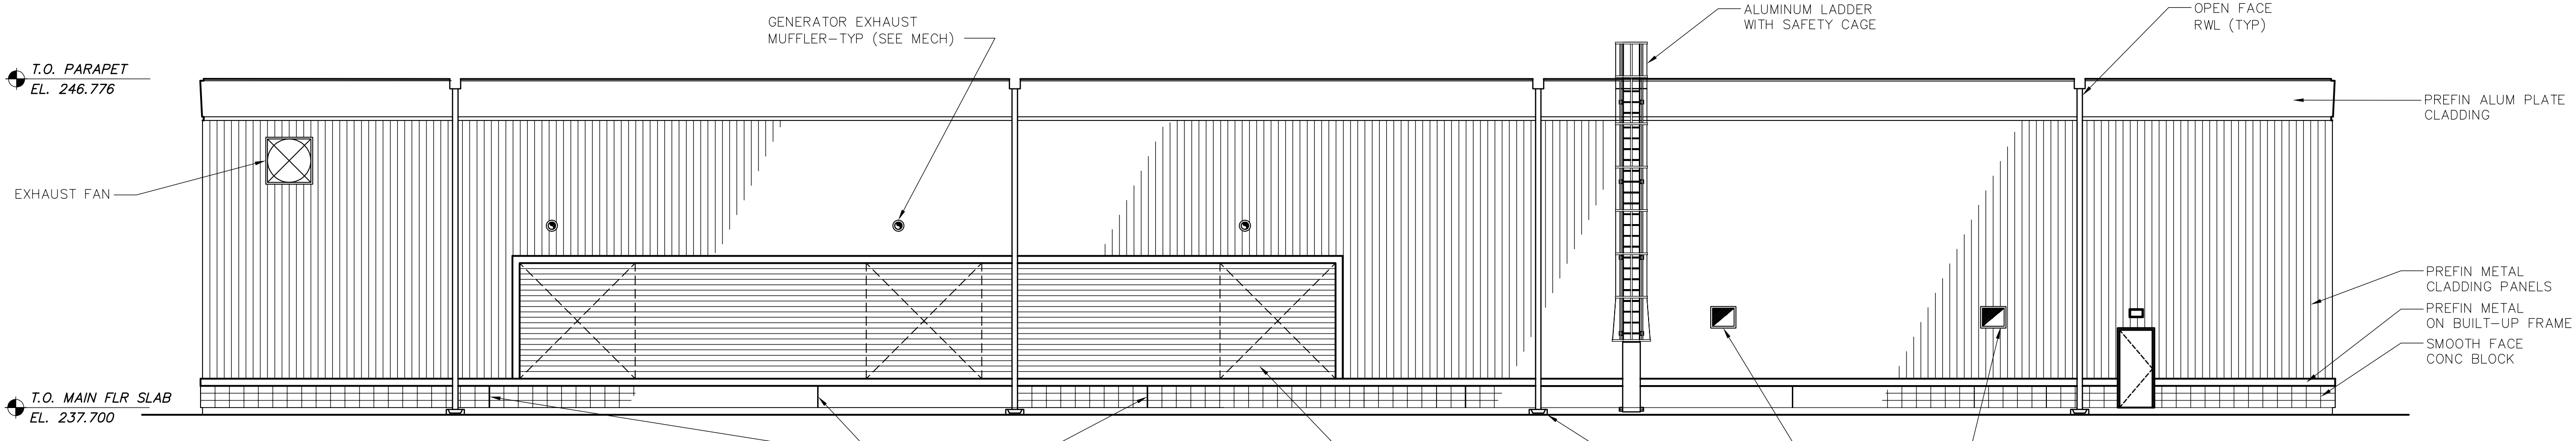

2 NORTH ELEVATION
WG-B0301 1:100

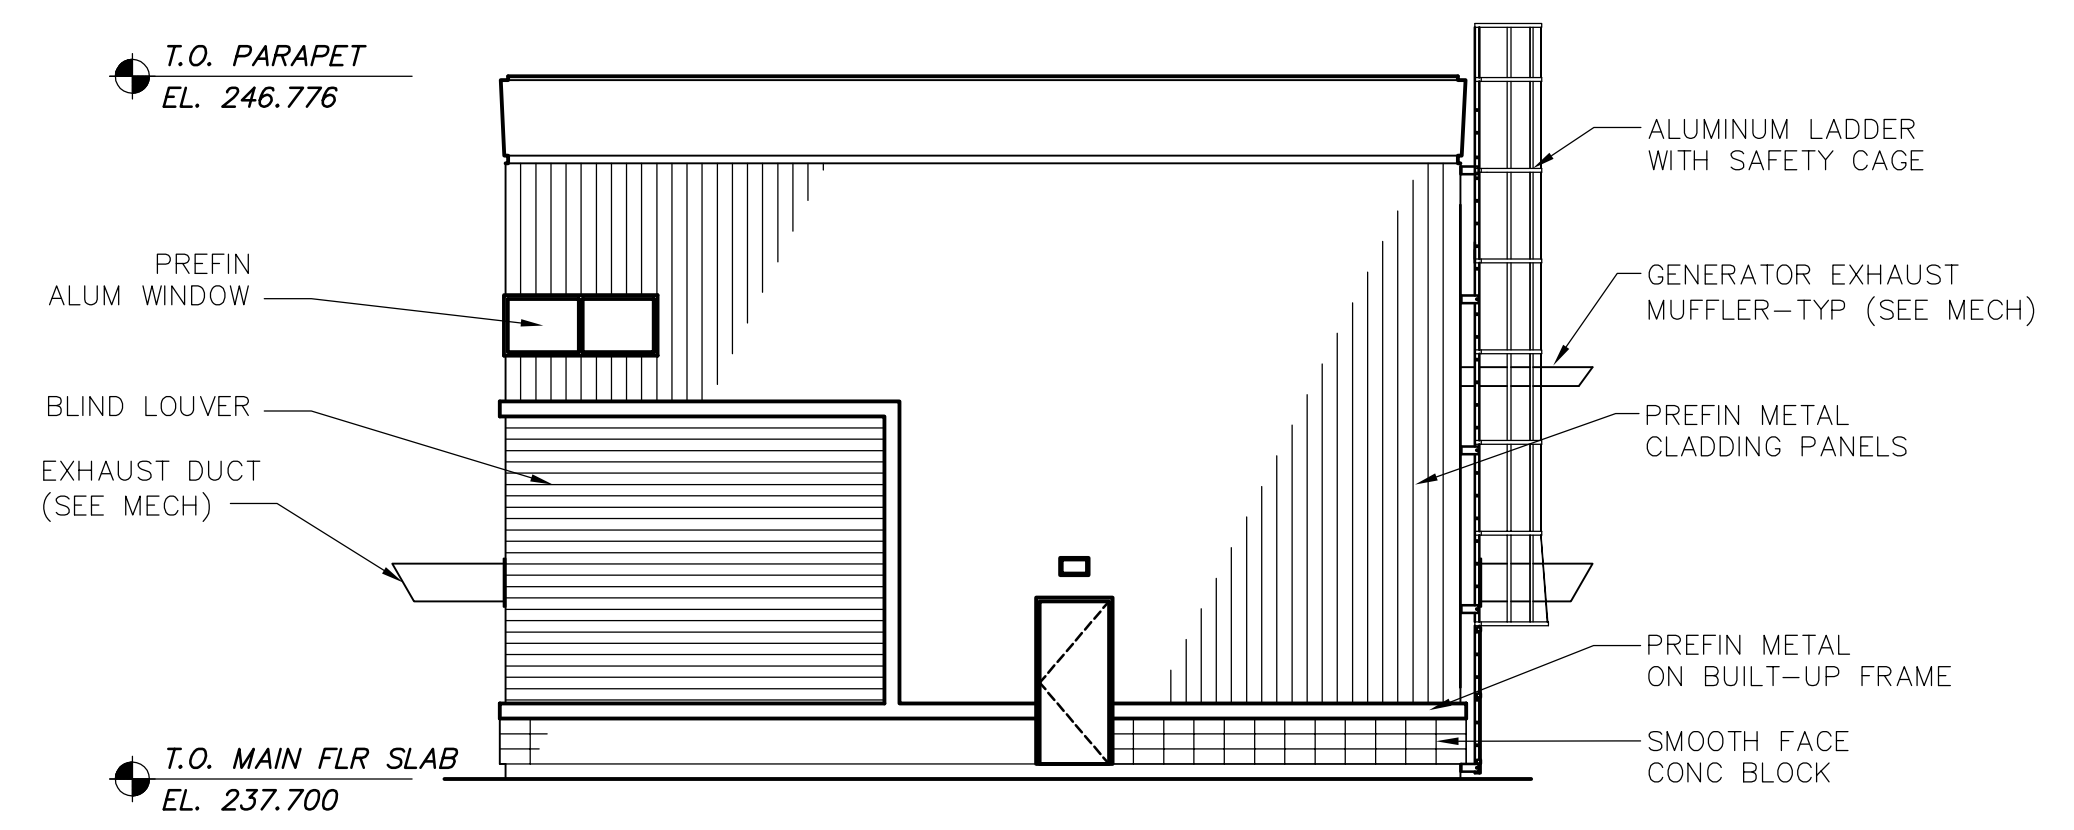

3 EAST ELEVATION
WG-B0301 1:100

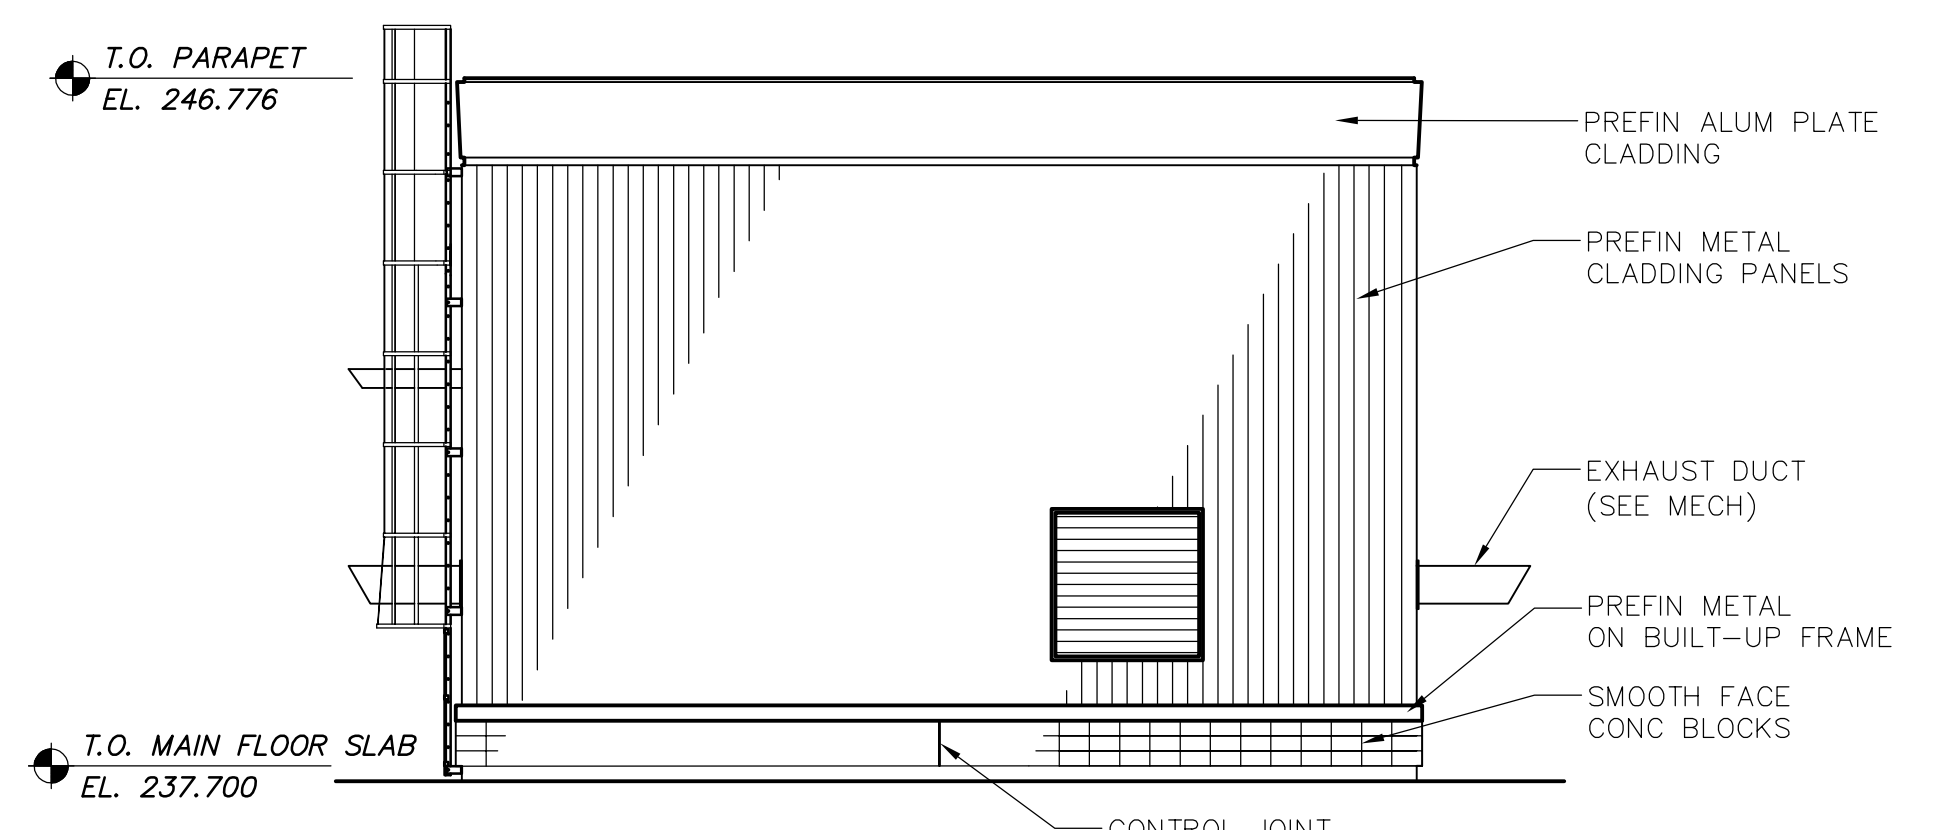

4 WEST ELEVATION
WG-B0301 1:100

B.M. ELEV. DESIGNED BY: NC DRAWN BY: AL SCALE: AS SHOWN 00 ISSUED FOR TENDER 06/08/28 AL NO. REVISIONS DATE BY DATE 2006/06/01 DATE 2006/08/30	CH2MHILL Frederickson Cooper ARCHITECTS EarthTech A Tyco International Ltd. Company R. SOROKOWSKI DATE 2006/08/30	ENGINEER'S SEAL ORIGINAL SIGNED BY N. COOPER 2006/08/30	THE CITY OF WINNIPEG WATER AND WASTE DEPARTMENT ENGINEERING DIVISION WATER TREATMENT PLANT STANDBY POWER GENERATOR ARCHITECTURAL BUILDING ELEVATIONS	CITY FILE NUMBER SHEET OF
		CONSULTANT DRAWING NO. WG-B0301		CITY DRAWING NUMBER 1-0601G-A-B0301-001-000