



CRAWLSPACE FLOOR PLAN
1:100

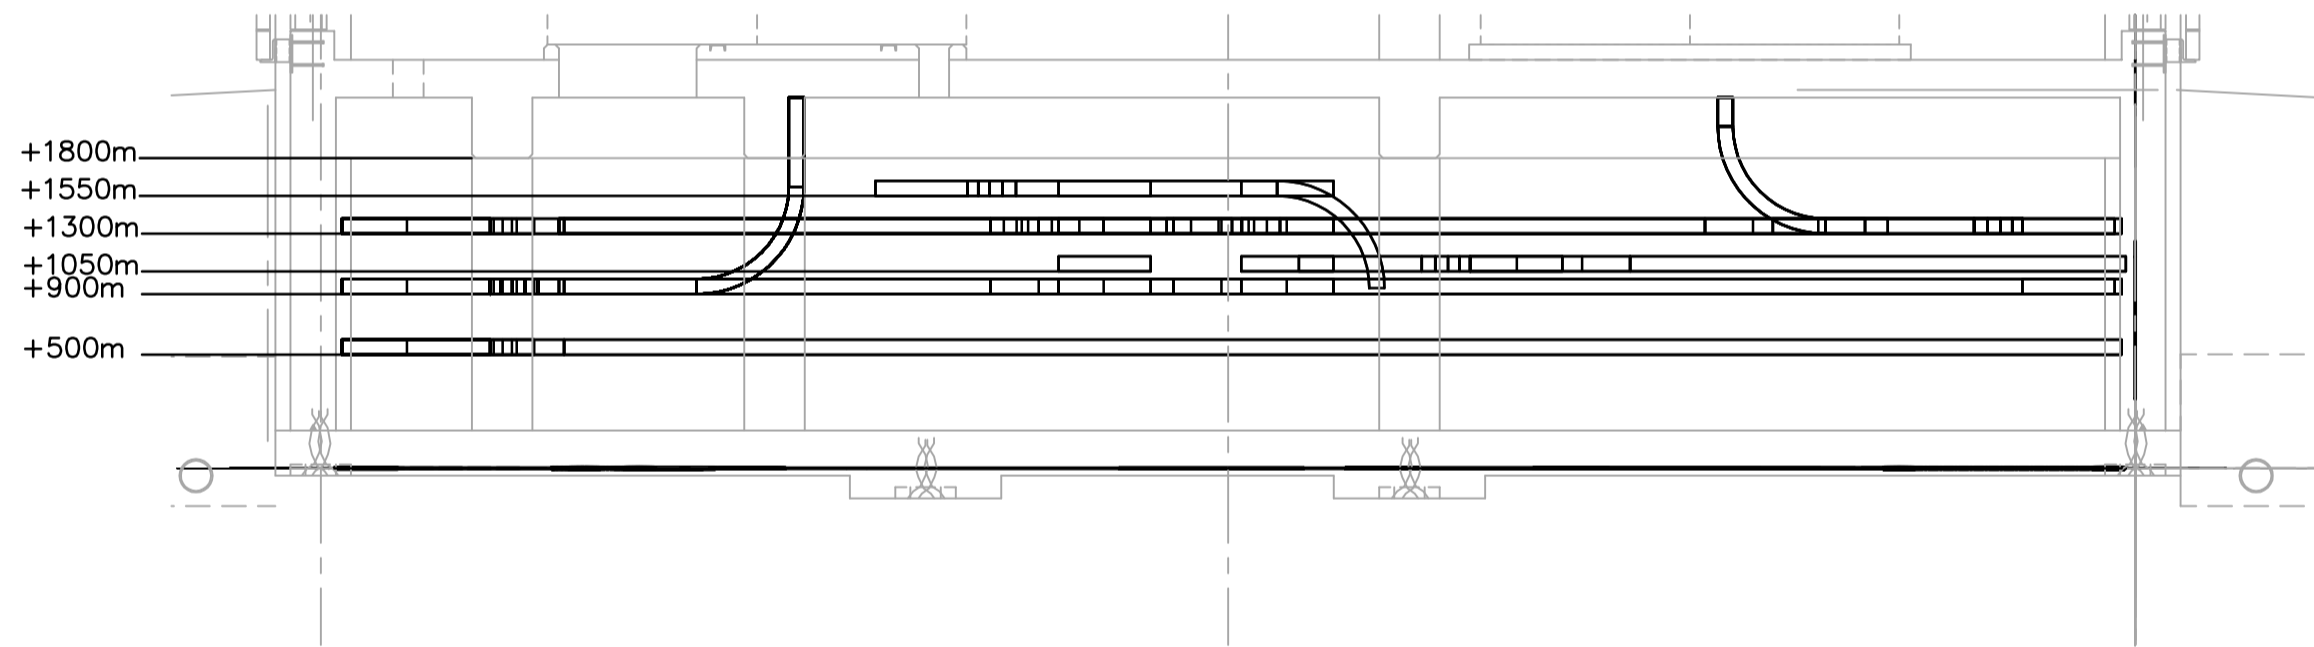

A SECTION
WG-E0102 1:50

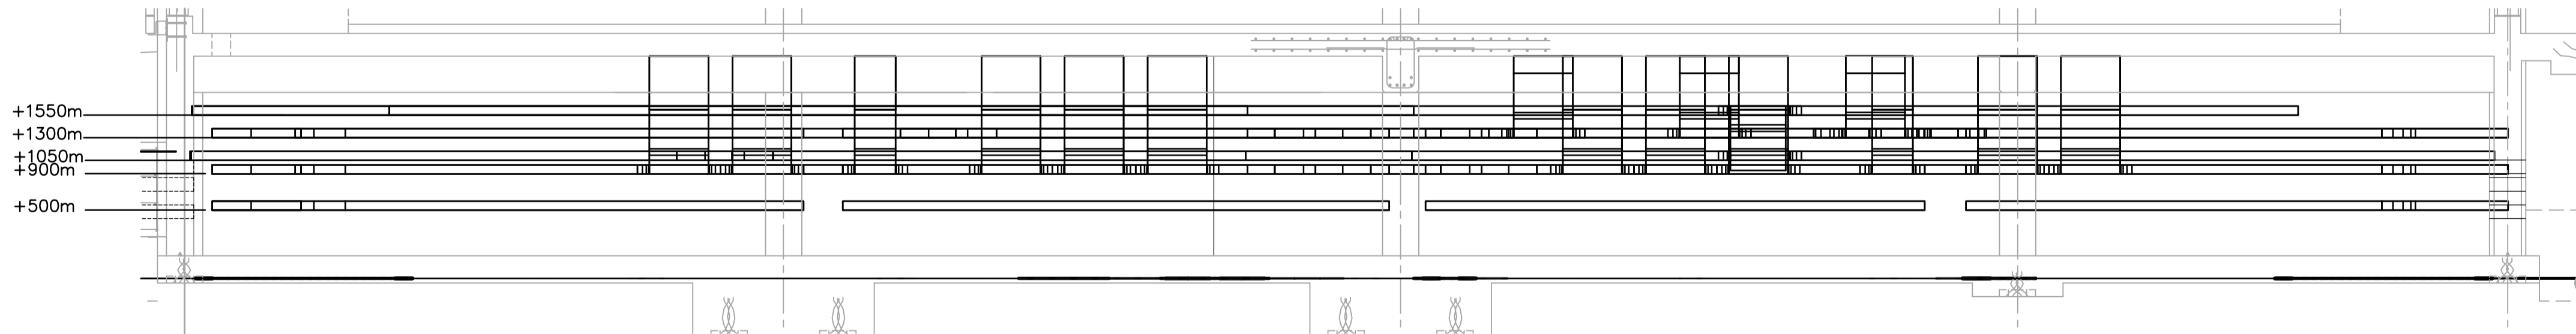

B SECTION
WG-E0102 1:50

DRAWING NOTES

1 REFER TO SHOP DRAWINGS OF CITY SUPPLIED EQUIPMENT SPECIFIED IN D2 FOR CABLE REQUIREMENTS. TECK CABLES SHALL BE USED IN PLACE OF METALLIC CONDUITS.

<p>Certificate of Authorization Earth Tech Canada Inc. No. 730 Expiry: April 30, 2007</p>	B.M. ELEV.	<p>Frederickson Cooper ARCHITECTS</p>	<p>A Type International Ltd. Company</p>	ENGINEER'S SEAL	<p>THE CITY OF WINNIPEG WATER AND WASTE DEPARTMENT ENGINEERING DIVISION</p>		
				DESIGNED BY: BLM		CHECKED BY: PS	ORIGINAL SIGNED BY: B.L. MOORE
				DRAWN BY: ERC		APPROVED BY: AHL	2006/08/30
				SCALE: AS SHOWN		RELEASED FOR CONSTRUCTION BY: R. SOROKOWSKI	CONSULTANT DRAWING NO. WG-E0102
	00 ISSUED FOR TENDER 06/08/30 ERC	DATE 2006/06/13	DATE 2006/08/30		<p>WATER TREATMENT PLANT STANDBY POWER GENERATOR GENERATOR BUILDING</p>	CITY FILE NUMBER	
	NO. REVISIONS	DATE	DATE		<p>ELECTRICAL CRAWLSPACE POWER PLAN AND SECTIONS</p>	SHEET OF	
						CITY DRAWING NUMBER	
						1-0601G-A-E0102-001-000	