

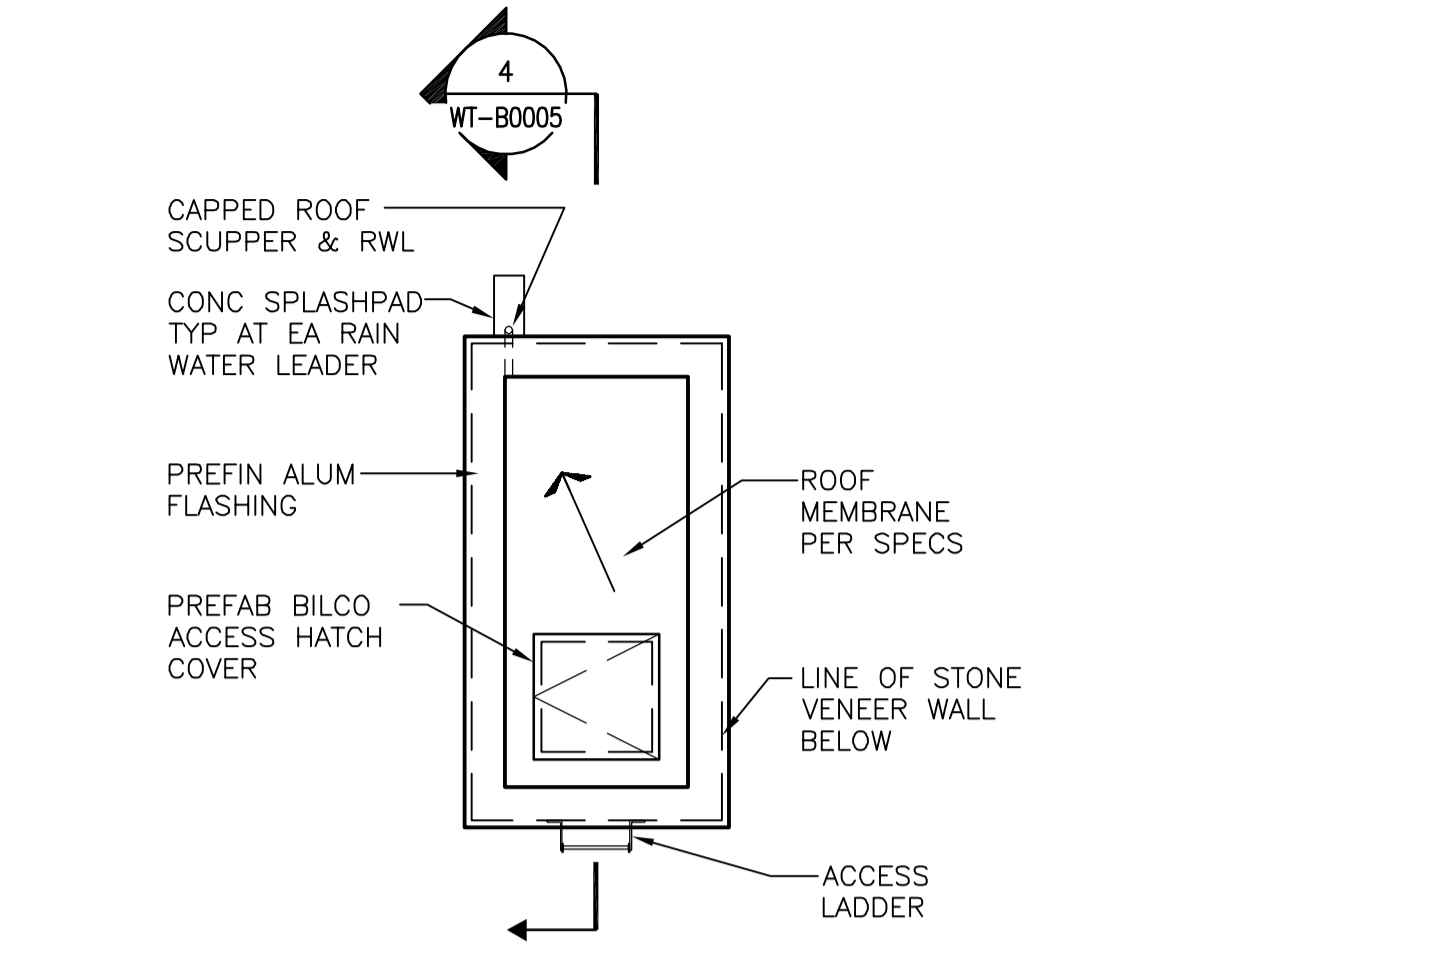


1 INLET BUILDING ROOF PLAN
1:50

NOTES:
DIRECTION OF ARROWS INDICATE SLOPE DOWN
MIN 1%, TYPICAL

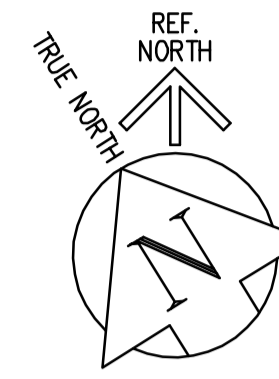

2 EMERGENCY EGRESS HUTS ROOF PLAN - TYPICAL OF 4
1:50

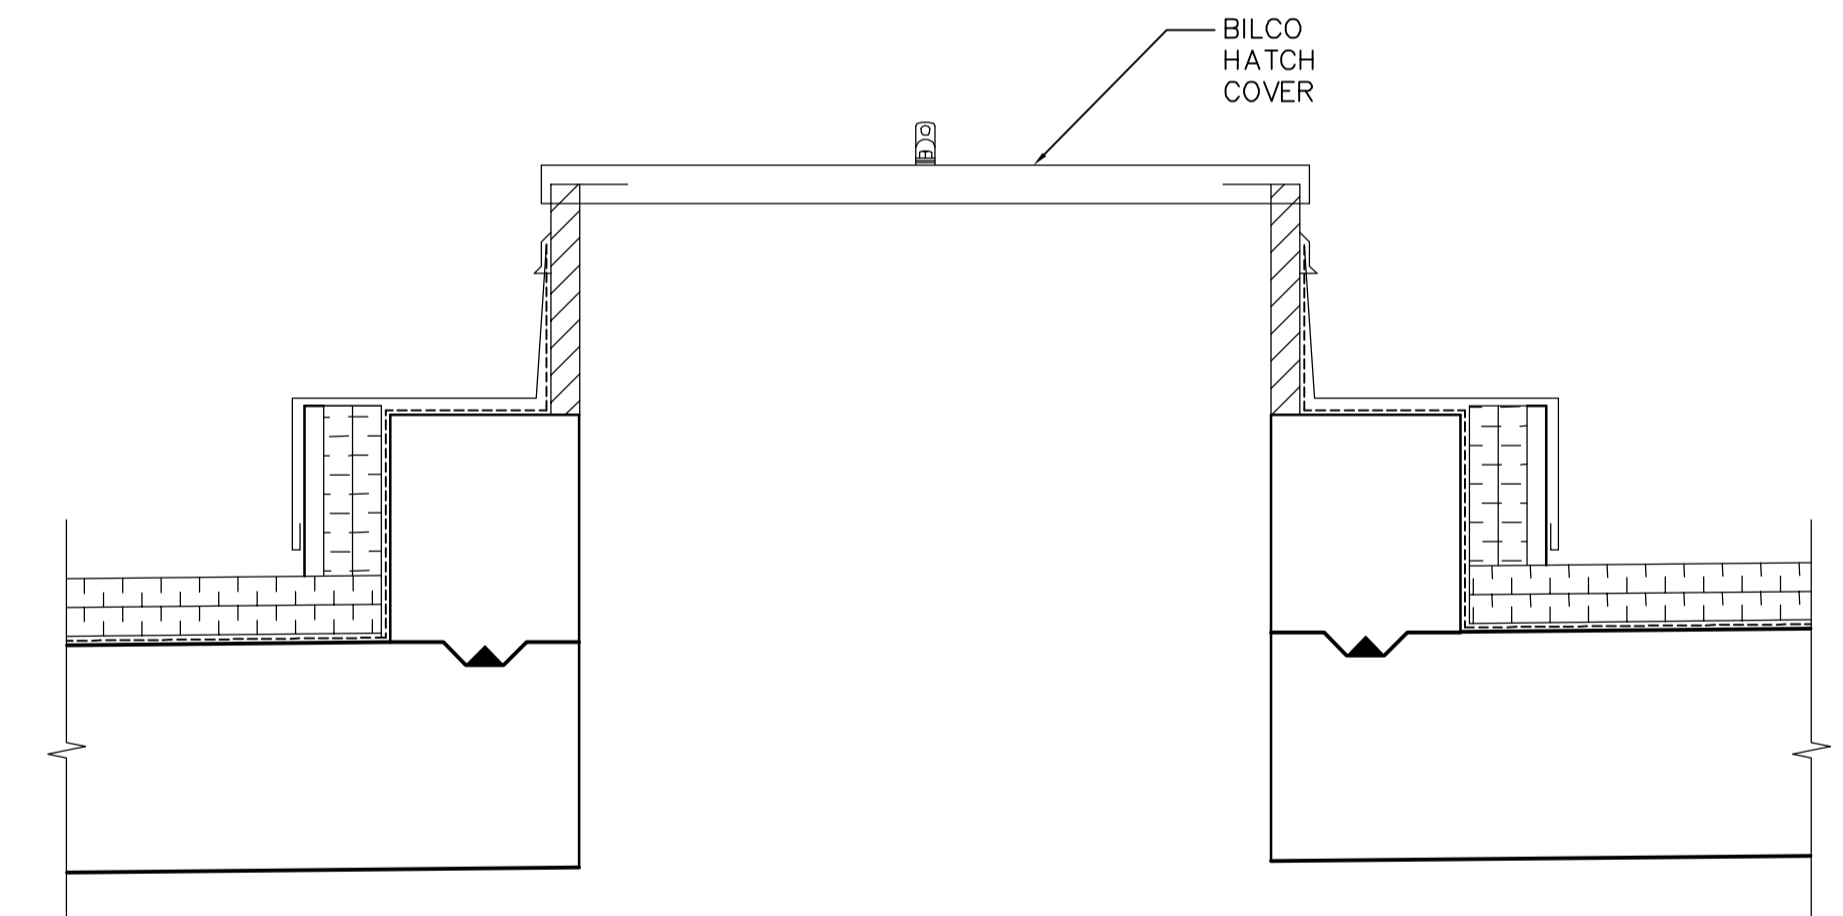

3 SECTION
1:10



1 CAPPED ROOF SCUPPER & RWL
1:50

B.M. ELEV.		 		ENGINEER'S SEAL		 THE CITY OF WINNIPEG WATER AND WASTE DEPARTMENT ENGINEERING DIVISION	
		Frederickson Cooper ARCHITECTS		ORIGINAL SIGNED BY N. COOPER 06/08/30		WATER TREATMENT PLANT TREATED WATER STORAGE INLET BUILDING	
		DESIGNED BY BS CHECKED BY MK DRAWN BY GGP / WC APPROVED BY AHL		CONSULTANT DRAWING NO. WT-B0003		CITY FILE NUMBER SHEET OF	
		SCALE: AS NOTED RELEASED FOR CONSTRUCTION BY: R. SOROKOWSKI				CITY DRAWING NUMBER 1-0601T-A-B0003-01-000	
00 ISSUED FOR TENDER 06/08/28 WDB		DATE 05/04/04 DATE 06/08/30					
NO. REVISIONS		DATE BY					