




1 NORTH ELEVATION
1:100

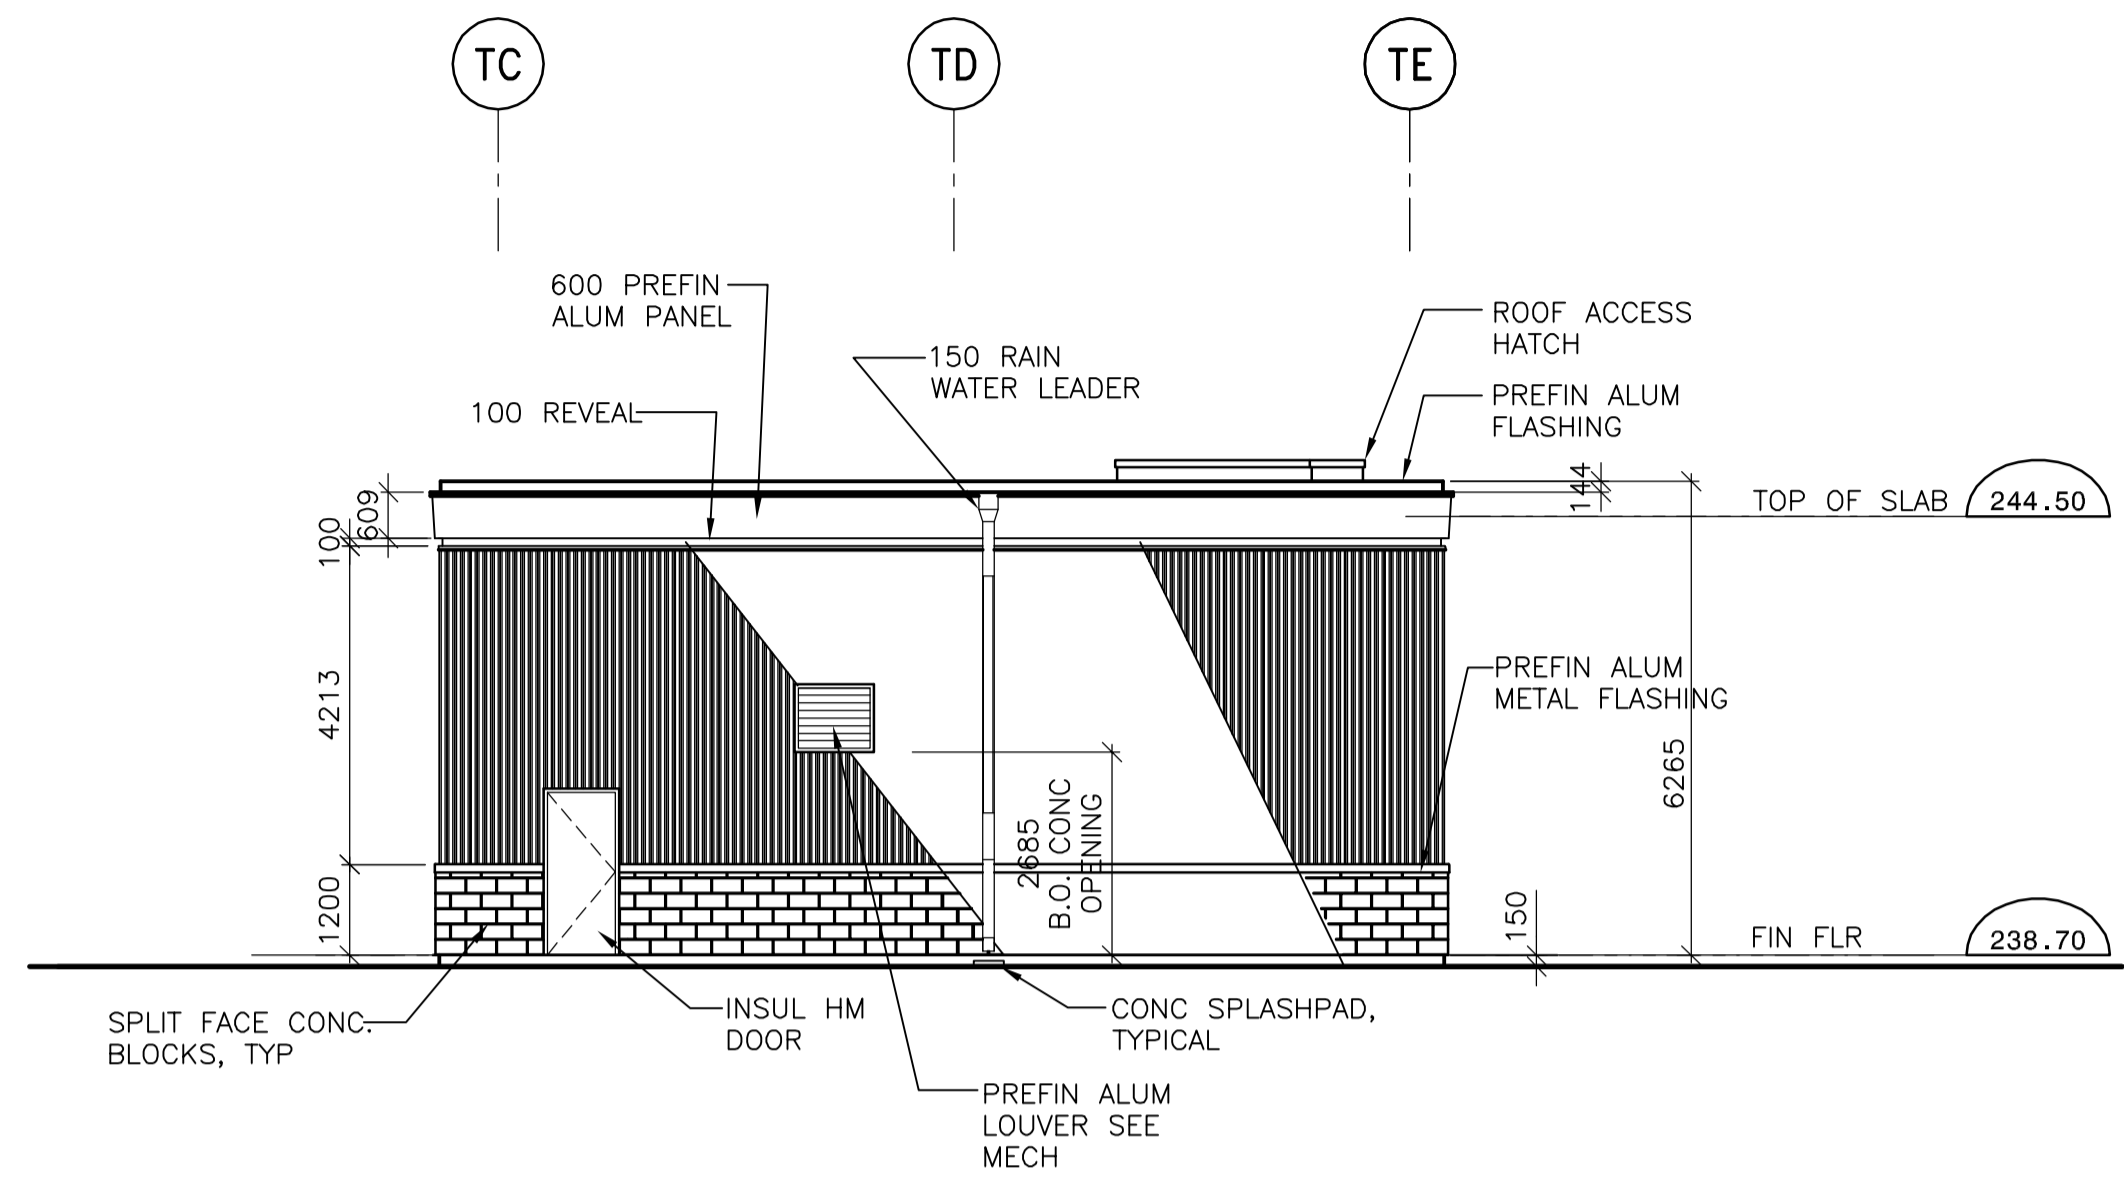

2 WEST ELEVATION
1:100

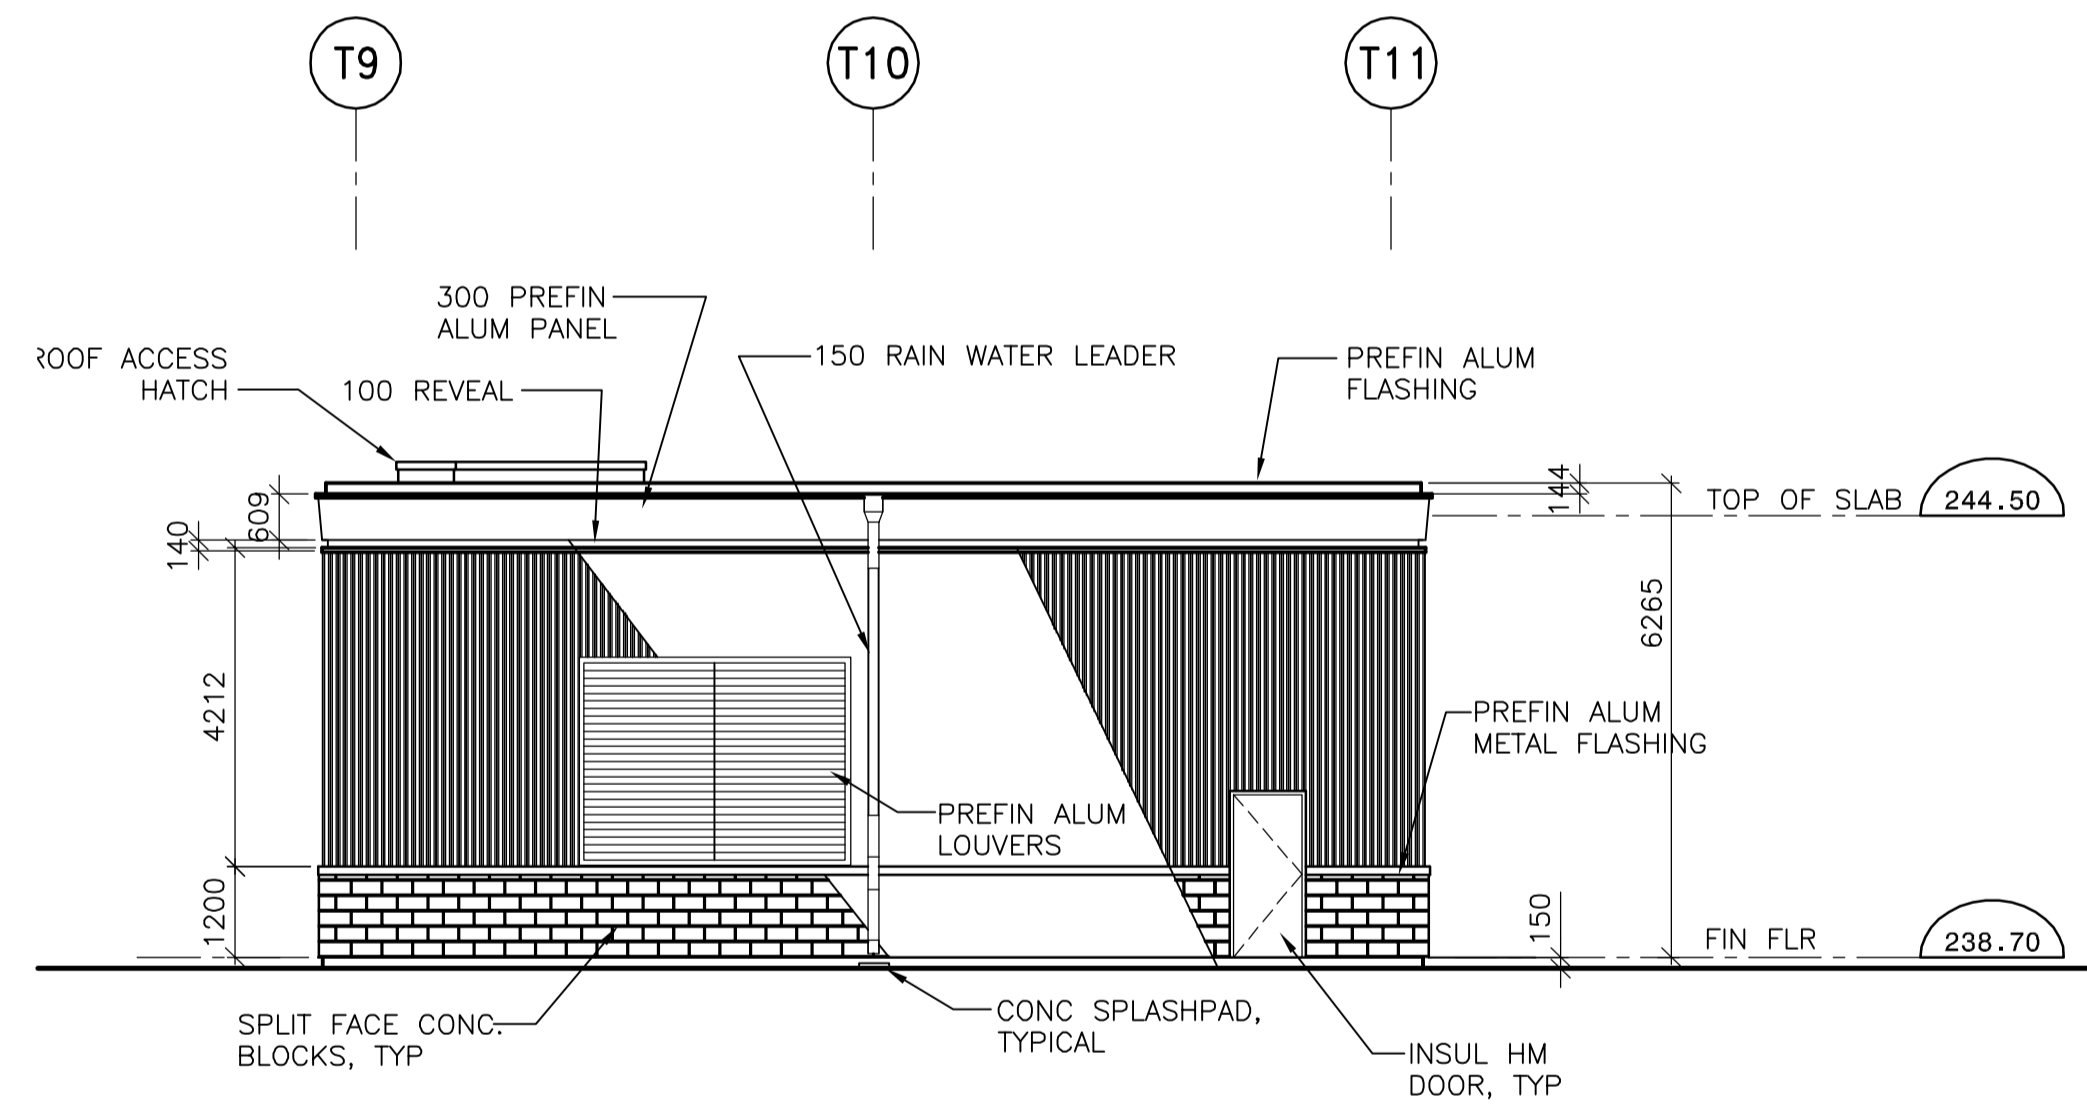

3 SOUTH ELEVATION
1:100

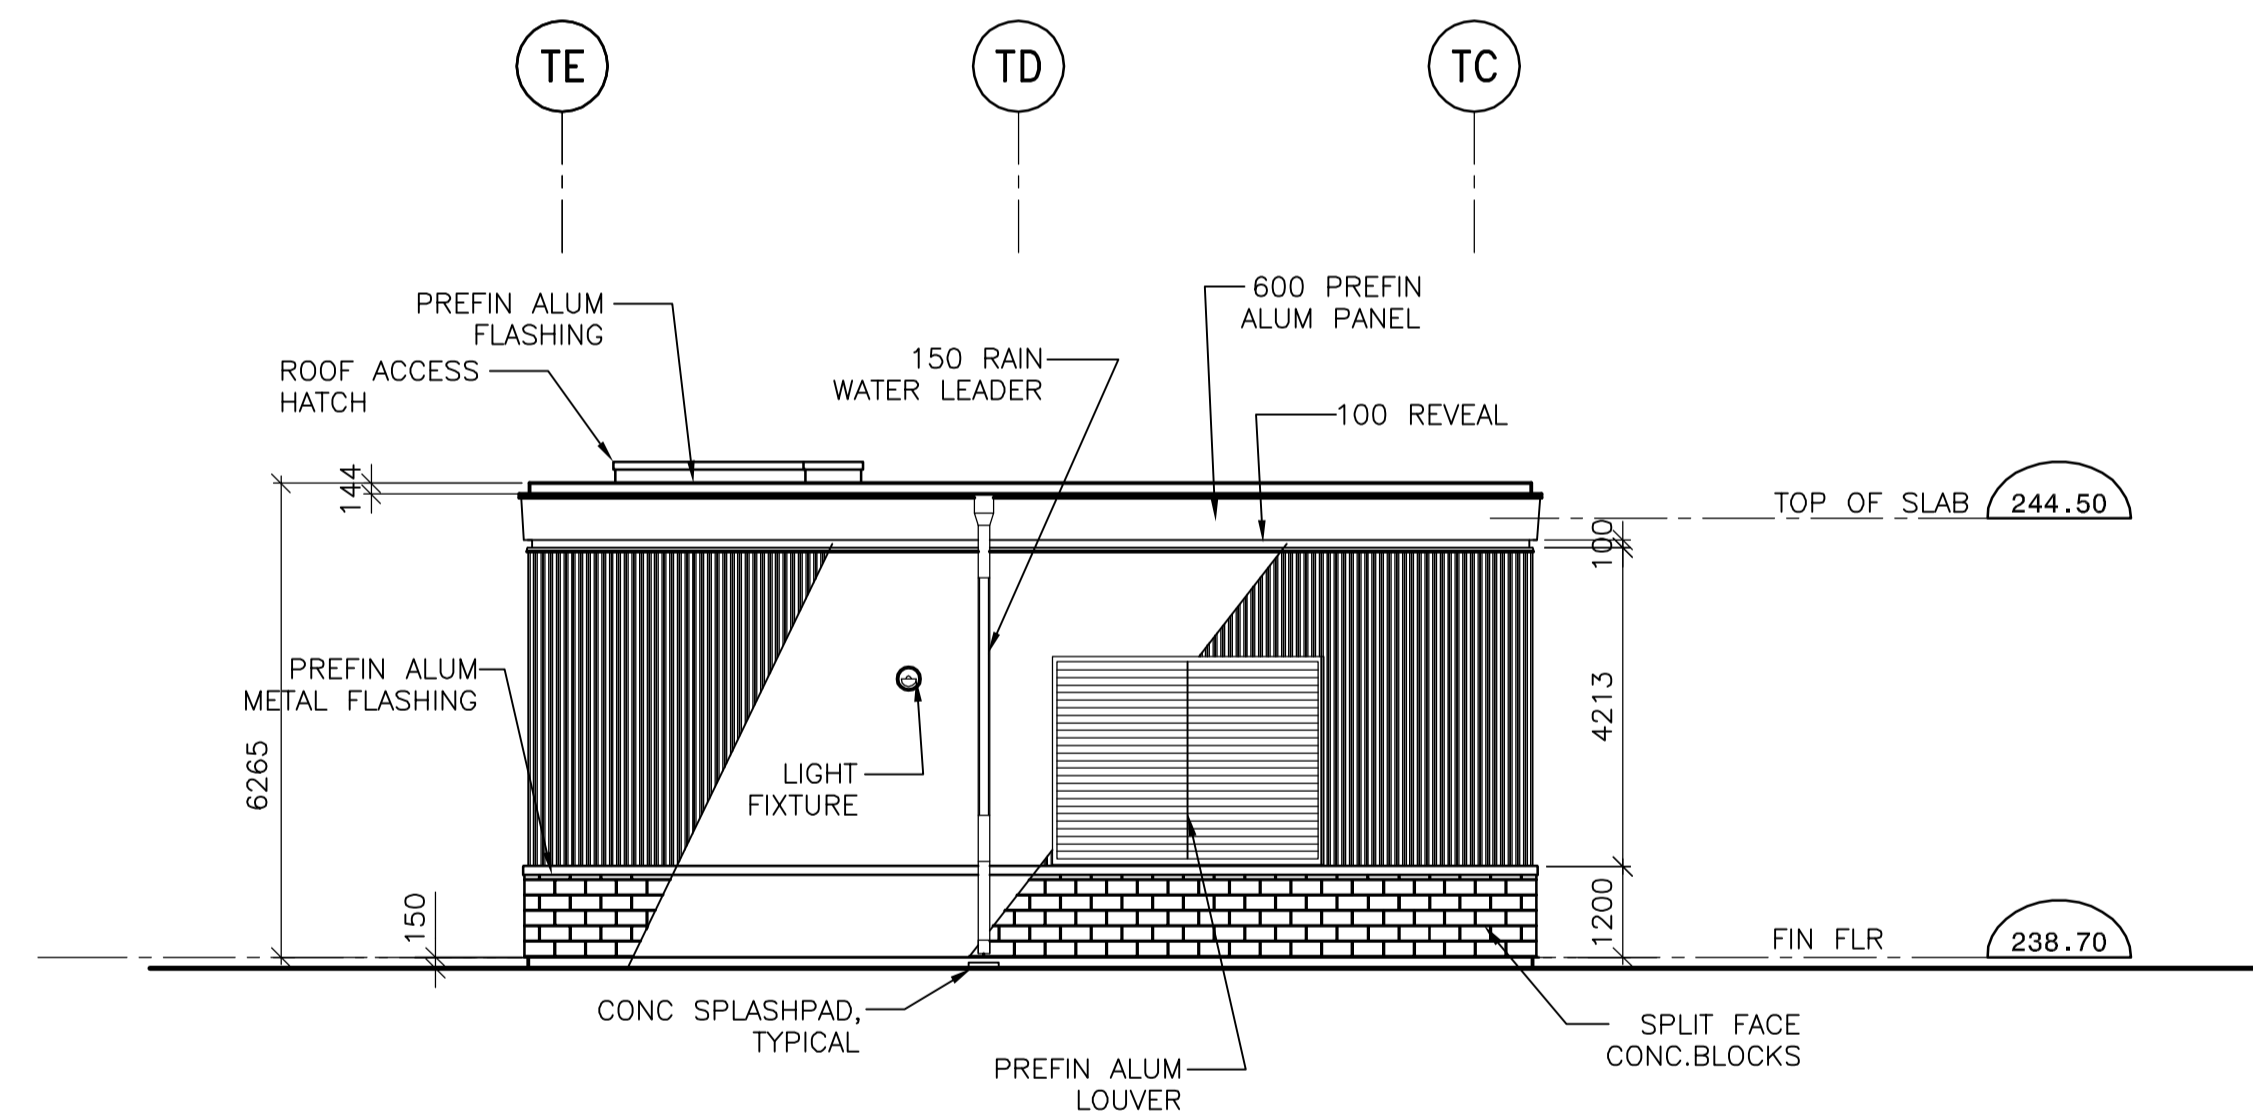

4 EAST ELEVATION
1:100

B.M. ELEV.			 		ENGINEER'S SEAL		 THE CITY OF WINNIPEG WATER AND WASTE DEPARTMENT ENGINEERING DIVISION	
			Frederickson Cooper ARCHITECTS		ORIGINAL SIGNED BY N. COOPER 06/08/30		WATER TREATMENT PLANT TREATED WATER STORAGE INLET BUILDING	
			DESIGNED BY BS DRAWN BY GGP/WC SCALE: AS NOTED		CHECKED BY MK APPROVED BY AHL RELEASED FOR CONSTRUCTION BY: R. SOROKOWSKI 06/08/30		CITY FILE NUMBER SHEET OF	
00 ISSUED FOR TENDER 06/08/28 WDB			DATE 05/04/04		CONSULTANT DRAWING NO. WT-B0004		CITY DRAWING NUMBER 1-0601T-A-B0004-001-000	
NO. REVISIONS			DATE BY		DATE		ARCHITECTURAL BUILDING ELEVATIONS	