



INLET BUILDING MAIN FLOOR POWER PLAN
1:50

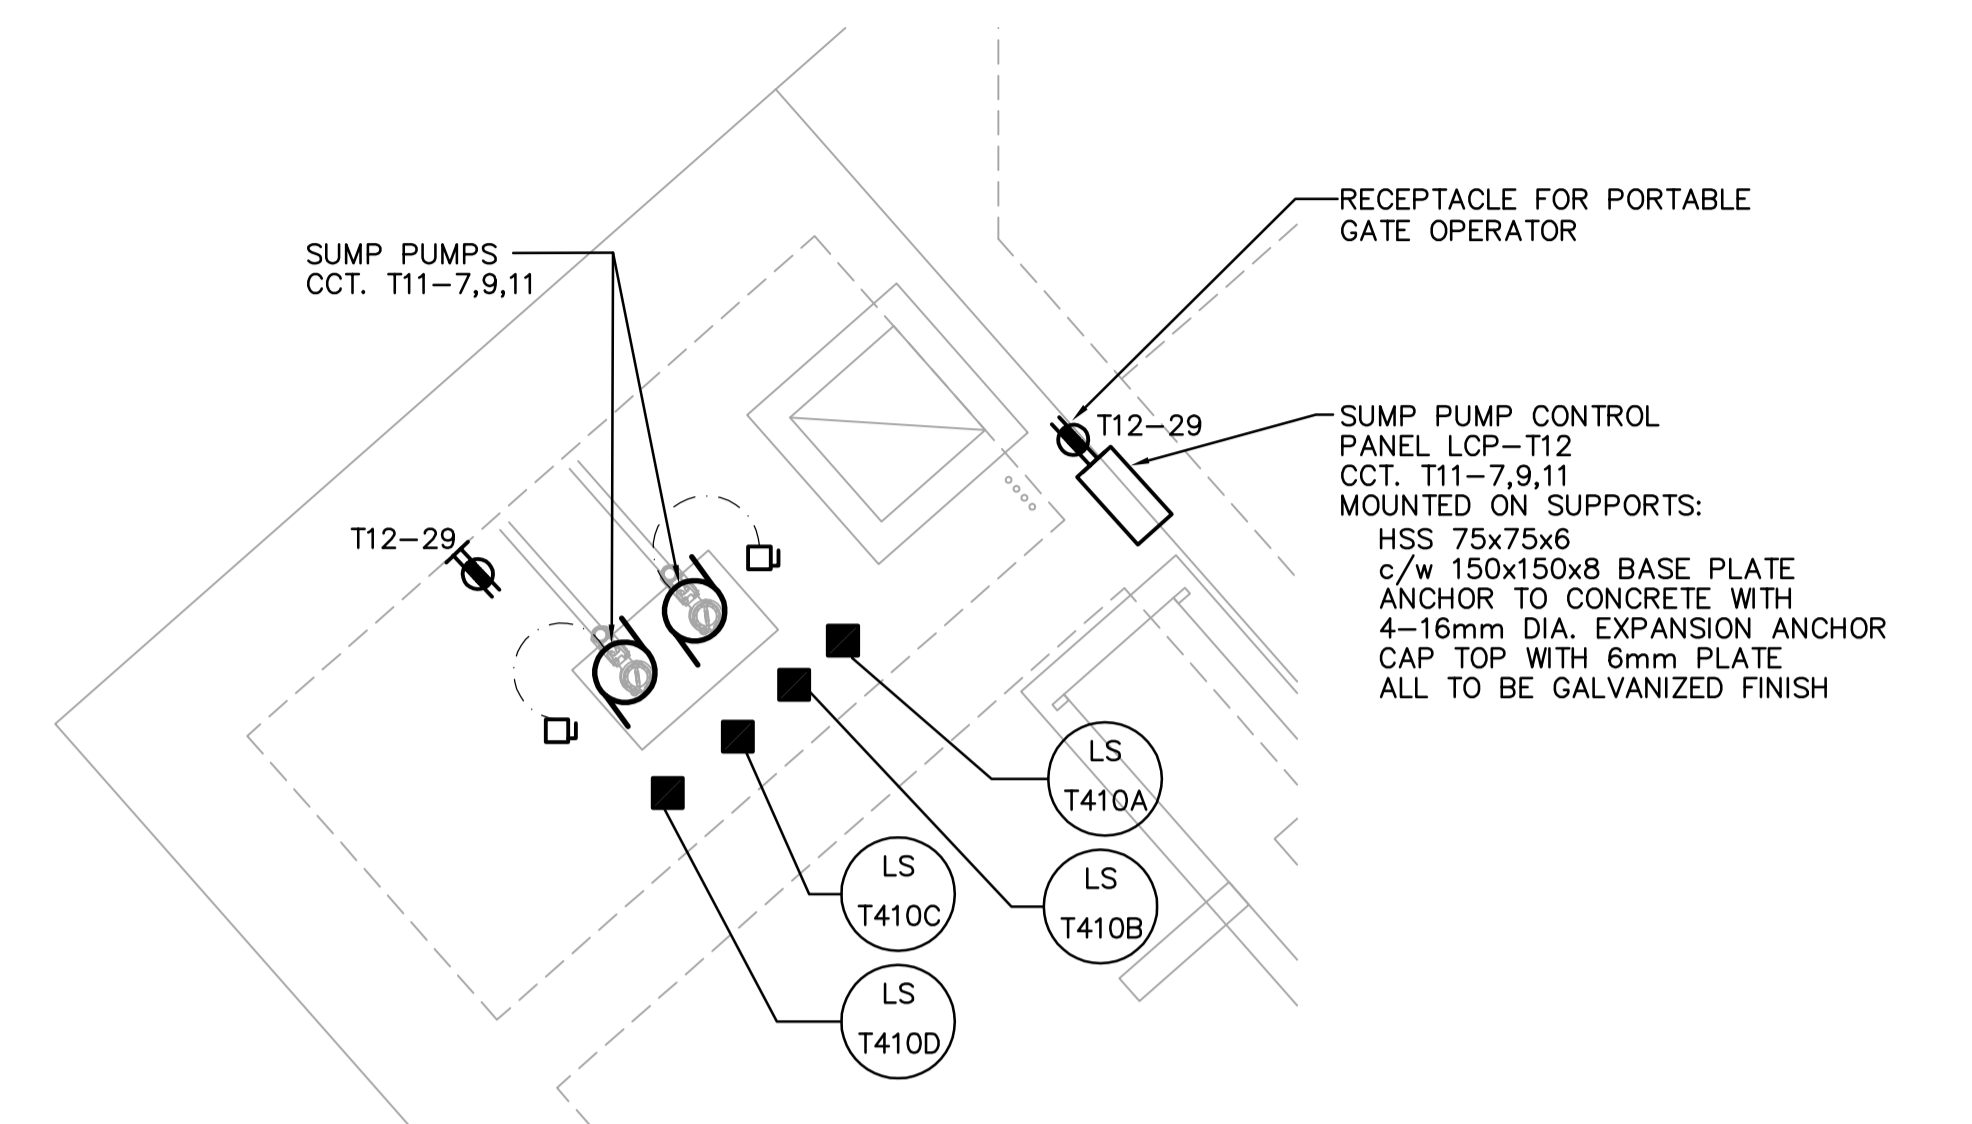

SUMP PIT AREA POWER PLAN
1:50

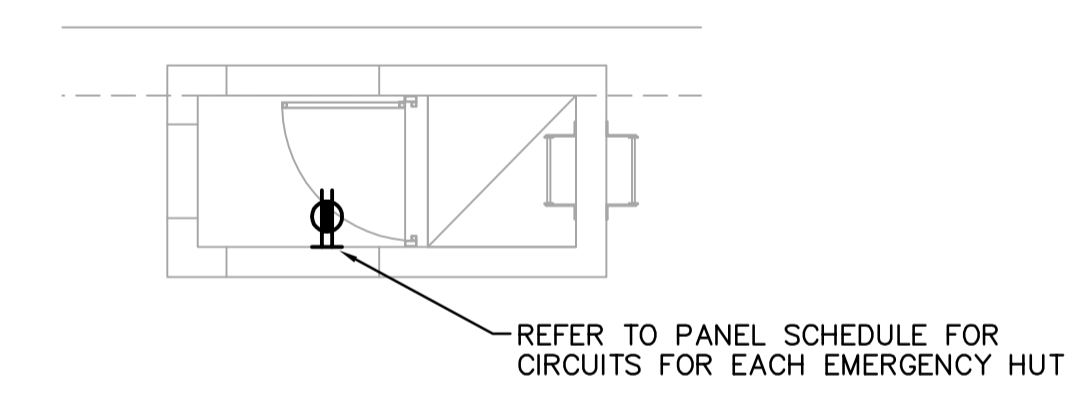

EMERGENCY HUT POWER PLAN
1:50

<p>Certificate of Authorization Earth Tech Canada Inc. No. 730 Expiry: April 30, 2007</p>	B.M. ELEV.	<p>Frederickson Cooper ARCHITECTS</p>	<p>A Tyco International Ltd. Company</p>	<p>ENGINEER'S SEAL</p> <p>ORIGINAL SIGNED BY B.L. MOORE 2006/08/30</p>	<p>THE CITY OF WINNIPEG WATER AND WASTE DEPARTMENT ENGINEERING DIVISION</p>			
	DESIGNED BY: BLM					CHECKED BY: PS	<p>WATER TREATMENT PLANT TREATED WATER STORAGE INLET BUILDING</p>	CITY FILE NUMBER
	DRAWN BY: ERC					APPROVED BY: AHL		SHEET OF
	SCALE: 1:50					RELEASED FOR CONSTRUCTION BY: R. SOROKOWSKI		CITY DRAWING NUMBER
00 ISSUED FOR TENDER 06/08/30 ERC	DATE: 2005/03/18	DATE: 2006/08/30	CONSULTANT DRAWING NO. WT-E0112	POWER AND FIRE ALARMS FLOOR PLANS	1-0601T-A-E0112-001-000			