


1 FLOOR PLAN
1:25

PANEL SCHEDULE									
Panel PP-Y14									
DESCRIPTION	LOAD	BKR	CCT	A	B	CCT	BKR	LOAD	DESCRIPTION
Lighting - Interior		15	1	*	2	15	1		Receptacle
Lighting - Exterior		15	3	*	4	15	1		Receptacle - Pump
Spare		15	5	*	6	15	15		Spare
Spare		15	7	*	8	15	15		Spare
Space			9	*	10	15			Space
Space			11	*	12	20			Space
Space			13	*	14	30			Space
Space			15	*	16	20			Space

Voltage:	120V/1Ø/2 wire	Feeder:	2/C#8 Teck
Mains:	225A	Main Breaker:	N/A
Location:	Valve Chamber Building	Power Source:	Transformer XFMR-PP-Y14
Mounting:	Surface		

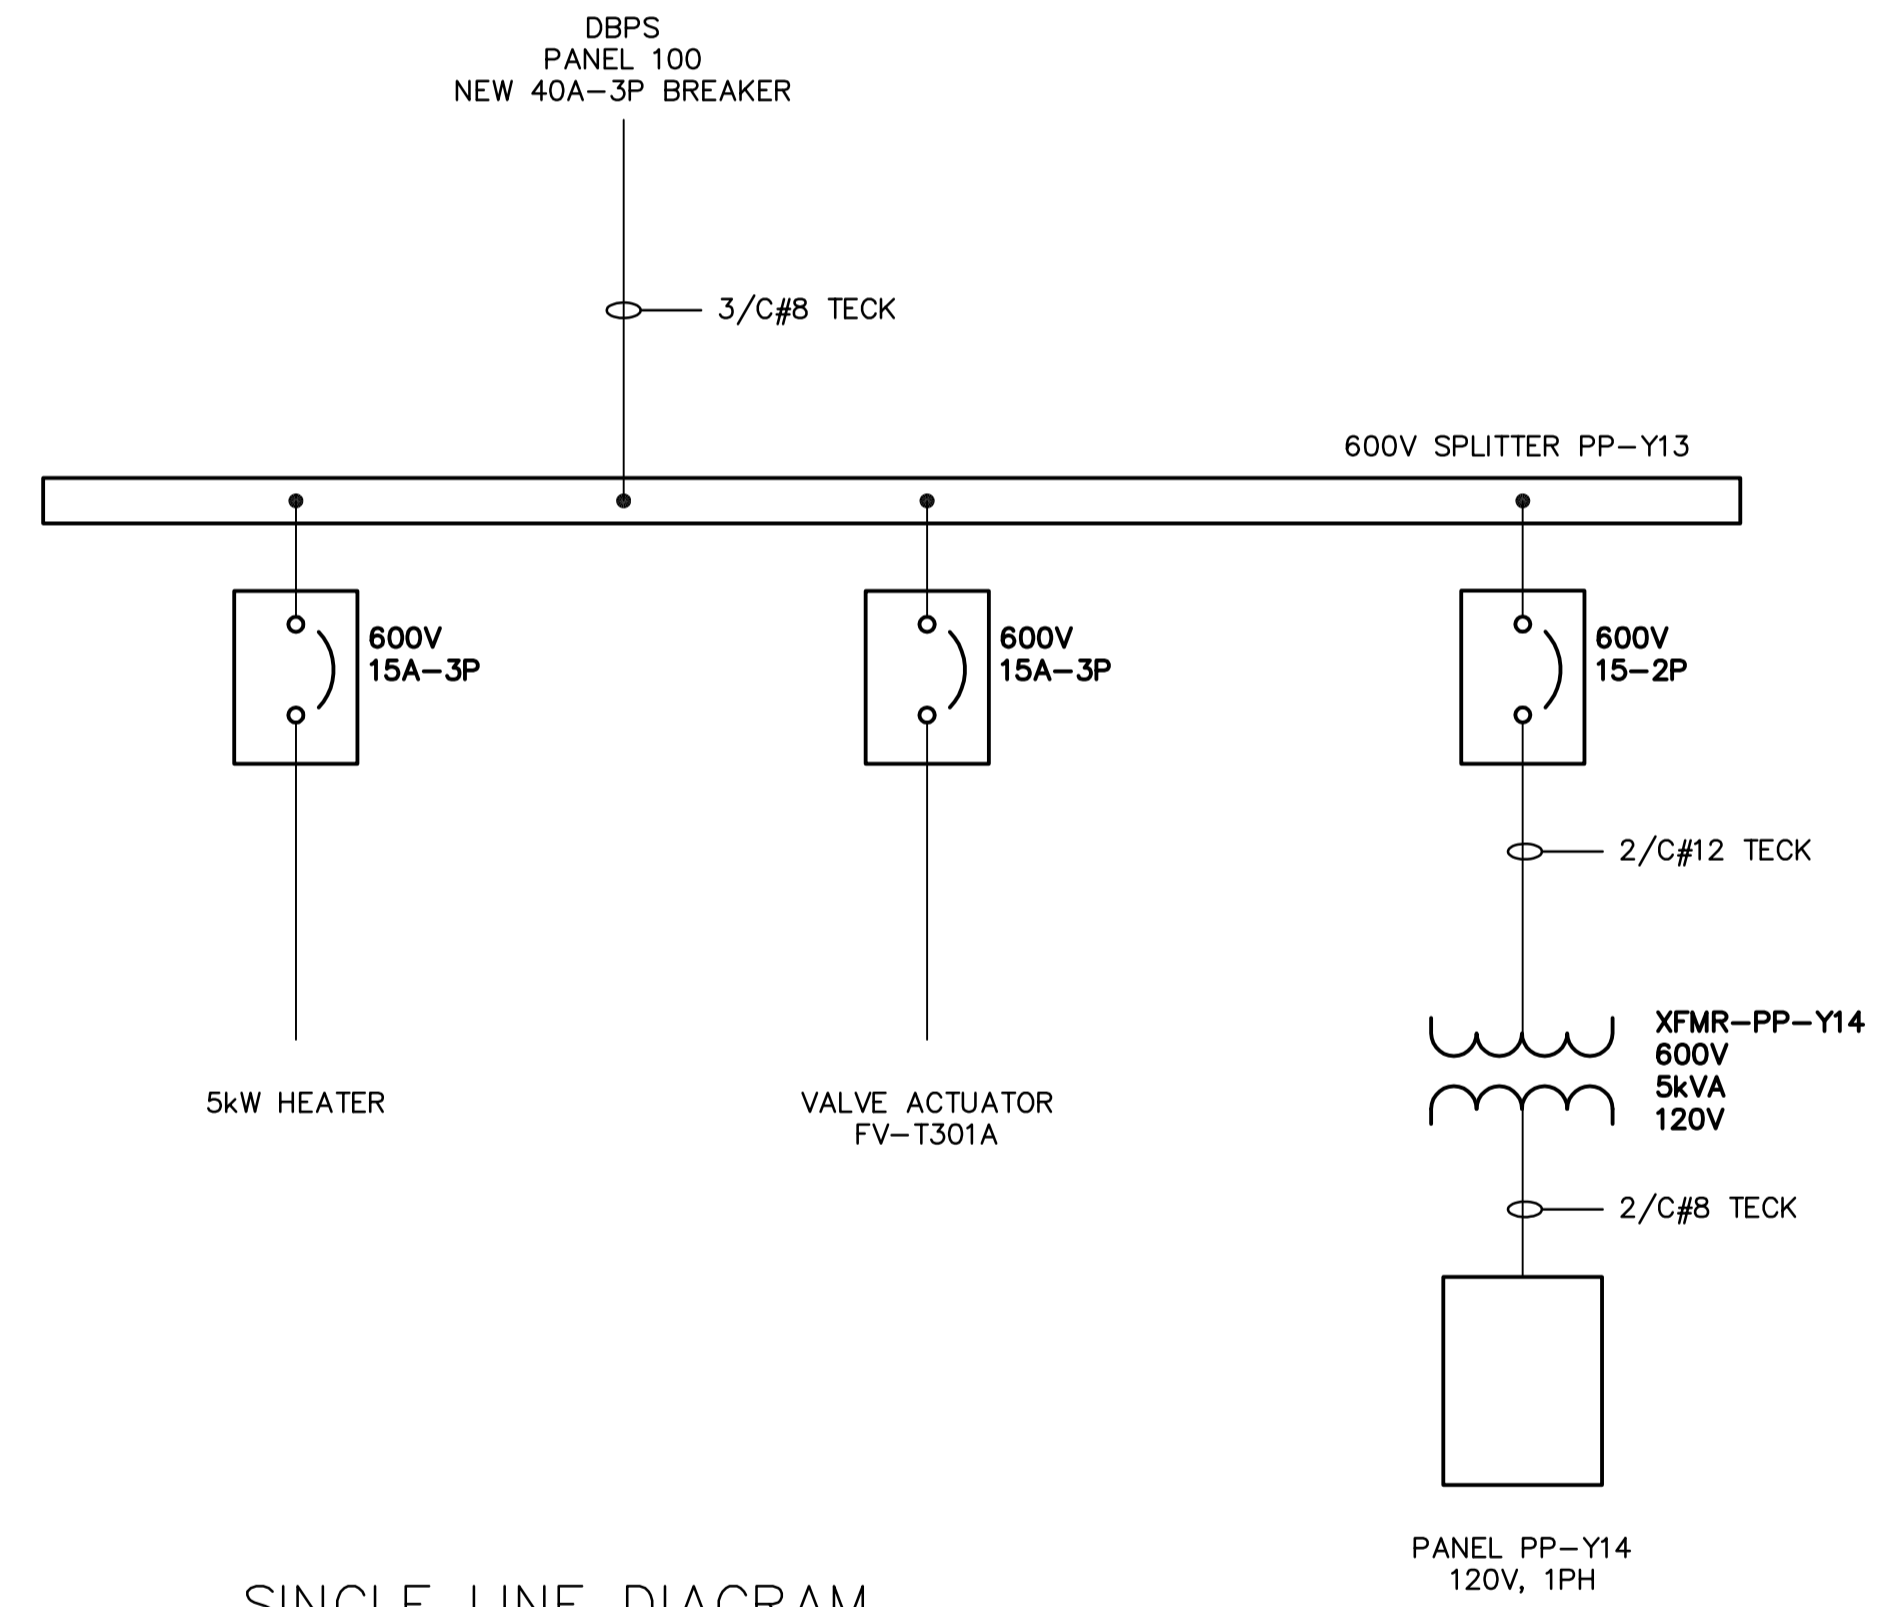

SINGLE LINE DIAGRAM
SCALE: NTS

<p>Certificate of Authorization Earth Tech Canada Inc. No. 730 Expiry: April 30, 2007</p>	B.M. ELEV.	<p>Frederickson Cooper ARCHITECTS</p>	<p>A Type International Ltd. Company</p>	ENGINEER'S SEAL	<p>THE CITY OF WINNIPEG WATER AND WASTE DEPARTMENT ENGINEERING DIVISION</p>		
				DESIGNED BY: BLM		CHECKED BY: BLM	ORIGINAL SIGNED BY: B.L. MOORE
				DRAWN BY: ERC		APPROVED BY: AHL	2006/08/30
				SCALE: AS NOTED		RELEASED FOR CONSTRUCTION BY: R. SOROKOWSKI	CONSULTANT DRAWING NO. WY-E0121
	00 ISSUED FOR TENDER 06/08/30 ERC	DATE 2006/06/01	DATE 2006/08/30		<p>WATER TREATMENT PLANT YARD PIPING AND VALVE CHAMBERS VALVE CHAMBERS</p> <p>ELECTRICAL POWER AND LIGHTING</p>		
	NO. REVISIONS	DATE	BY		<p>CITY FILE NUMBER</p> <p>SHEET OF</p> <p>CITY DRAWING NUMBER</p> <p>1-0601Y-A-E0121-001-000</p>		