




1 PLAN AT EL 228.35  
WY-H0403 1:50

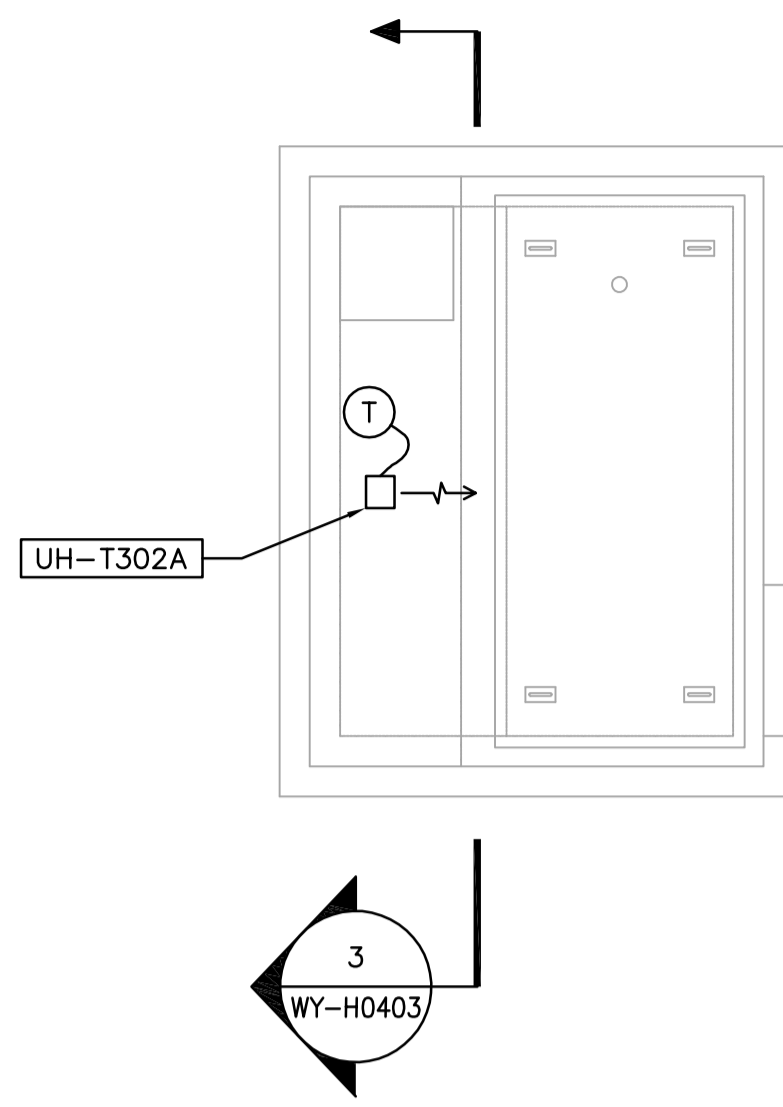


2 MAIN FLOOR PLAN  
WY-H0403 1:50

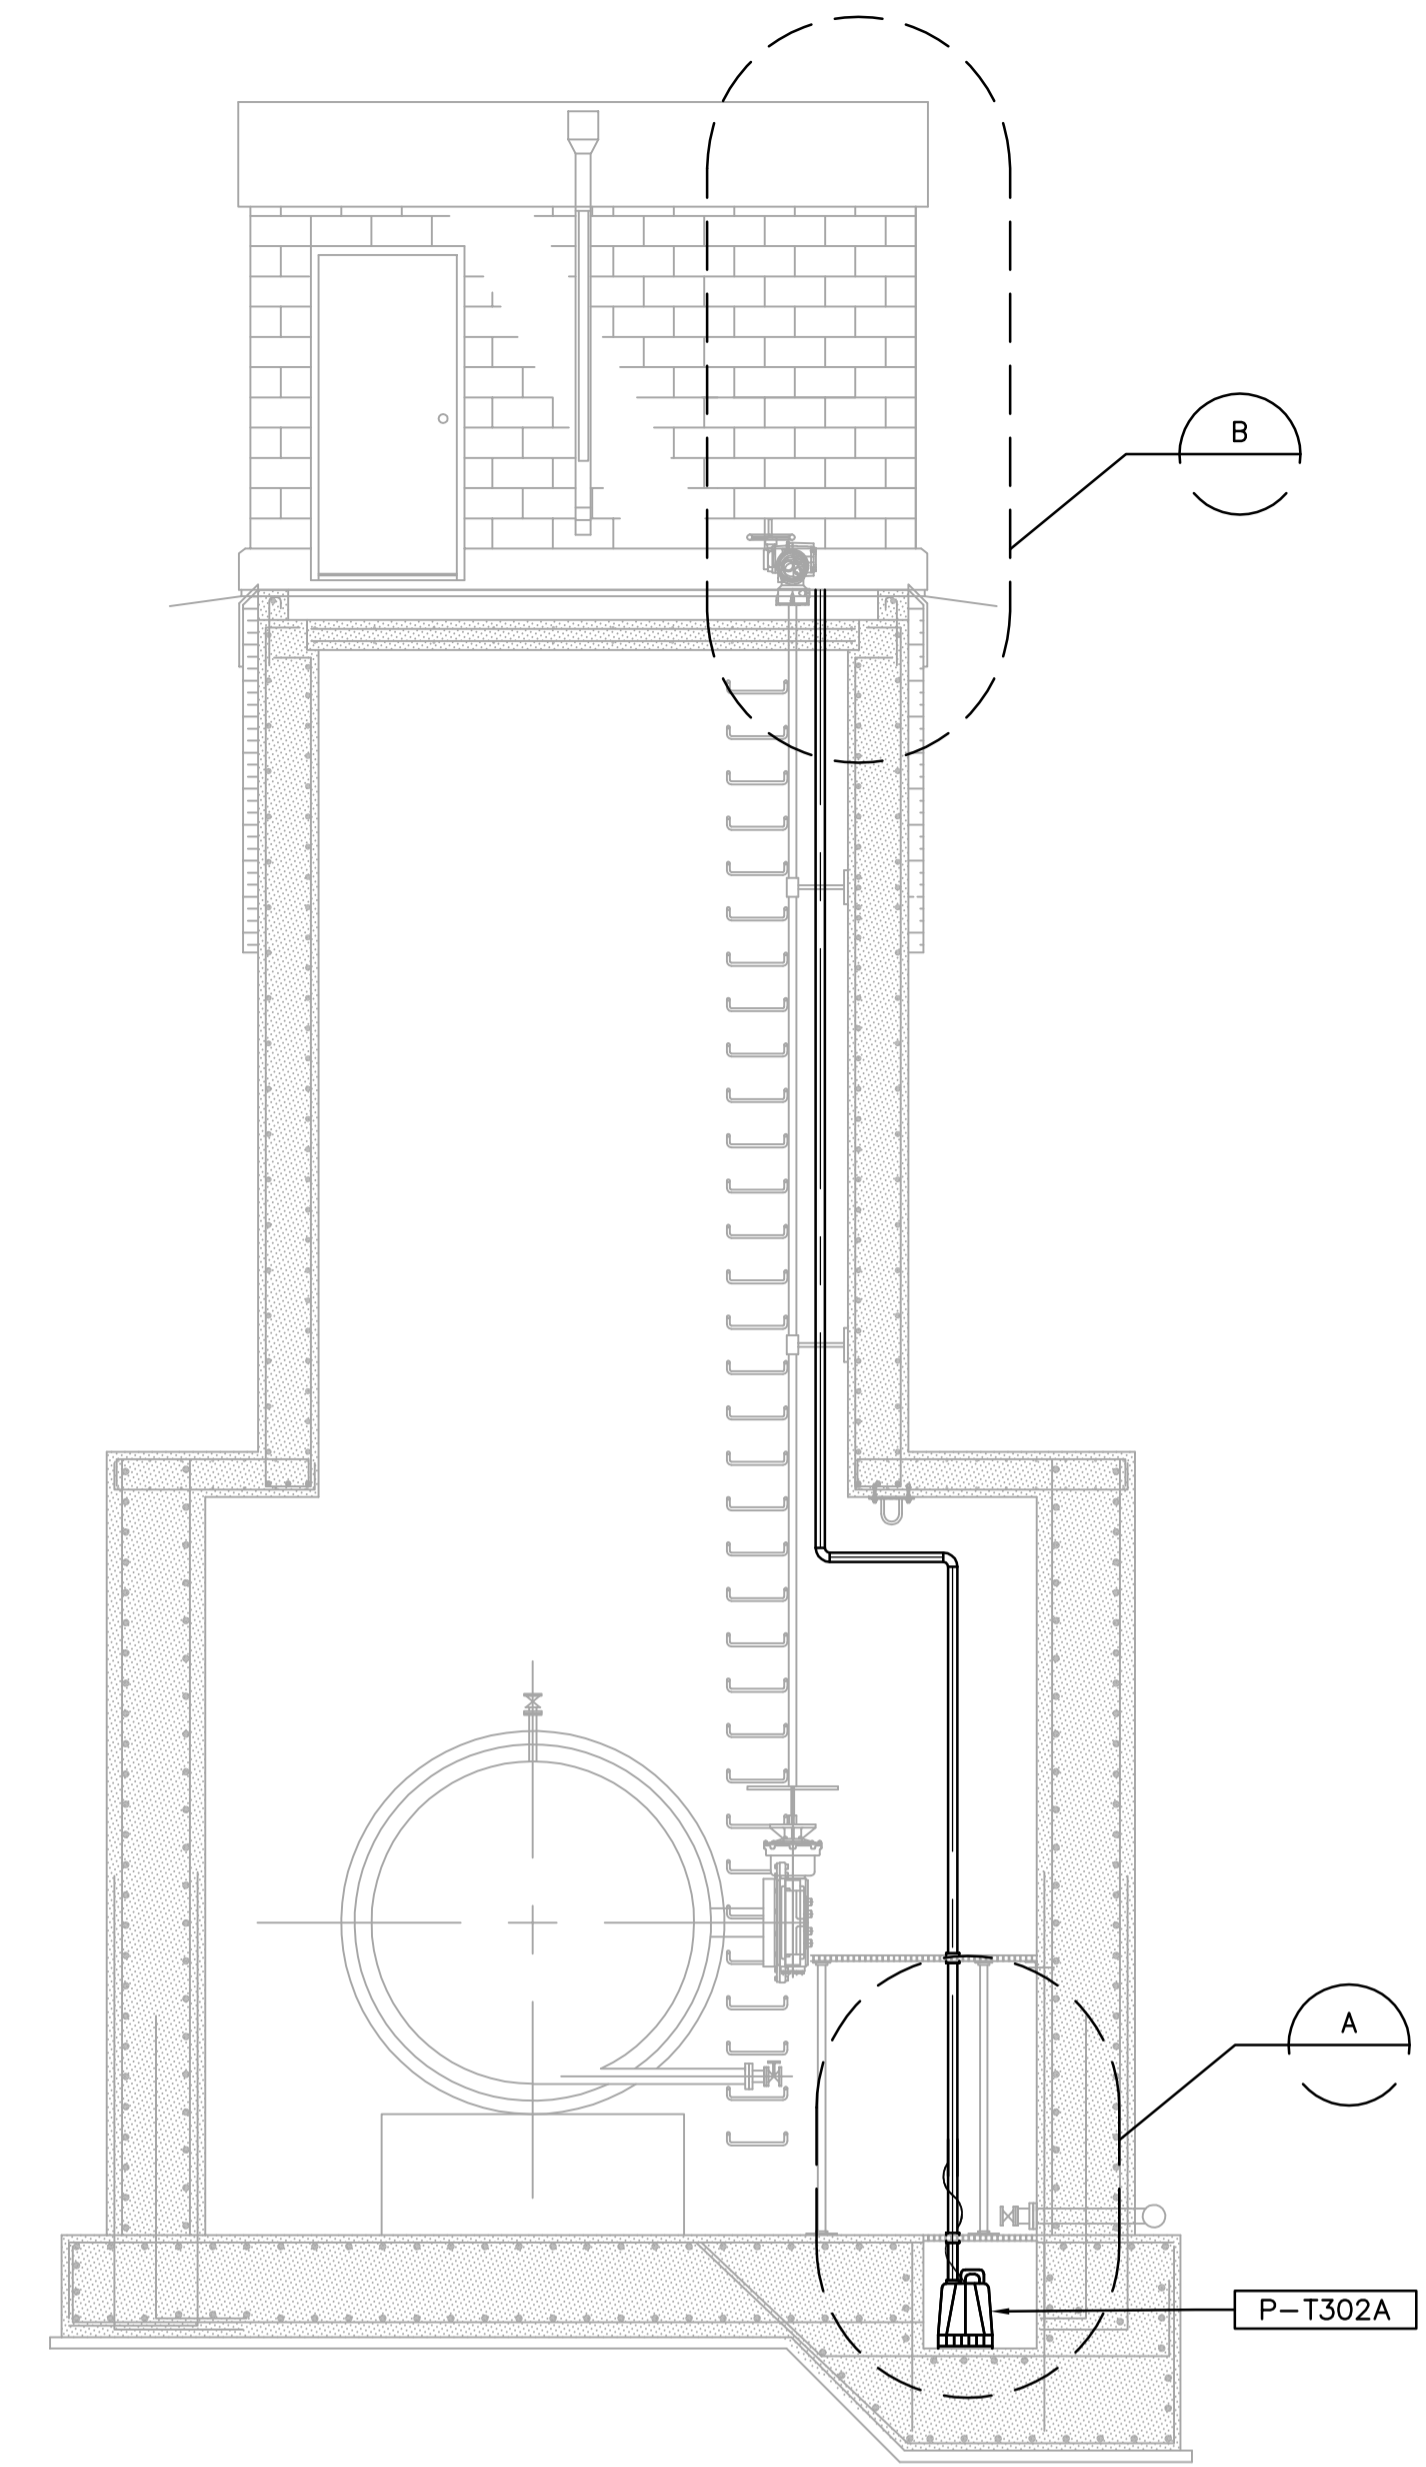

3 SECTION  
WY-H0403 1:50

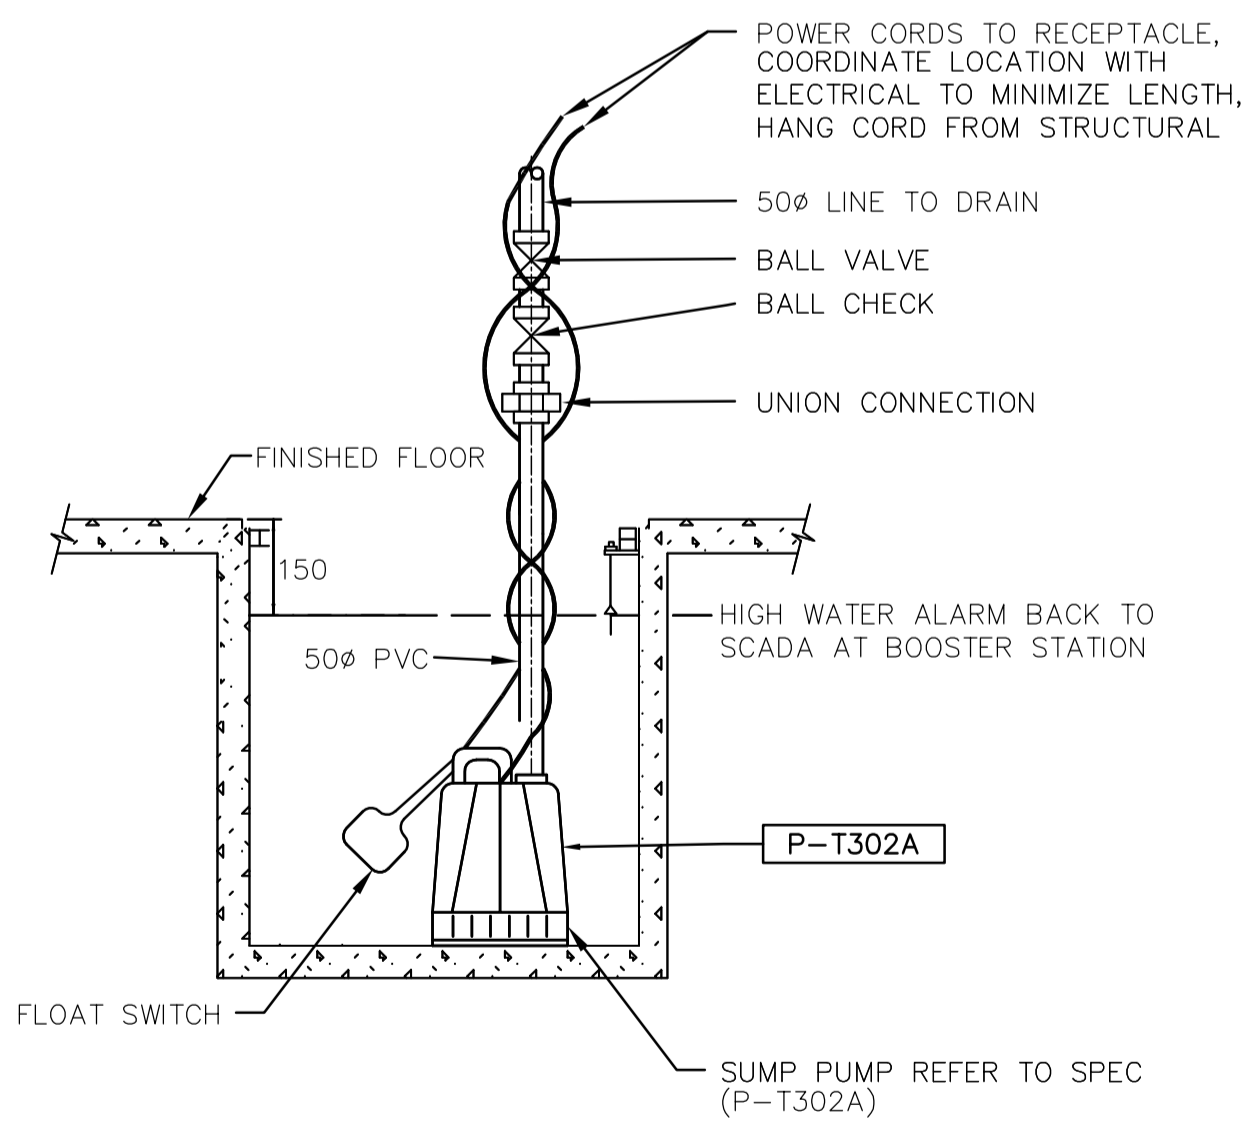

A SUMP PUMP DETAIL  
NTS

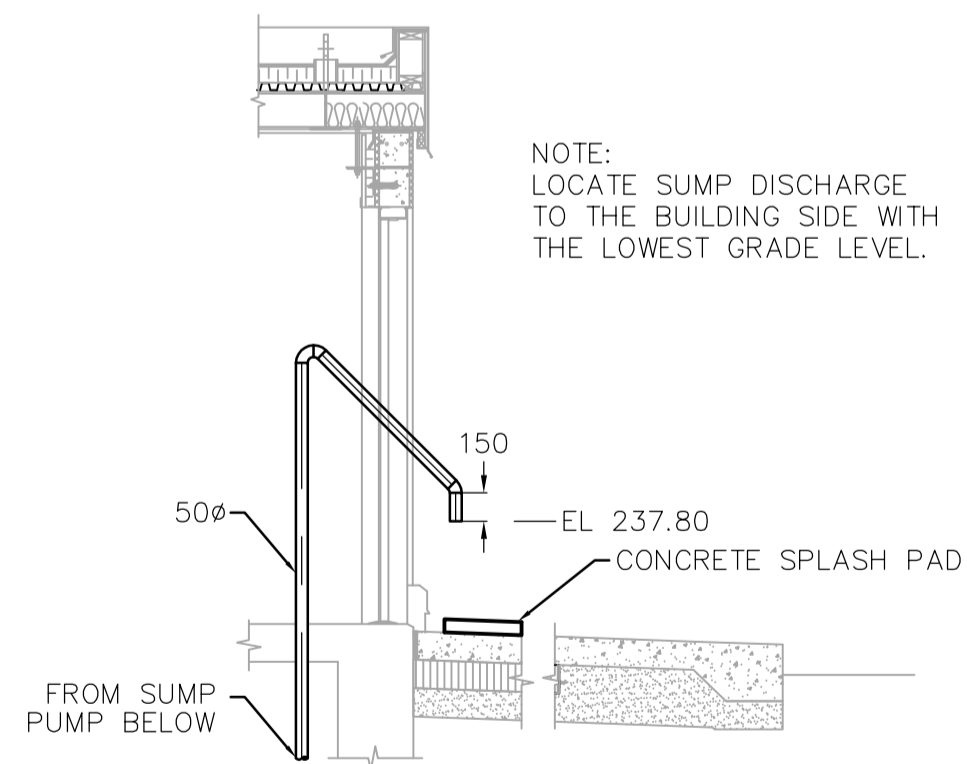

B SUMP DISCHARGE DETAIL  
NTS

**CELL 3 TREATED WATER VALVE CHAMBER**

<p><b>APEGM</b> Certificate of Authorization Earth Tech Canada Inc. No. 730 Expiry: April 30, 2007</p>	B.M. ELEV.		<p>Frederickson Cooper ARCHITECTS</p>	<p>EarthTech A Tyco International Ltd. Company</p>	ENGINEER'S SEAL		<p><b>THE CITY OF WINNIPEG</b> WATER AND WASTE DEPARTMENT ENGINEERING DIVISION</p>	CITY FILE NUMBER	
					DESIGNED BY DC	CHECKED BY AB		ORIGINAL SIGNED BY A. BURACHYNSKY	SHEET OF
					DRAWN BY DJ	APPROVED BY AHL		2006/08/30	
					SCALE: AS NOTED	RELEASED FOR CONSTRUCTION BY: R. SOROKOWSKI		CONSULTANT DRAWING NO. WY-H0403	CITY DRAWING NUMBER 1-0601Y-A-H0403-001-00D
00 ISSUED FOR TENDER 06/08/28 DC		DATE BY	DATE 2006/06/01	DATE 2006/08/30	MECHANICAL PLUMBING AND HVAC PLANS, SECTIONS AND DETAILS				
NO. REVISIONS									