


MUA-1

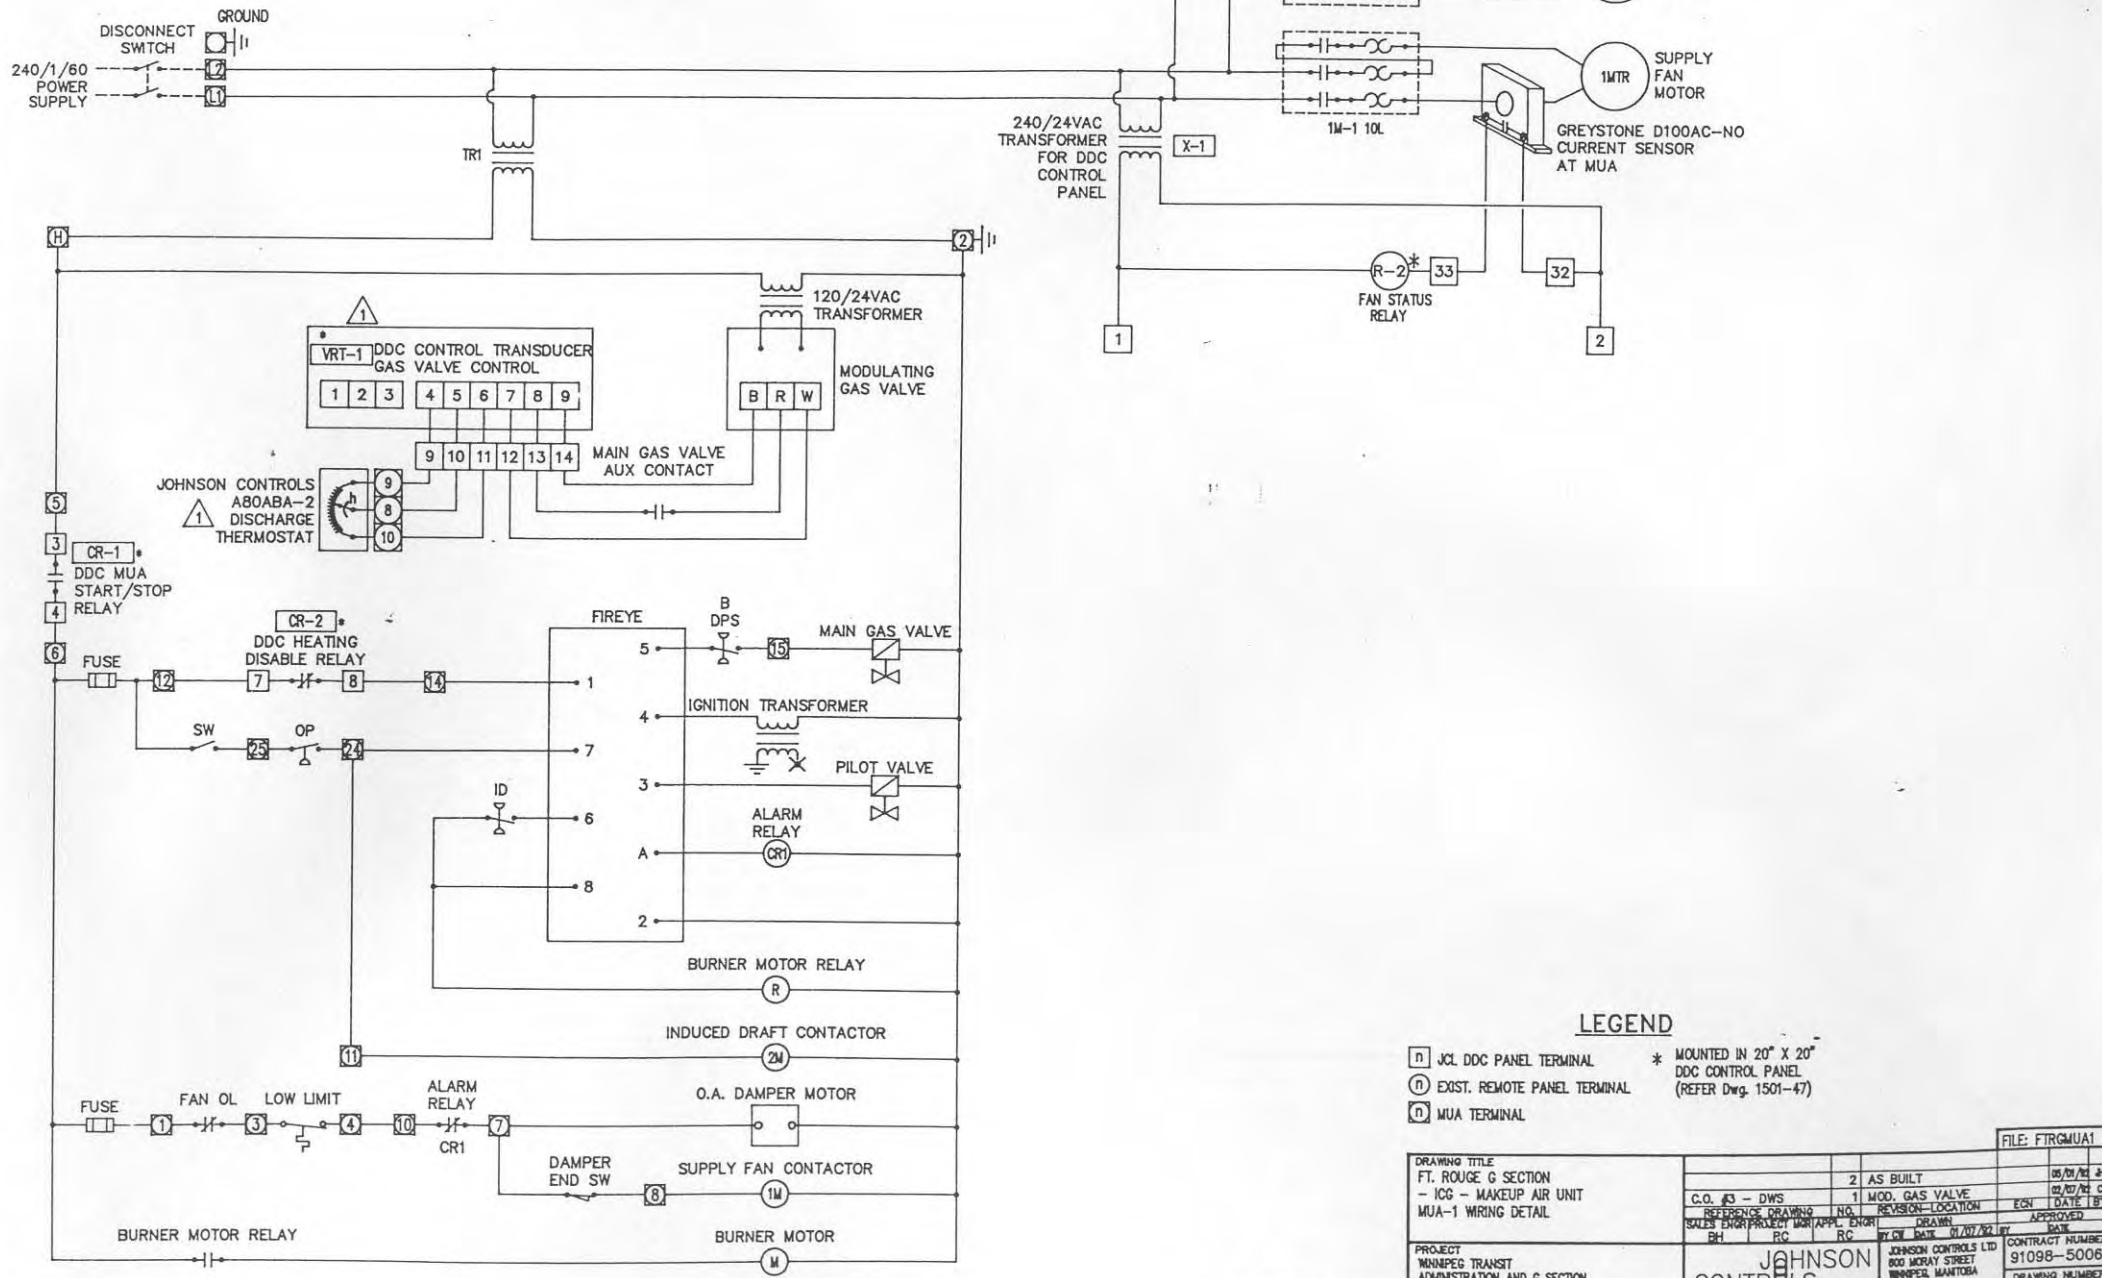

LEGEND

- JCL DDC PANEL TERMINAL * MOUNTED IN 20" X 20" DDC CONTROL PANEL (REFER Dwg. 1501-47)
- ⊙ EXST. REMOTE PANEL TERMINAL
- ⊞ MUA TERMINAL

DRAWING TITLE		AS BUILT		DATE	
FT. ROUGE G SECTION		1		05/07/92	
- ICG - MAKEUP AIR UNIT		MOD. GAS VALVE		DATE	
MUA-1 WIRING DETAIL		1		05/07/92	
PROJECT		SALES ENGR		APPROVED	
MINNEAPOLIS TRANSIT		RC		DATE	
ADMINISTRATION AND G SECTION		RC		DATE	
METASTASIS FACILITY		RC		DATE	
MANAGEMENT SYSTEM		RC		DATE	
CONTRACT NUMBER		CONTRACT NUMBER		CONTRACT NUMBER	
91098-5006		91098-5006		91098-5006	
DRAWING NUMBER		DRAWING NUMBER		DRAWING NUMBER	
1501-46A		1501-46A		1501-46A	